



FARMINGDALE STATE COLLEGE CAMPUS BUILDING FLOOR PLANS

TABLE OF CONTENTS

<u>ACADEMIC BUILDINGS</u>	<u>BUILDING NO.</u>	<u>PAGE NO.</u>	<u>ADMIN/SERVICE BUILDINGS</u>	<u>BUILDING NO.</u>	<u>PAGE NO.</u>	<u>DORMITORY</u>	<u>BUILDING NO.</u>	<u>PAGE NO.</u>
AVIATION CENTER	111	2	AG SERVICE BUILDING	075	49	ALUMNI HALL	065	83
SCHOOL OF BUSINESS	121	3	CAMPUS CENTER	008	50	DEWEY HALL	091	85
CONKLIN HALL	012	7	CAMPUS COMMONS	006	51	LEHMAN HALL	092	89
CUTLER HALL	003	9	CCI BUILDING	078	52	ORCHARD HALL	115	93
GLEESON HALL	007	13	DAY CARE CENTER	120	53			
GREENHOUSE	04	17	HAY BARN	079	54			
GREENLEY LIBRARY	18	18	HEALTH & WELLNESS CENTER	089	55			
HALE HALL	014	22	HEATING PLANT	071	56			
HICK'S HALL	005	25	HORTON HALL	054	58			
HOOPER HALL	015	29	KNAPP HALL	040	61			
LUPTON HALL	063	33	LAFFIN HALL	002	64			
NOLD HALL	085	36	MEMORIAL HALL	066	67			
ROOSEVELT HALL	042	37	MODULE TRAILER	019	69			
SINCLAIR HALL	094	40	MODULE TRAILER #2		70			
THOMPSON HALL	041	43	POLICE HEADQUARTERS	046	71			
WHITMAN HALL	050	46	THE COTTAGE	001	72			
			POULTRY BUILDING	077	75			
			SBDC BUILDING	076	76			
			SERVICE BUILDING	070	77			
			STORAGE BUILDING	029	78			
			WARD HALL	011	79			

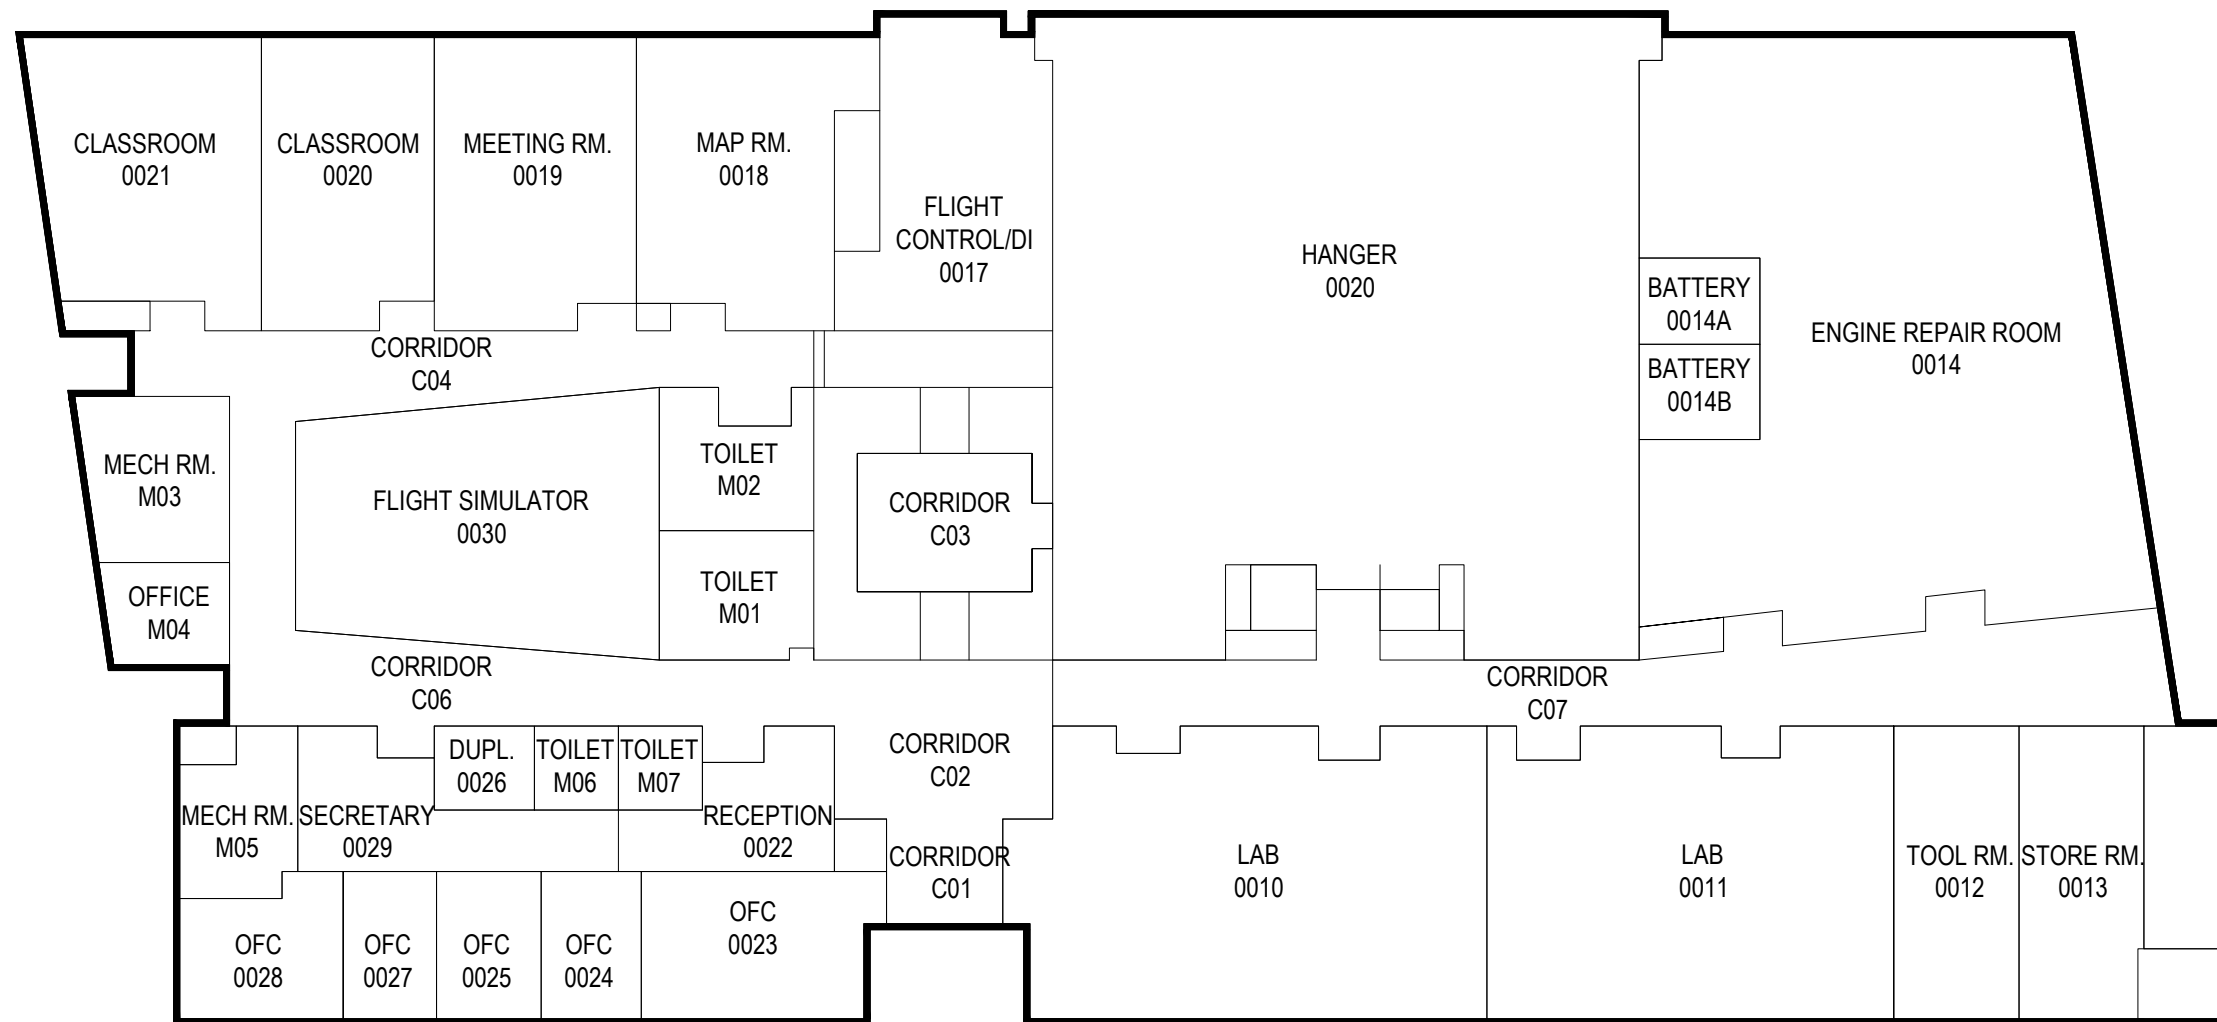

 FIRST FLOOR PLAN



CLIENT

Farmingdale State College

SCALE:

1"=30'

DATE:


JUNE-2015

Aviation Center - 111



architects + engineers

Melville, NY Albany, NY
New City, NY Parsippany, NJ

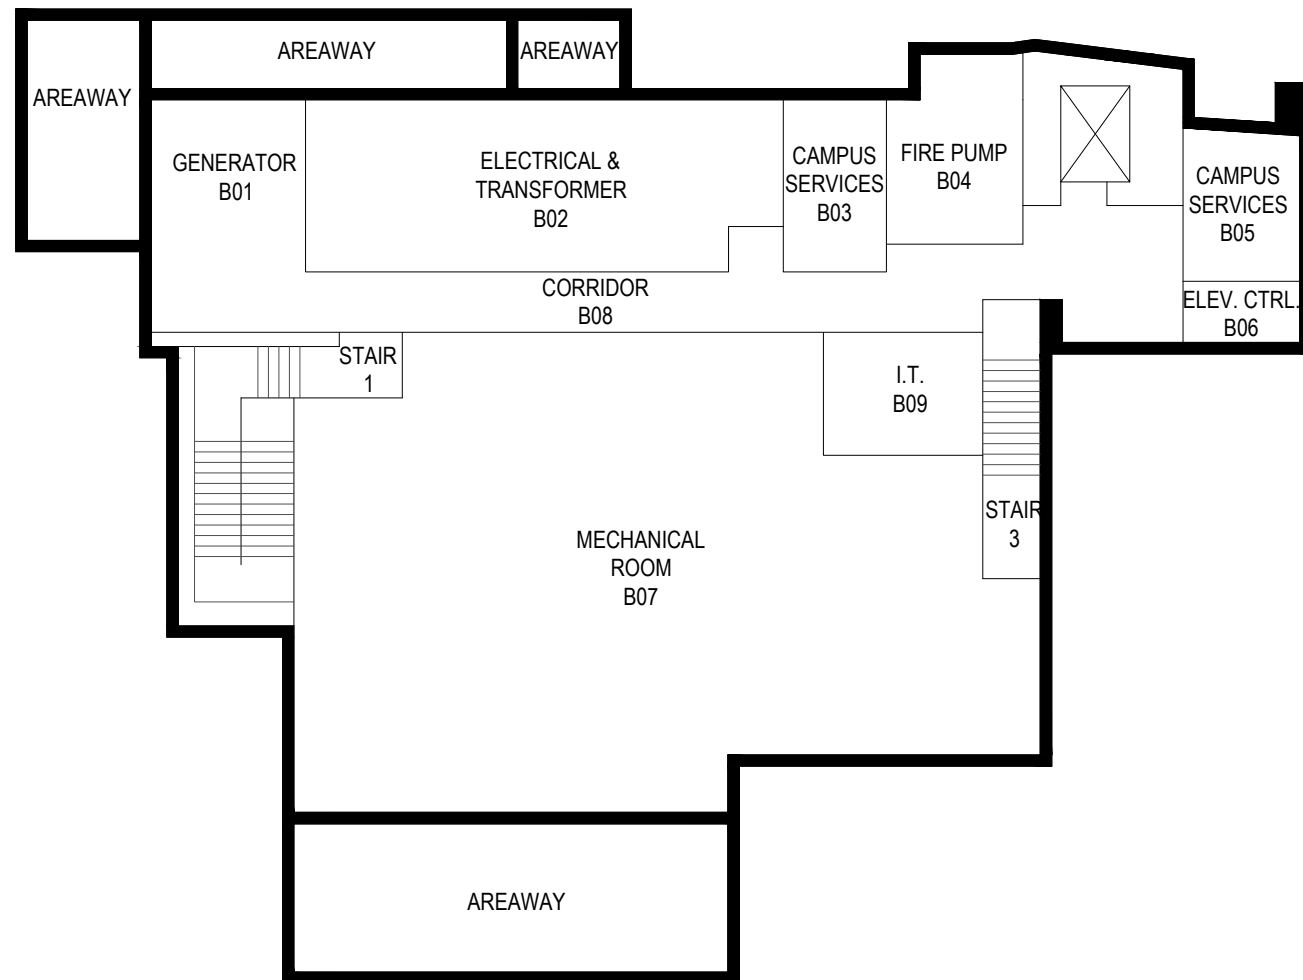

BASEMENT FLOOR PLAN



CLIENT

Farmingdale State College

SCALE:

1/16"=1'-0"

DATE:


JUNE-2015

School of Business - 121

REF. Drawing
SUFA 15-01

H	2	architects + engineers
M		
Melville, NY Albany, NY New City, NY Parsippany, NJ		

3

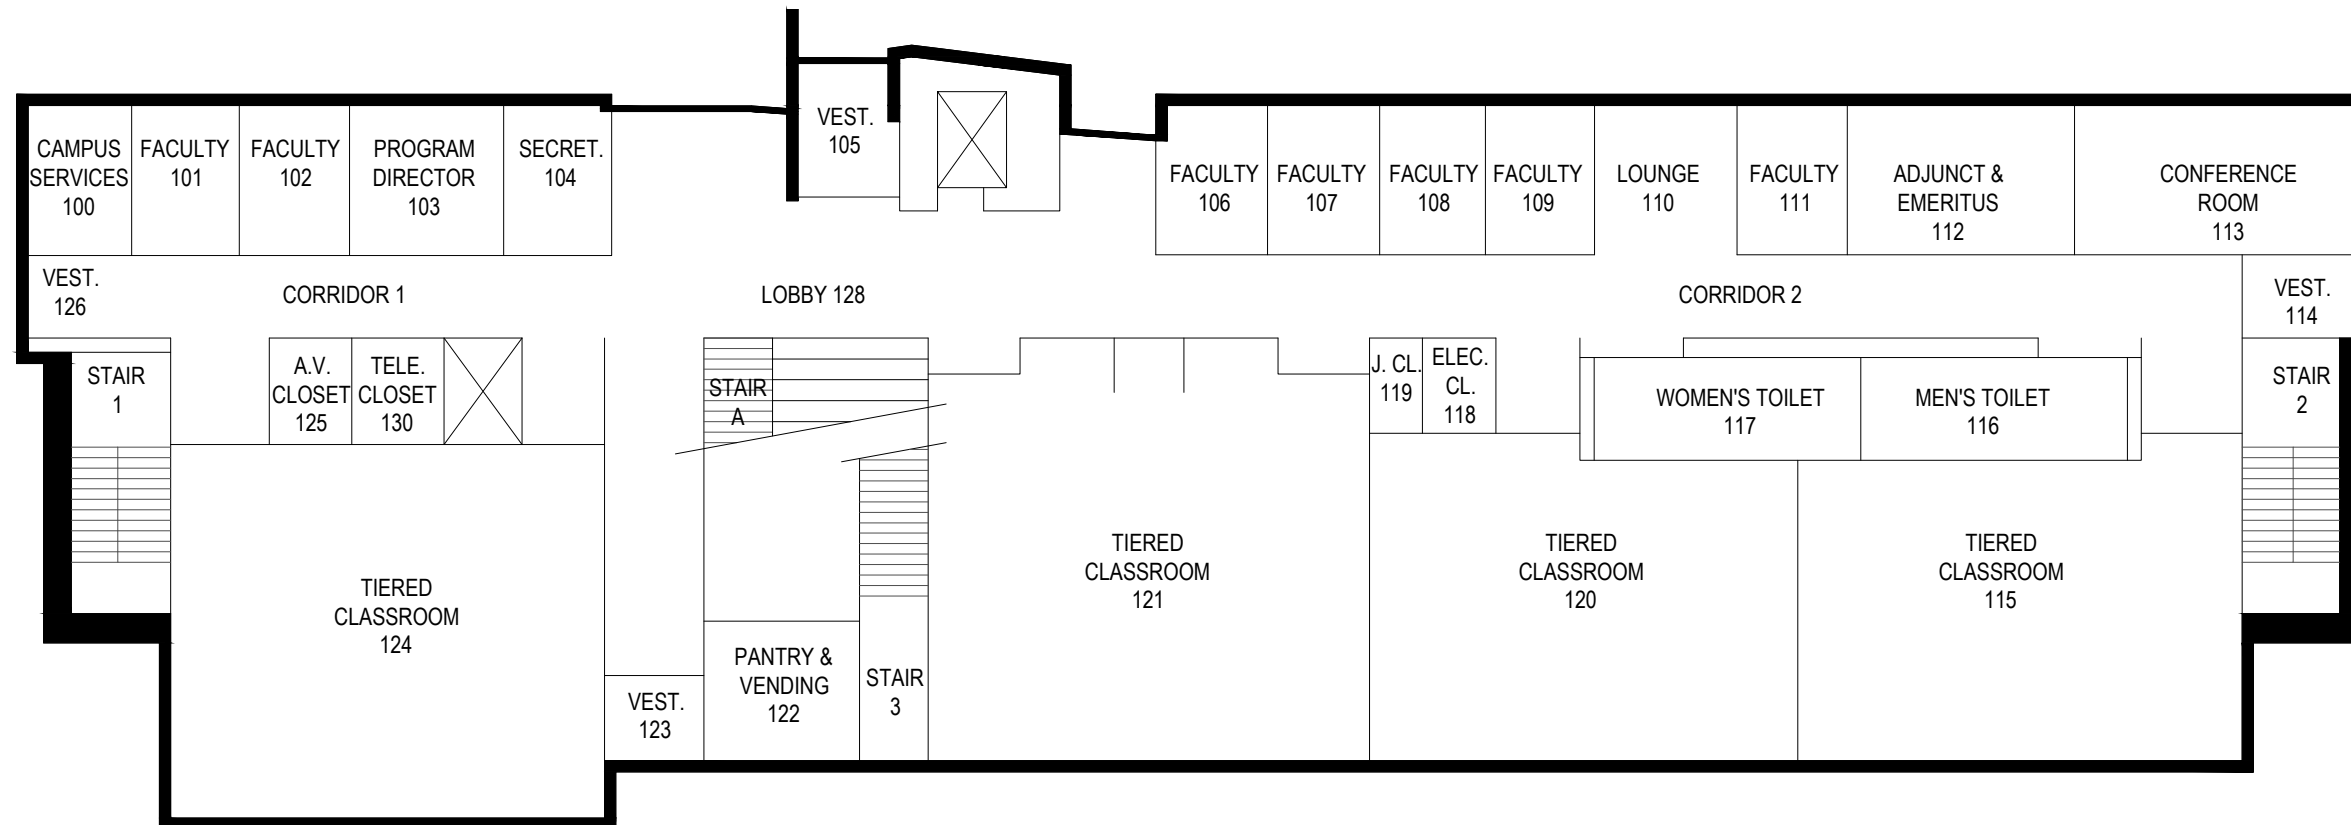

FIRST FLOOR PLAN



CLIENT

Farmingdale State College


SCALE:

1/16"=1'-0"

DATE:


JUNE-2015

School of Business - 121

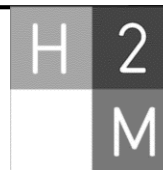

architects + engineers

Melville, NY Albany, NY
New City, NY Parsippany, NJ

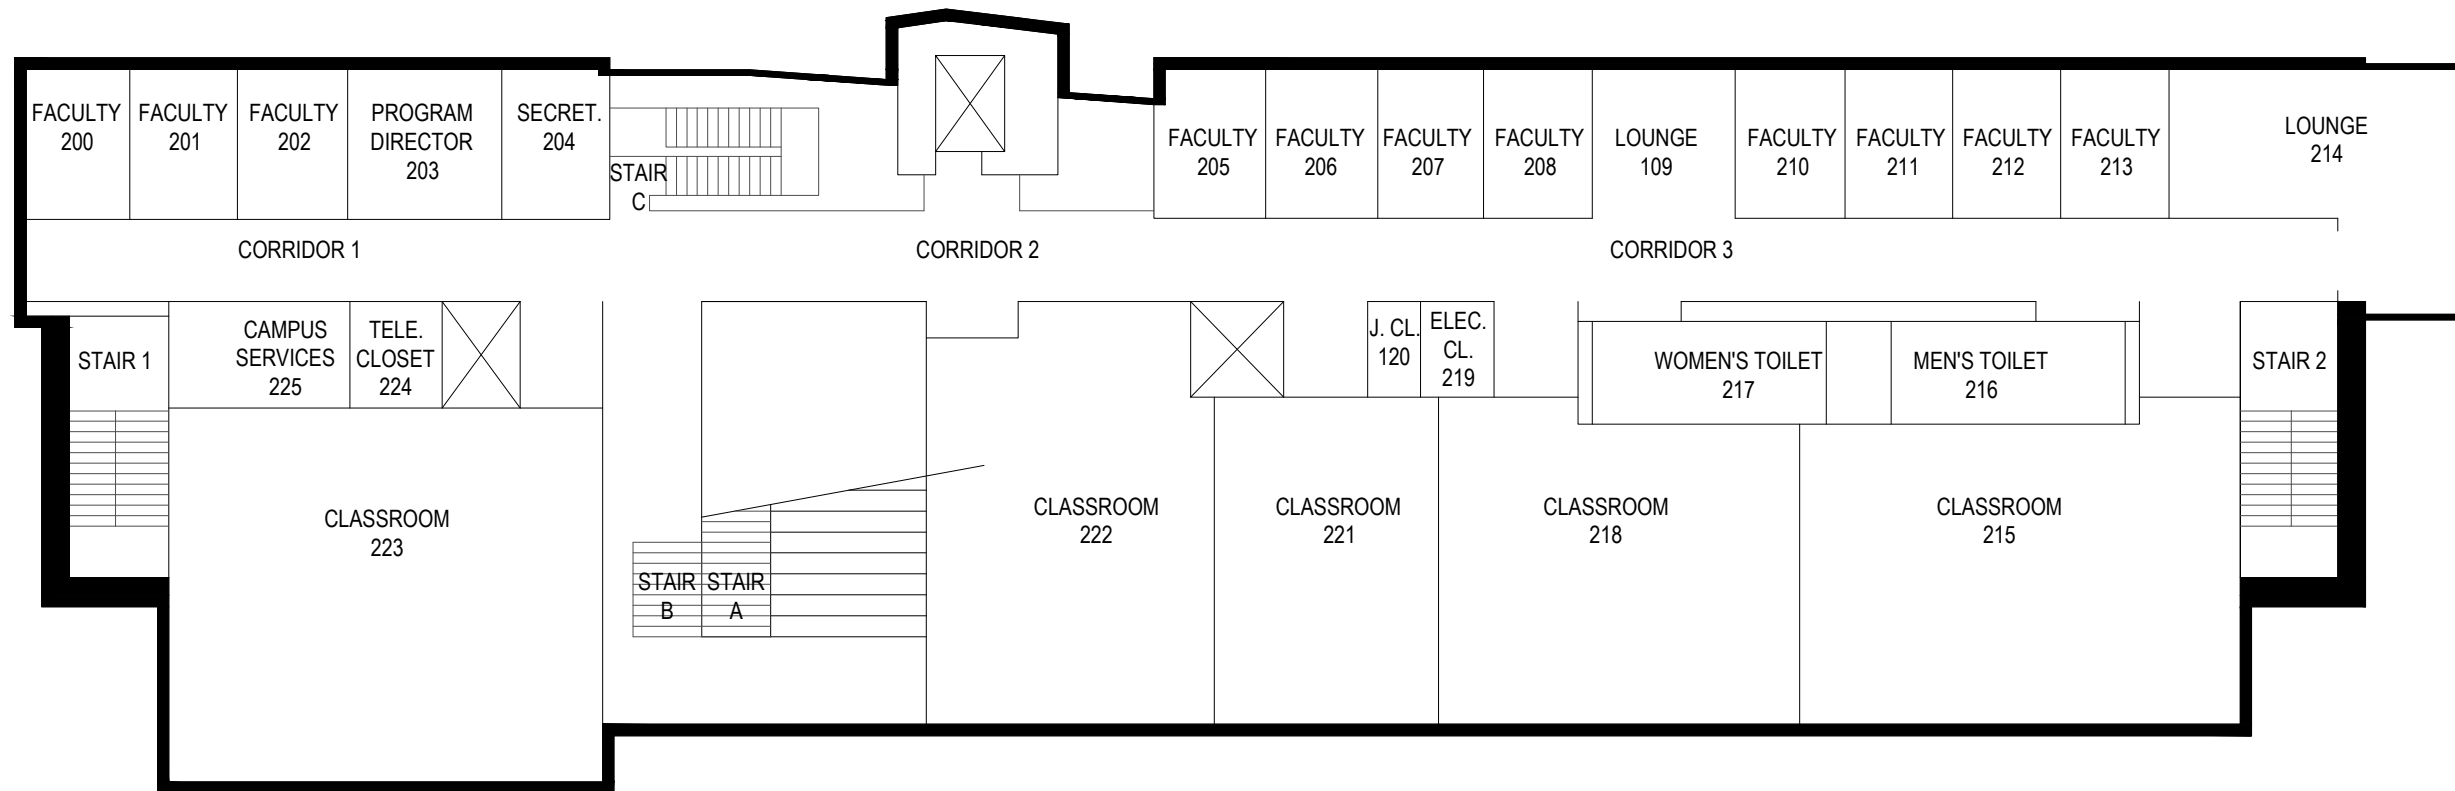

SECOND FLOOR PLAN



CLIENT

Farmingdale State College

SCALE:


1/16"=1'-0"

DATE:

JUNE-2015


School of Business - 121

REF. Drawing
SUFA 15-01

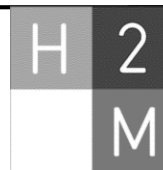

architects + engineers

Melville, NY Albany, NY
New City, NY Parsippany, NJ

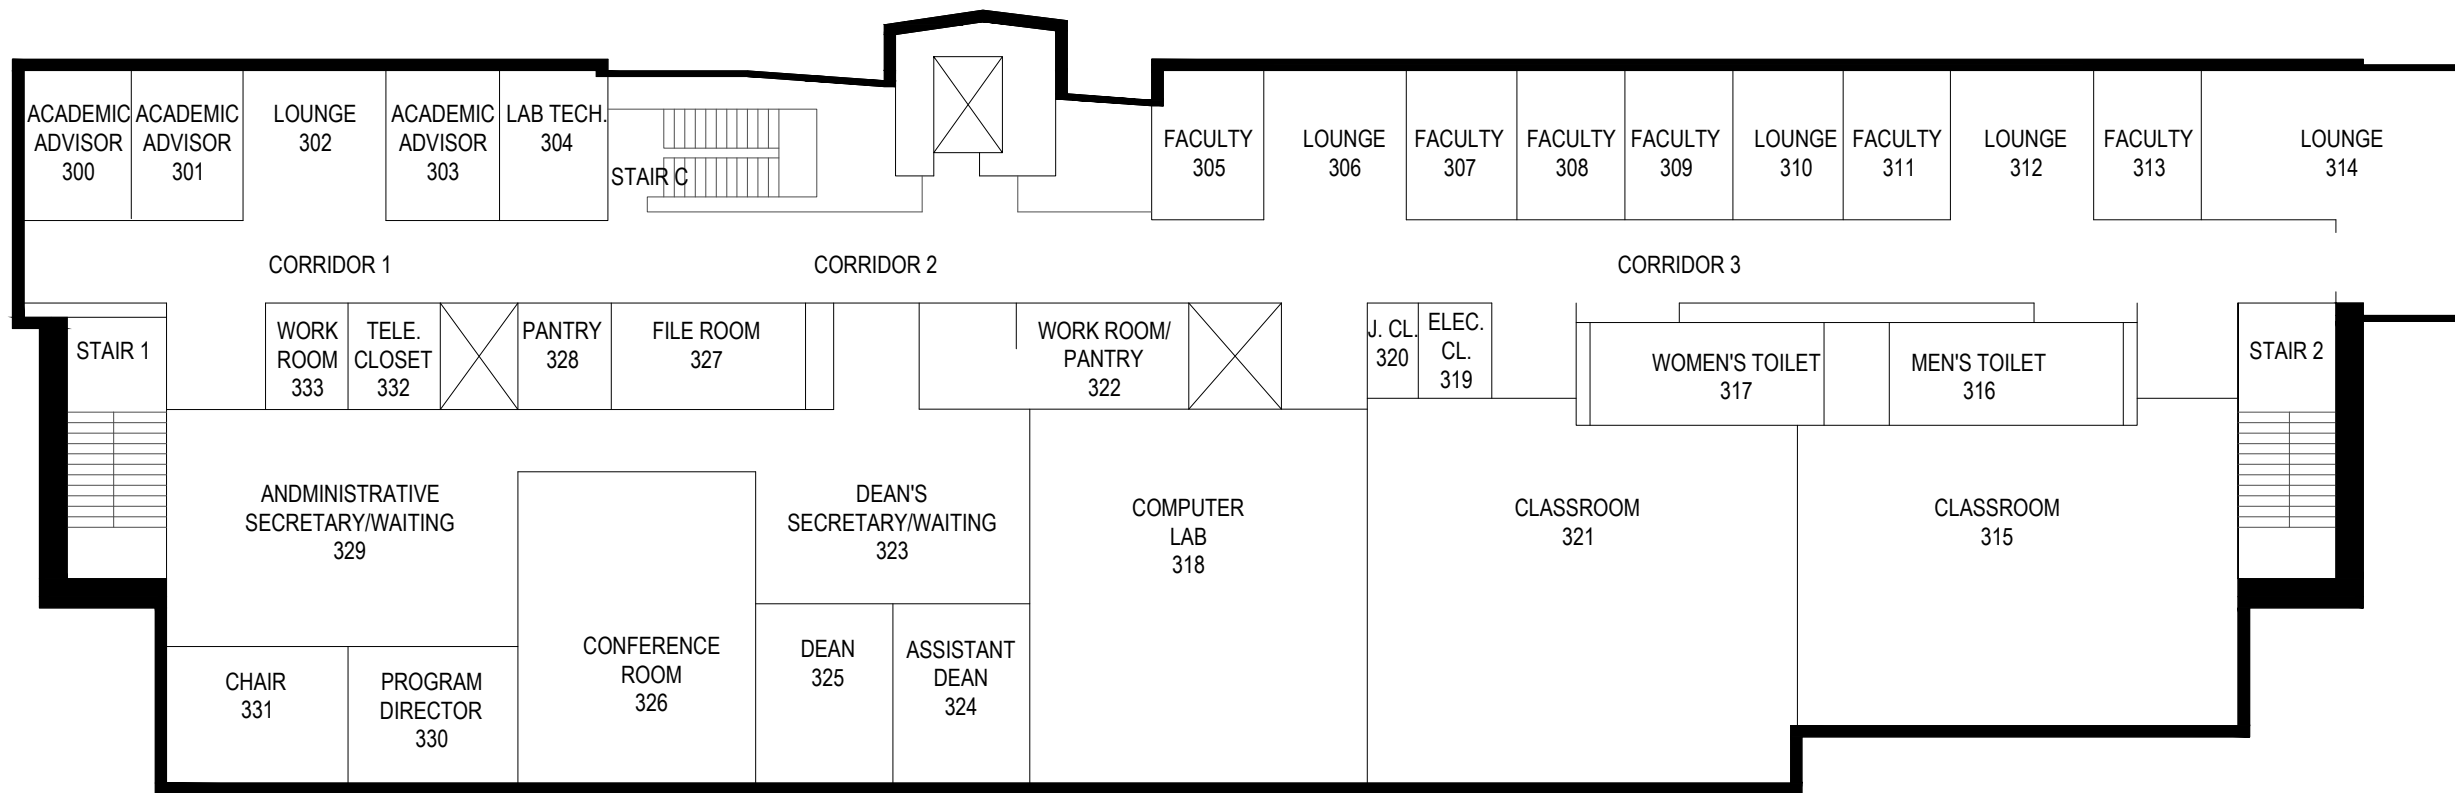

THIRD FLOOR PLAN



CLIENT

Farmingdale State College

SCALE:


1/16"=1'-0"

DATE:

JUNE-2015


School of Buisness - 121

REF. Drawing
SUFA 15-01

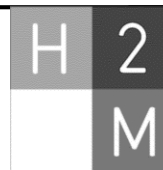

architects + engineers

Melville, NY Albany, NY
New City, NY Parsippany, NJ

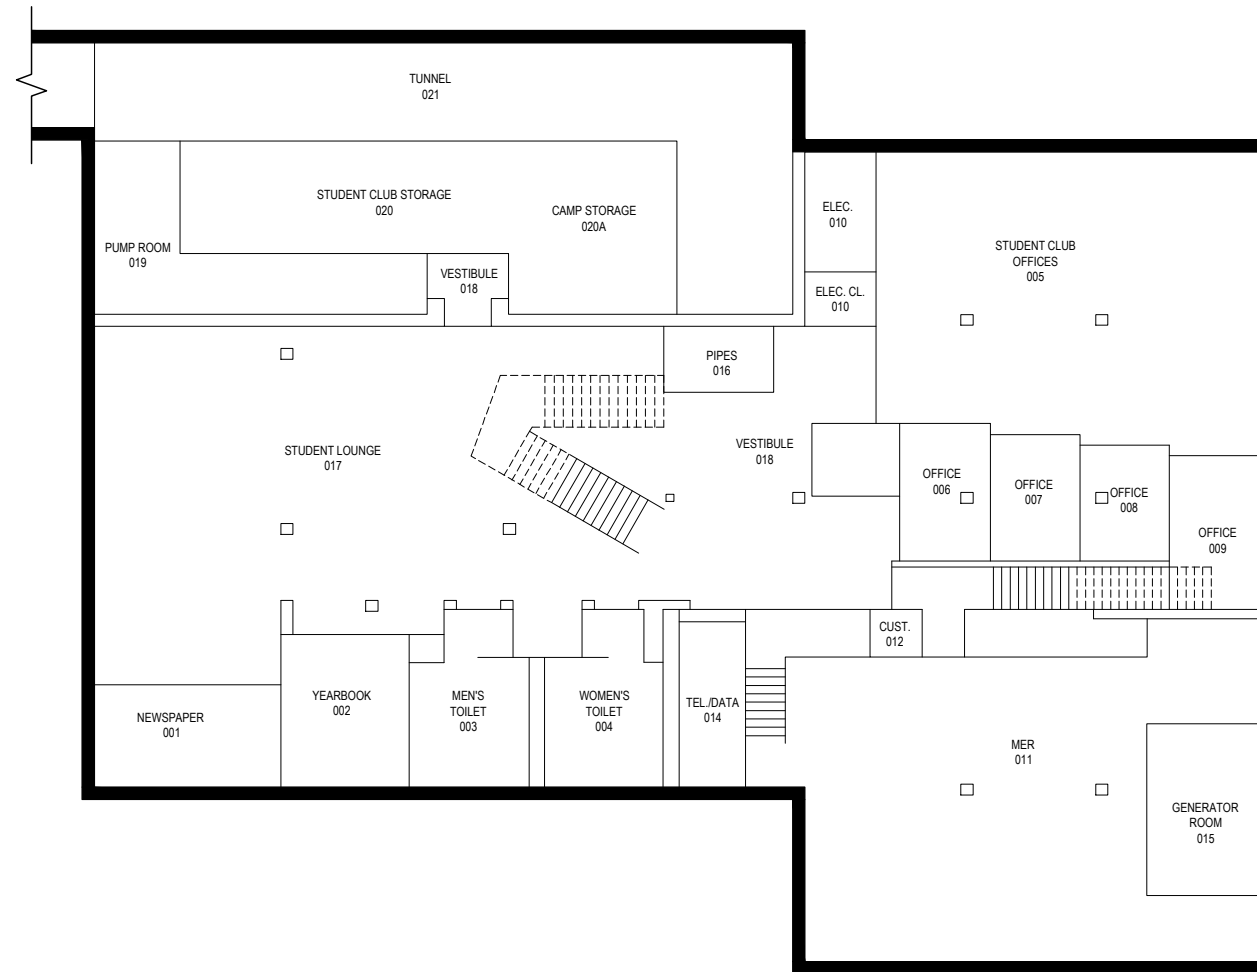

BASEMENT FLOOR PLAN



CLIENT

Farmingdale State College

SCALE:

1/16"=1'-0"


DATE:

JUNE-2015

Conklin - 012

REF. Drawing
SUFA 15-01

H	2	architects + engineers
M		
		Melville, NY Albany, NY New City, NY Parsippany, NJ

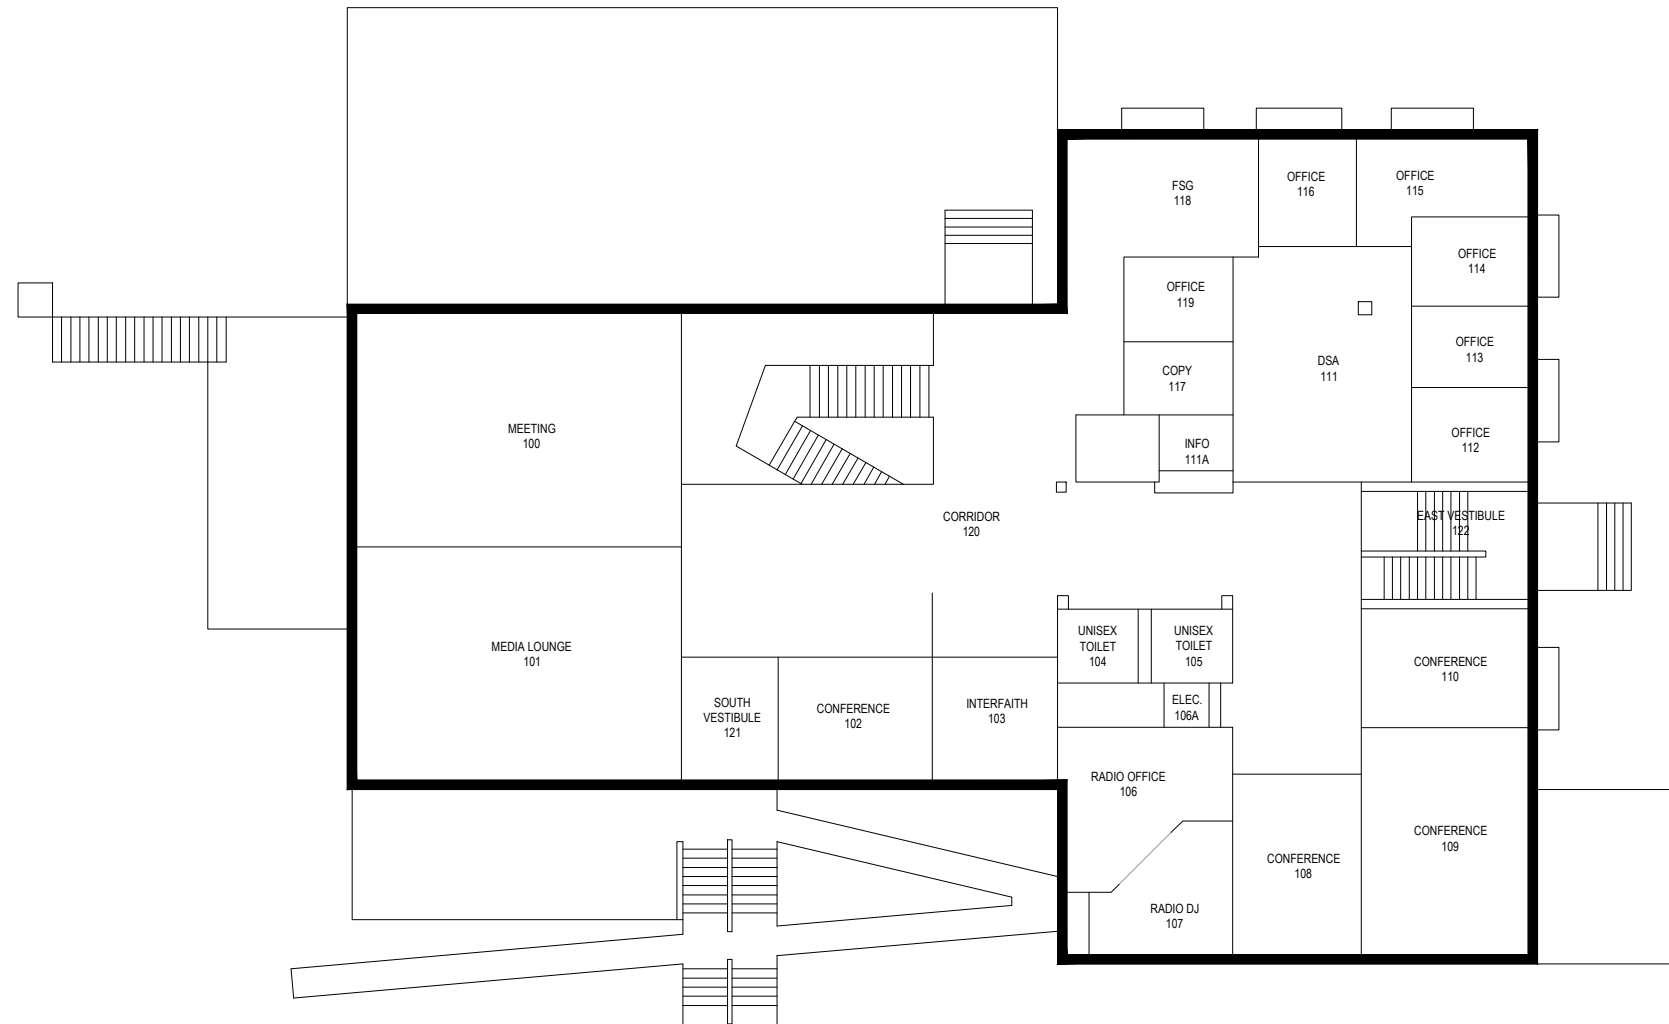

FIRST FLOOR PLAN



CLIENT

Farmingdale State College

SCALE:


1/16"=1'-0"

DATE:

JUNE-2015

Conklin - 012

H	2	architects + engineers
		Melville, NY Albany, NY New City, NY Parsippany, NJ

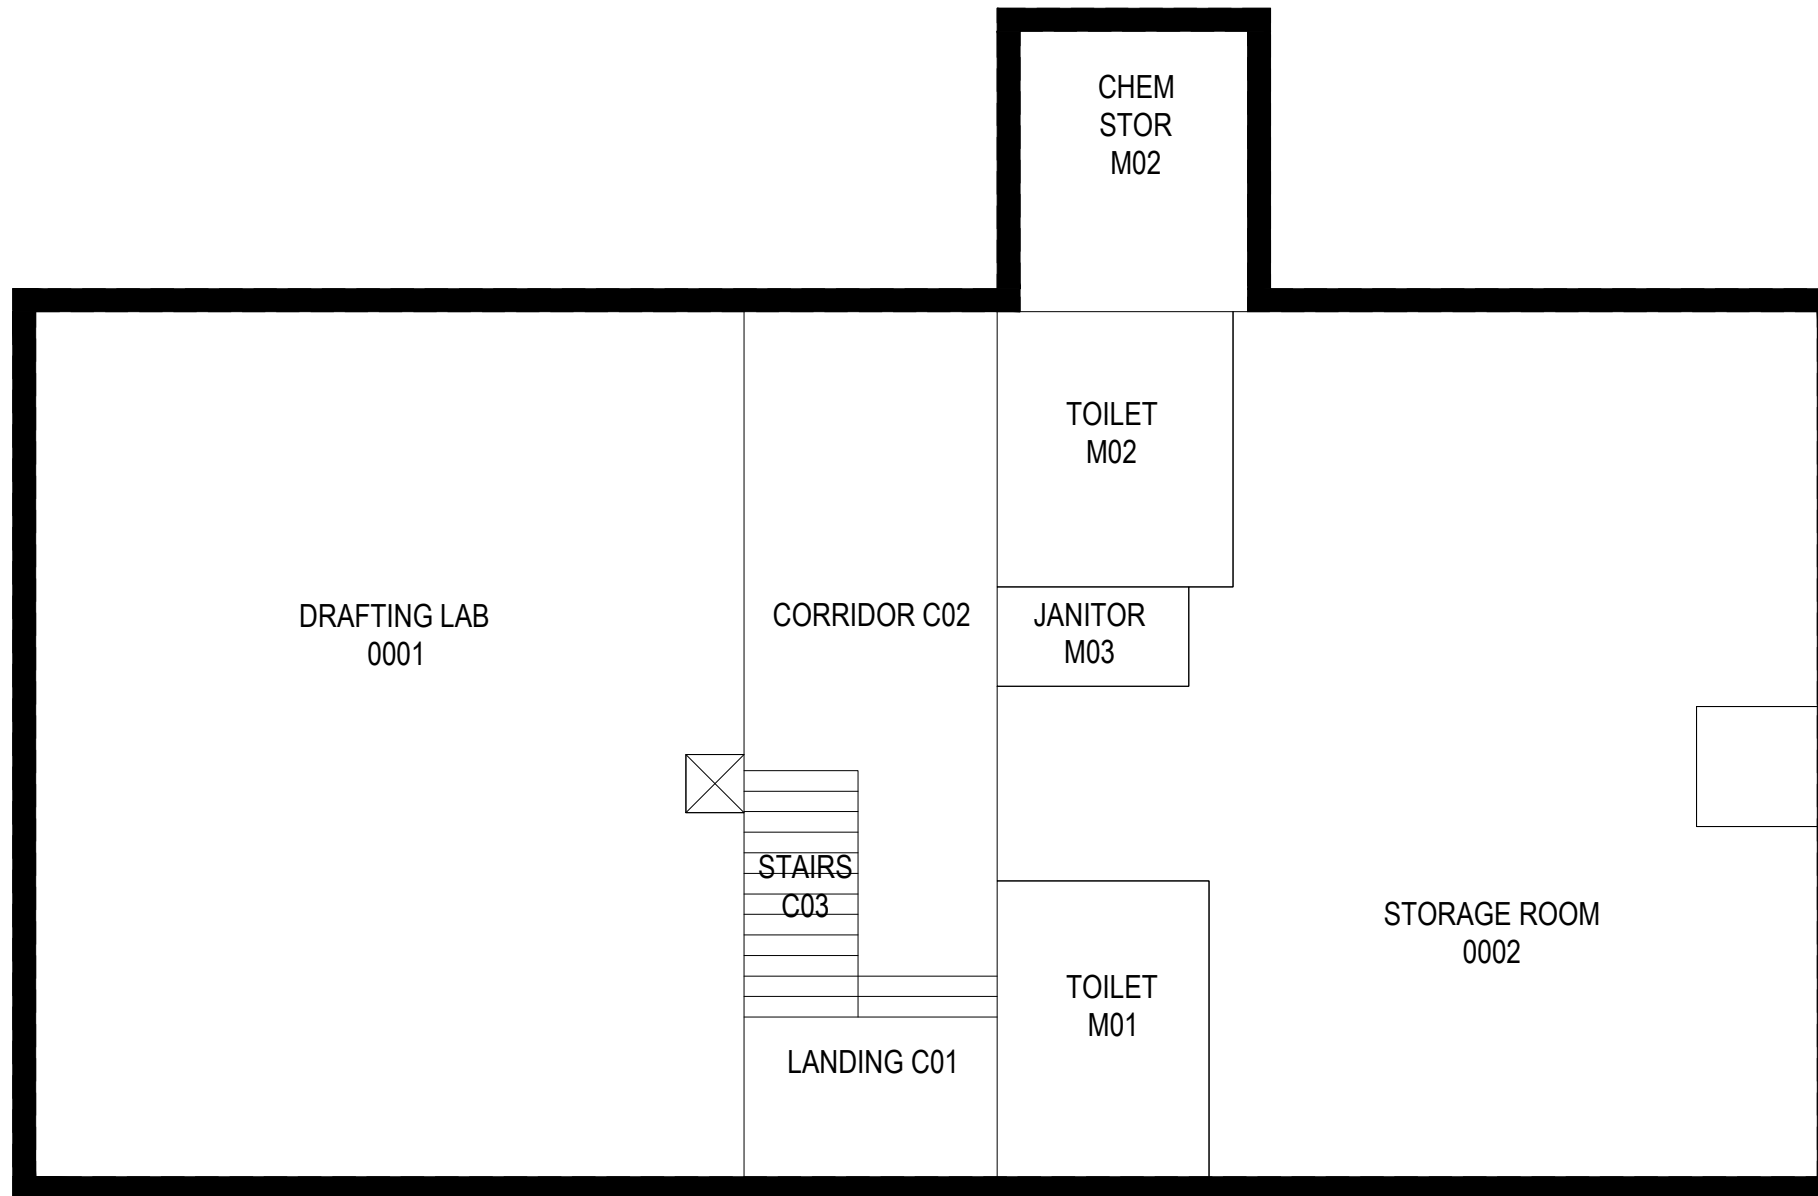

BASEMENT FLOOR PLAN



CLIENT

Farmingdale State College

SCALE:

1/8"=1'-0"

DATE:


JUNE-2015

Cutler Hall- 003



architects + engineers

Melville, NY Albany, NY
New City, NY Parsippany, NJ

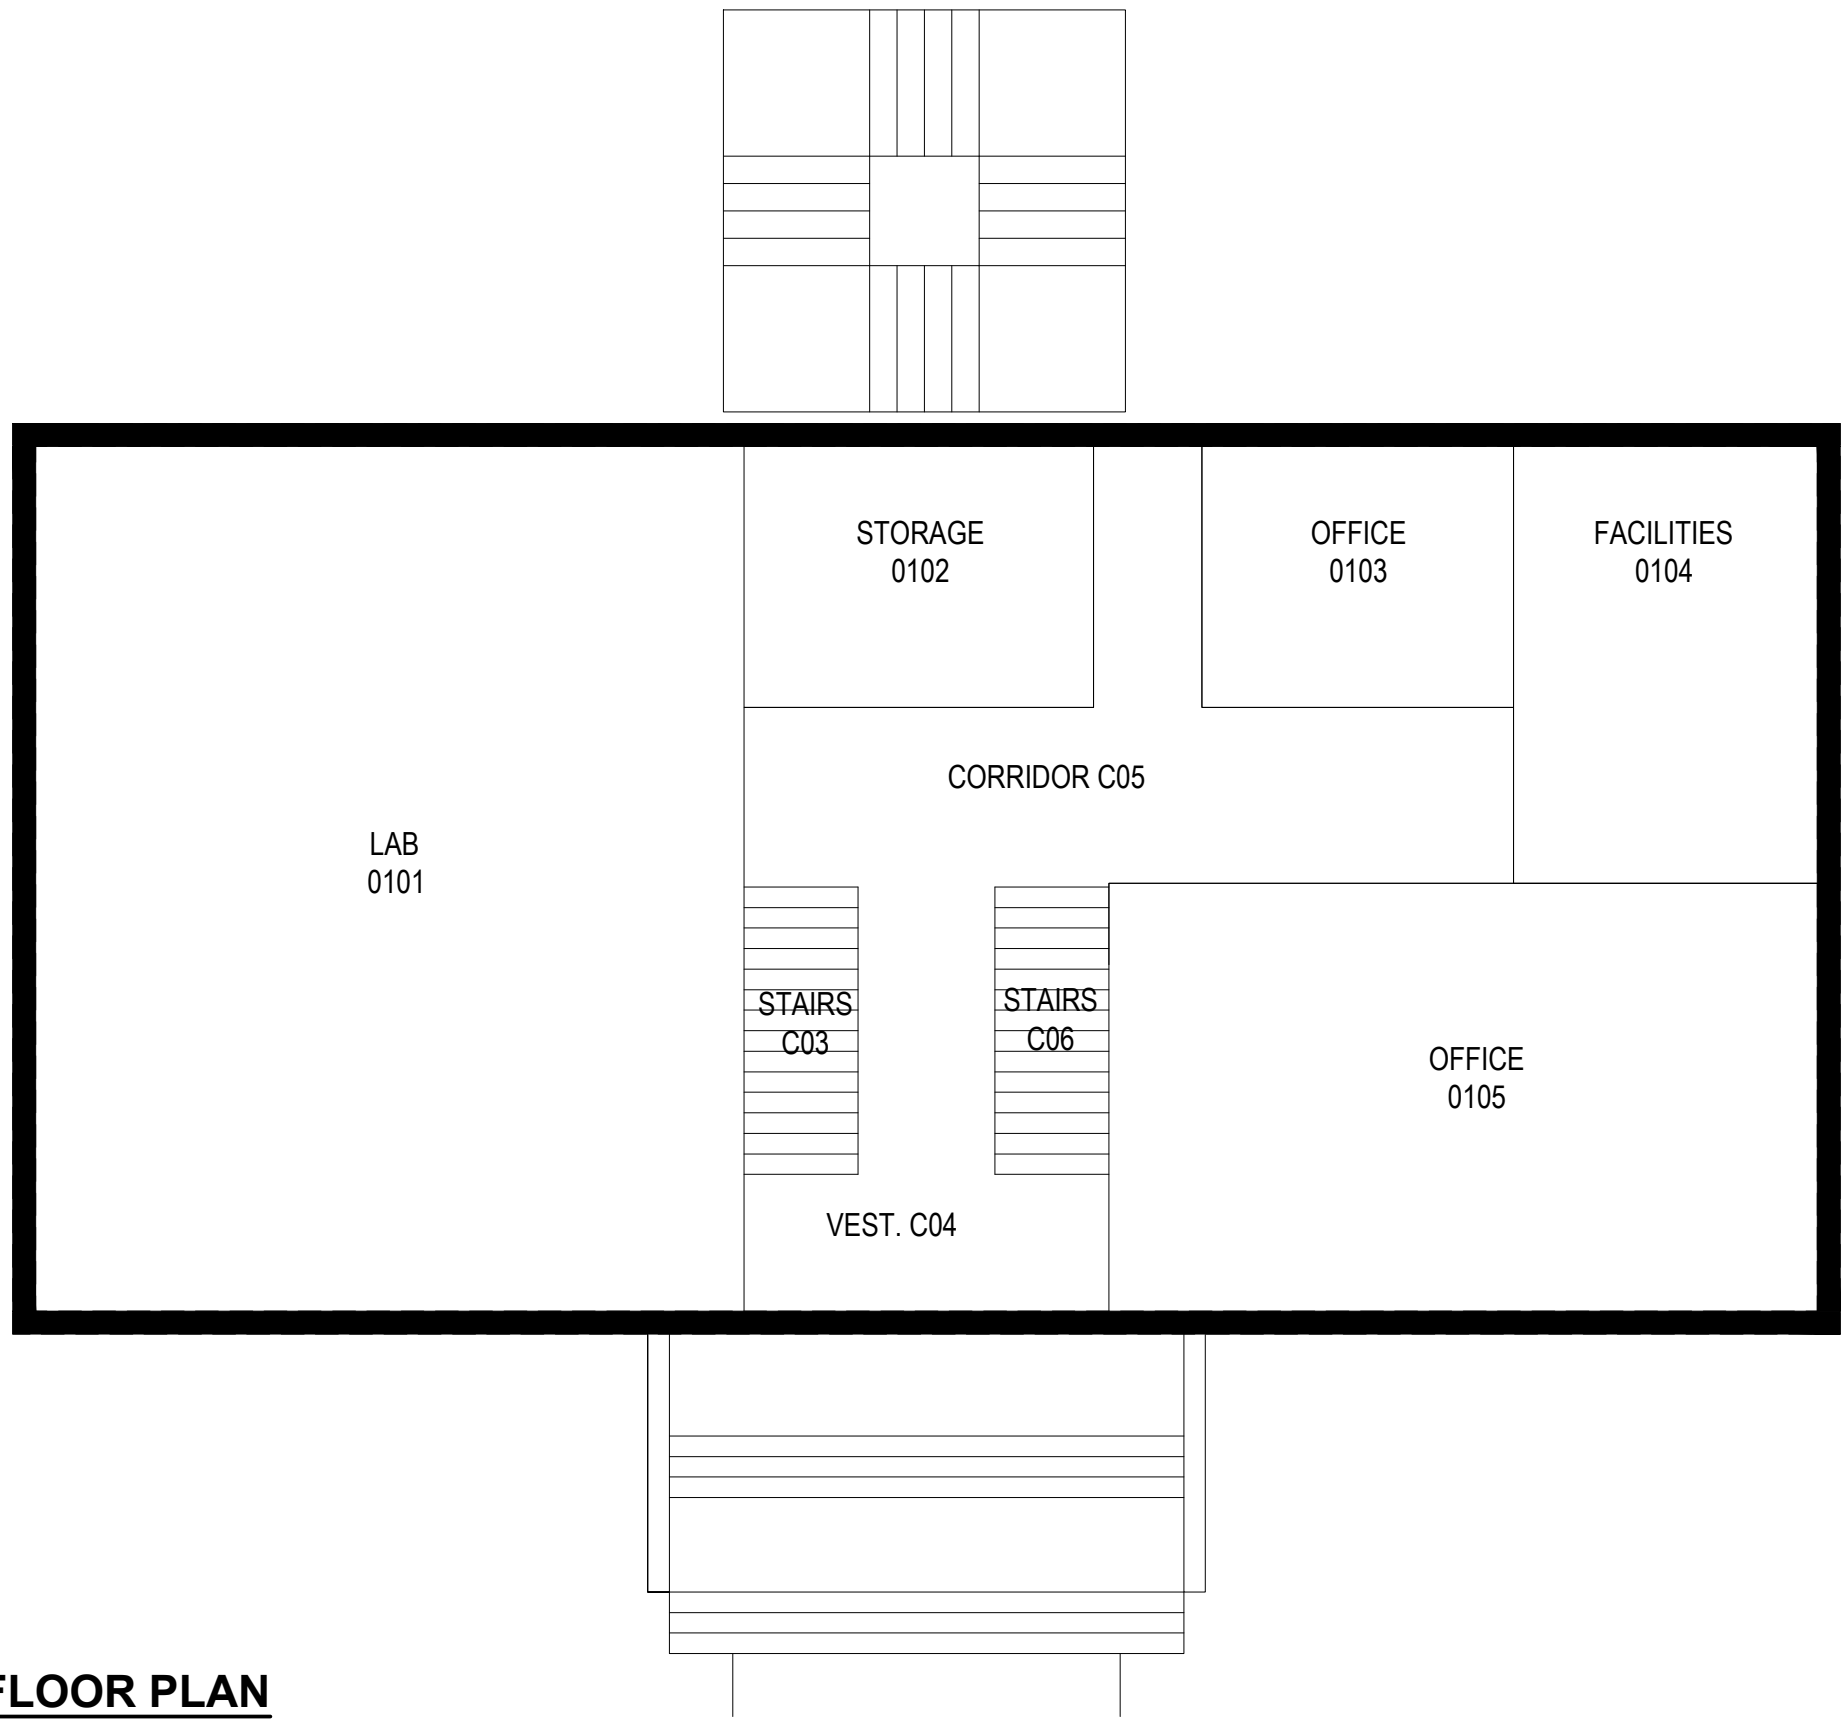

FIRST FLOOR PLAN



CLIENT

Farmingdale State College

SCALE:


1/8"=1'-0"

DATE:

JUNE-2015



Cutler Hall- 003

REF. Drawing
SUFA 15-01

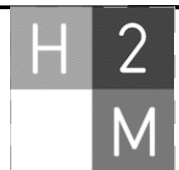

architects + engineers

Melville, NY Albany, NY
New City, NY Parsippany, NJ

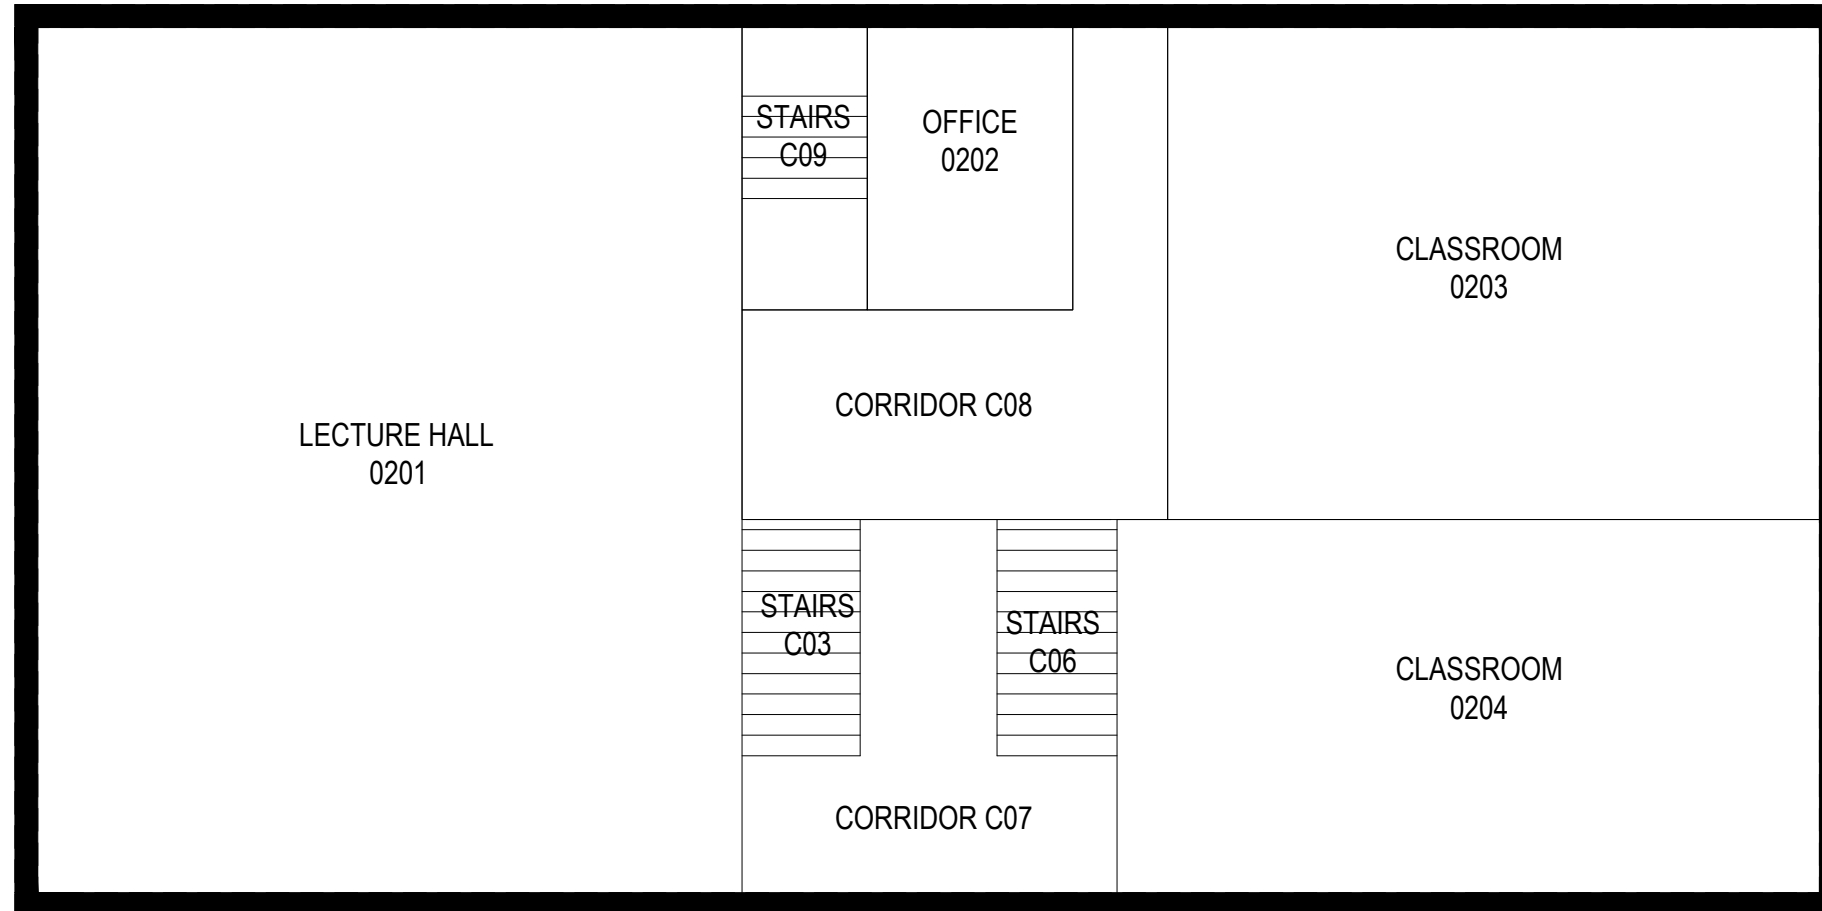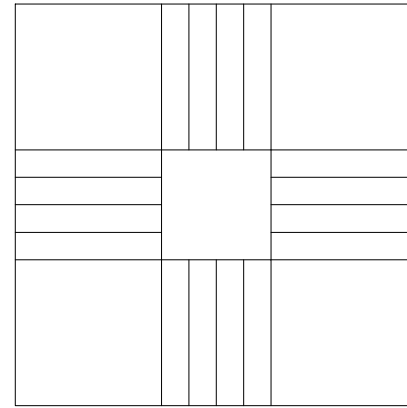

SECOND FLOOR PLAN



CLIENT

Farmingdale State College

SCALE:

1/8"=1'-0"

DATE:

JUNE-2015


Cutler Hall- 003

REF. Drawing
SUFA 15-01



architects + engineers

Melville, NY Albany, NY
New City, NY Parsippany, NJ

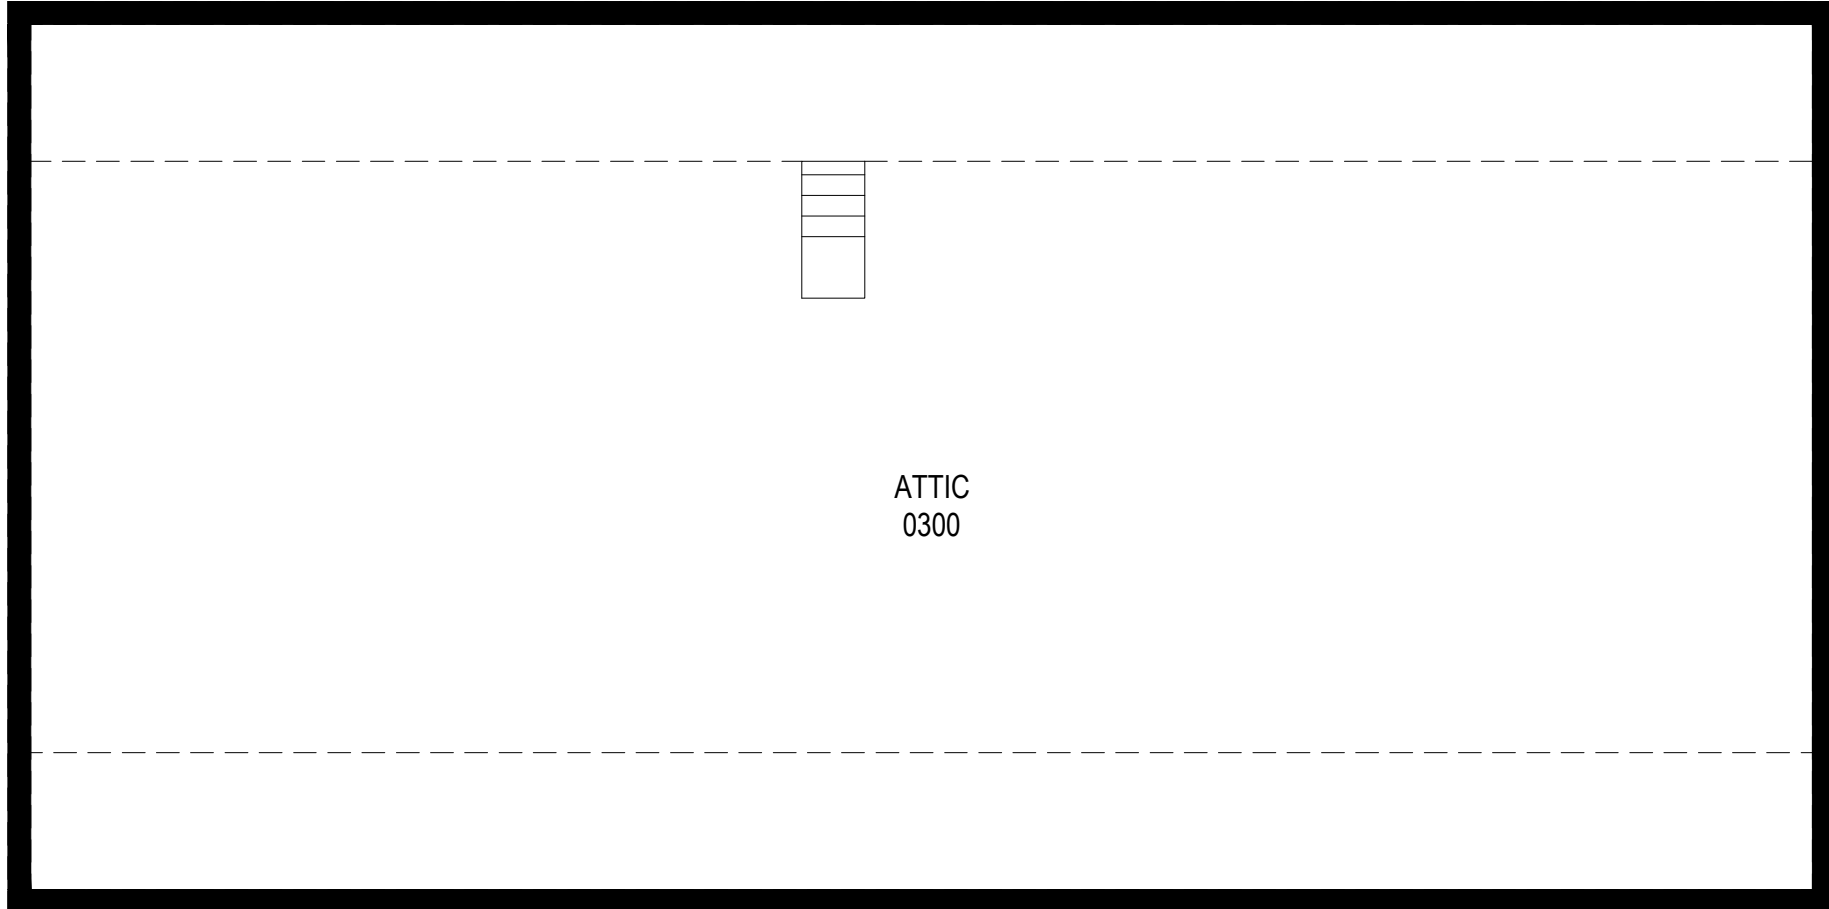

ATTIC
0300

THIRD FLOOR PLAN



CLIENT

Farmingdale State College

SCALE:

1/8"=1'-0"

DATE:

JUNE-2015

Cutler Hall- 003


REF. Drawing
SUFA 15-01



architects + engineers

Melville, NY Albany, NY
New City, NY Parsippany, NJ

12

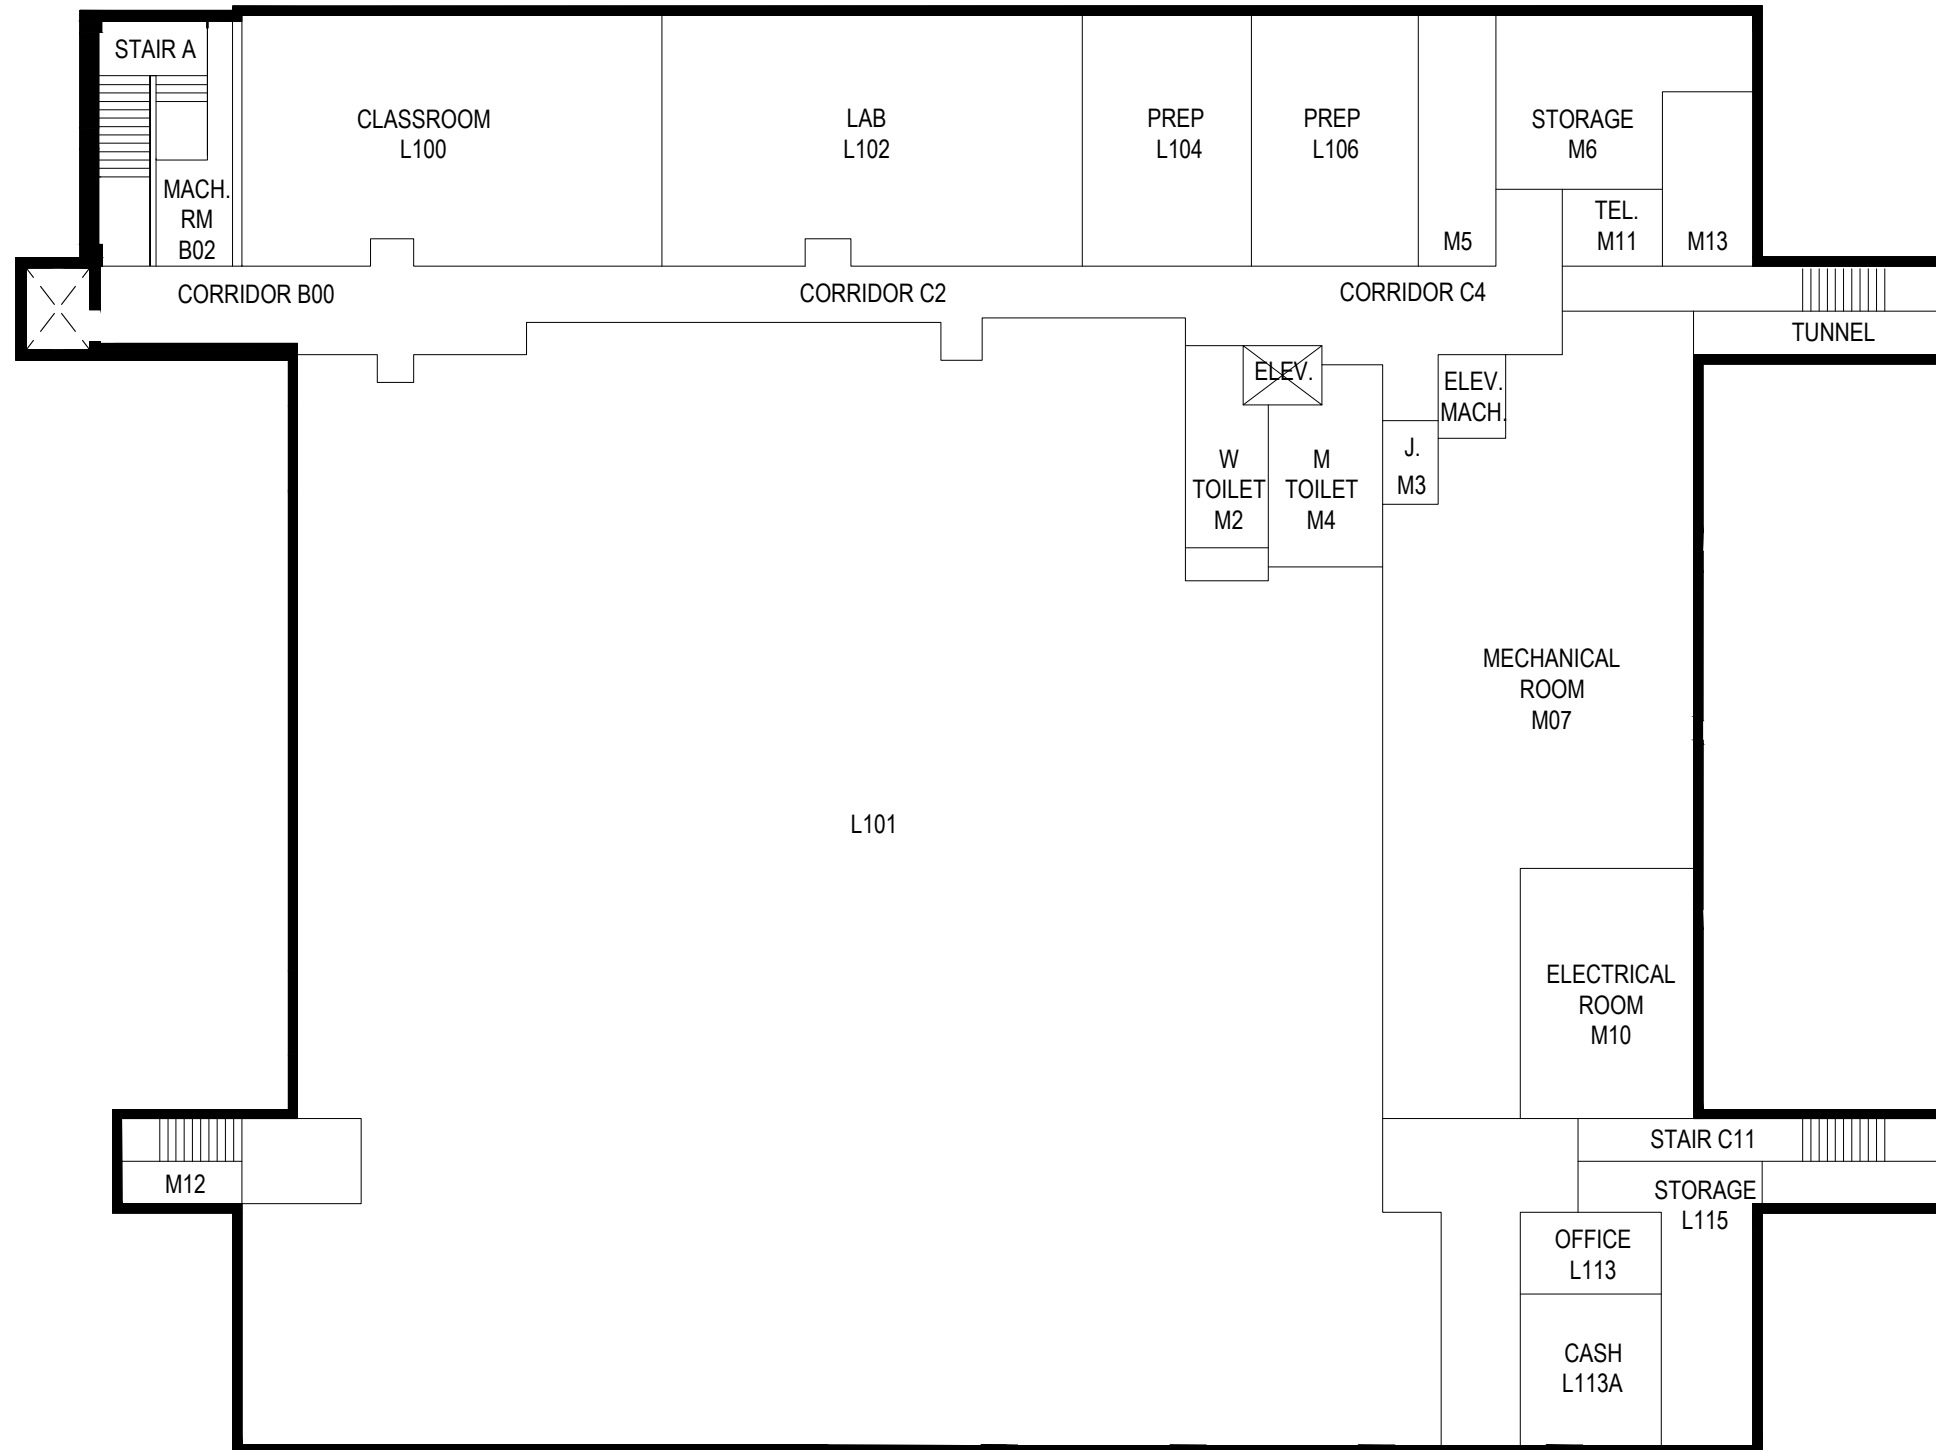

BASEMENT FLOOR PLAN



CLIENT

Farmingdale State College


SCALE:

1"=20'

DATE:


JUNE-2015

Gleeson - 007

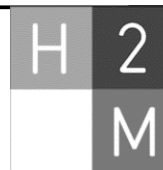

architects + engineers

Melville, NY Albany, NY
New City, NY Parsippany, NJ

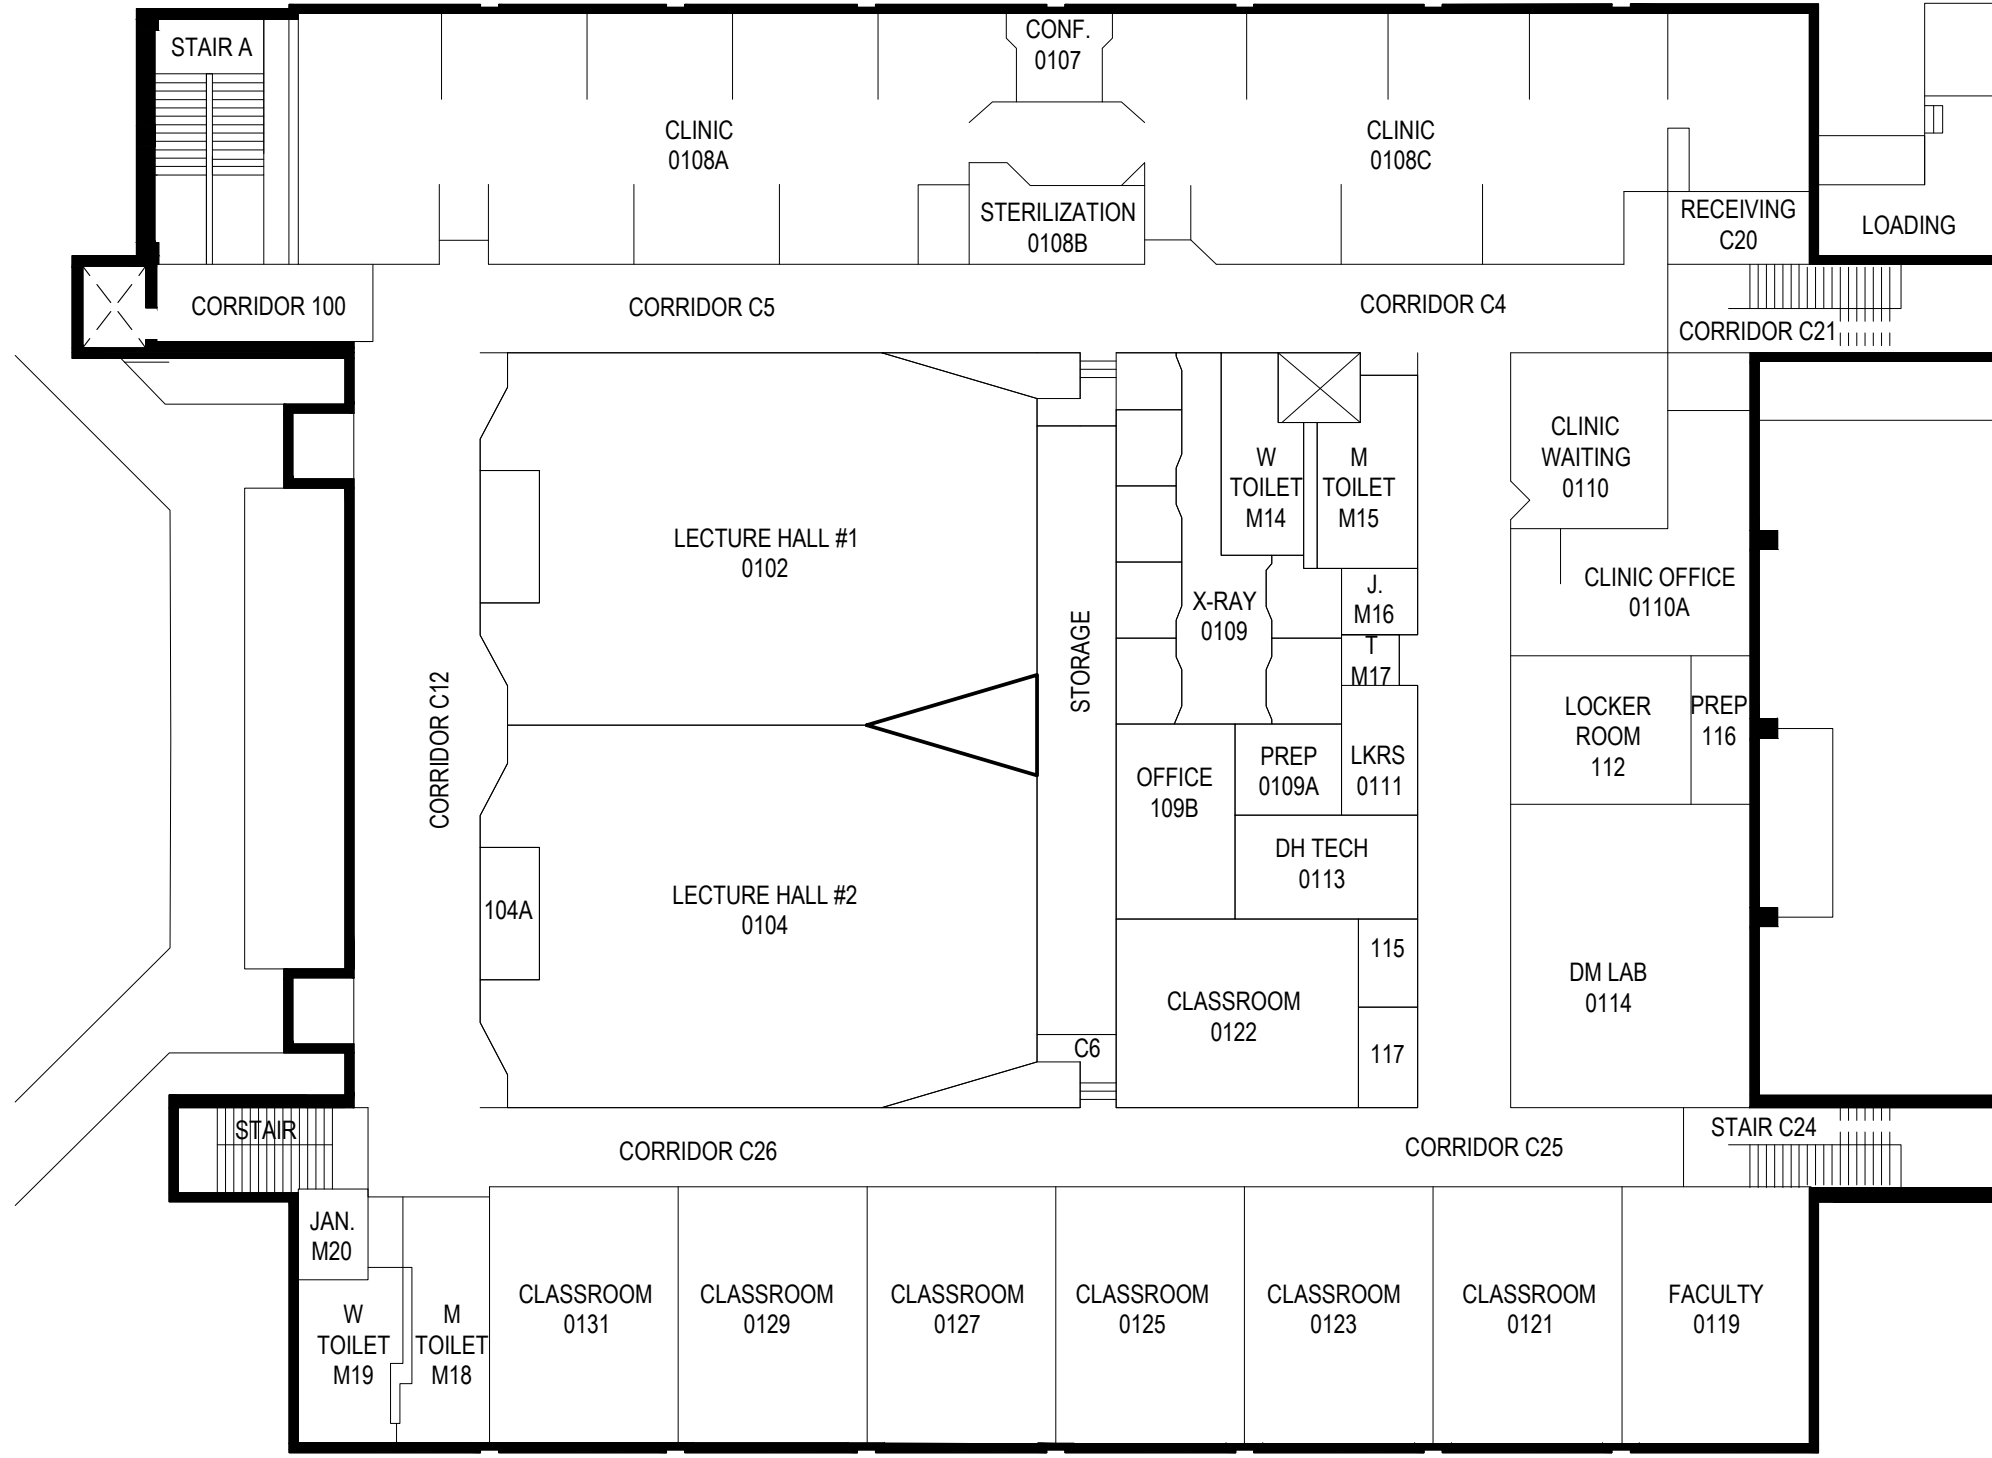

FIRST FLOOR PLAN



CLIENT

Farmingdale State College

SCALE:

1"=20'

DATE:


JUNE-2015

Gleeson - 007



architects + engineers

Melville, NY Albany, NY
New City, NY Parsippany, NJ

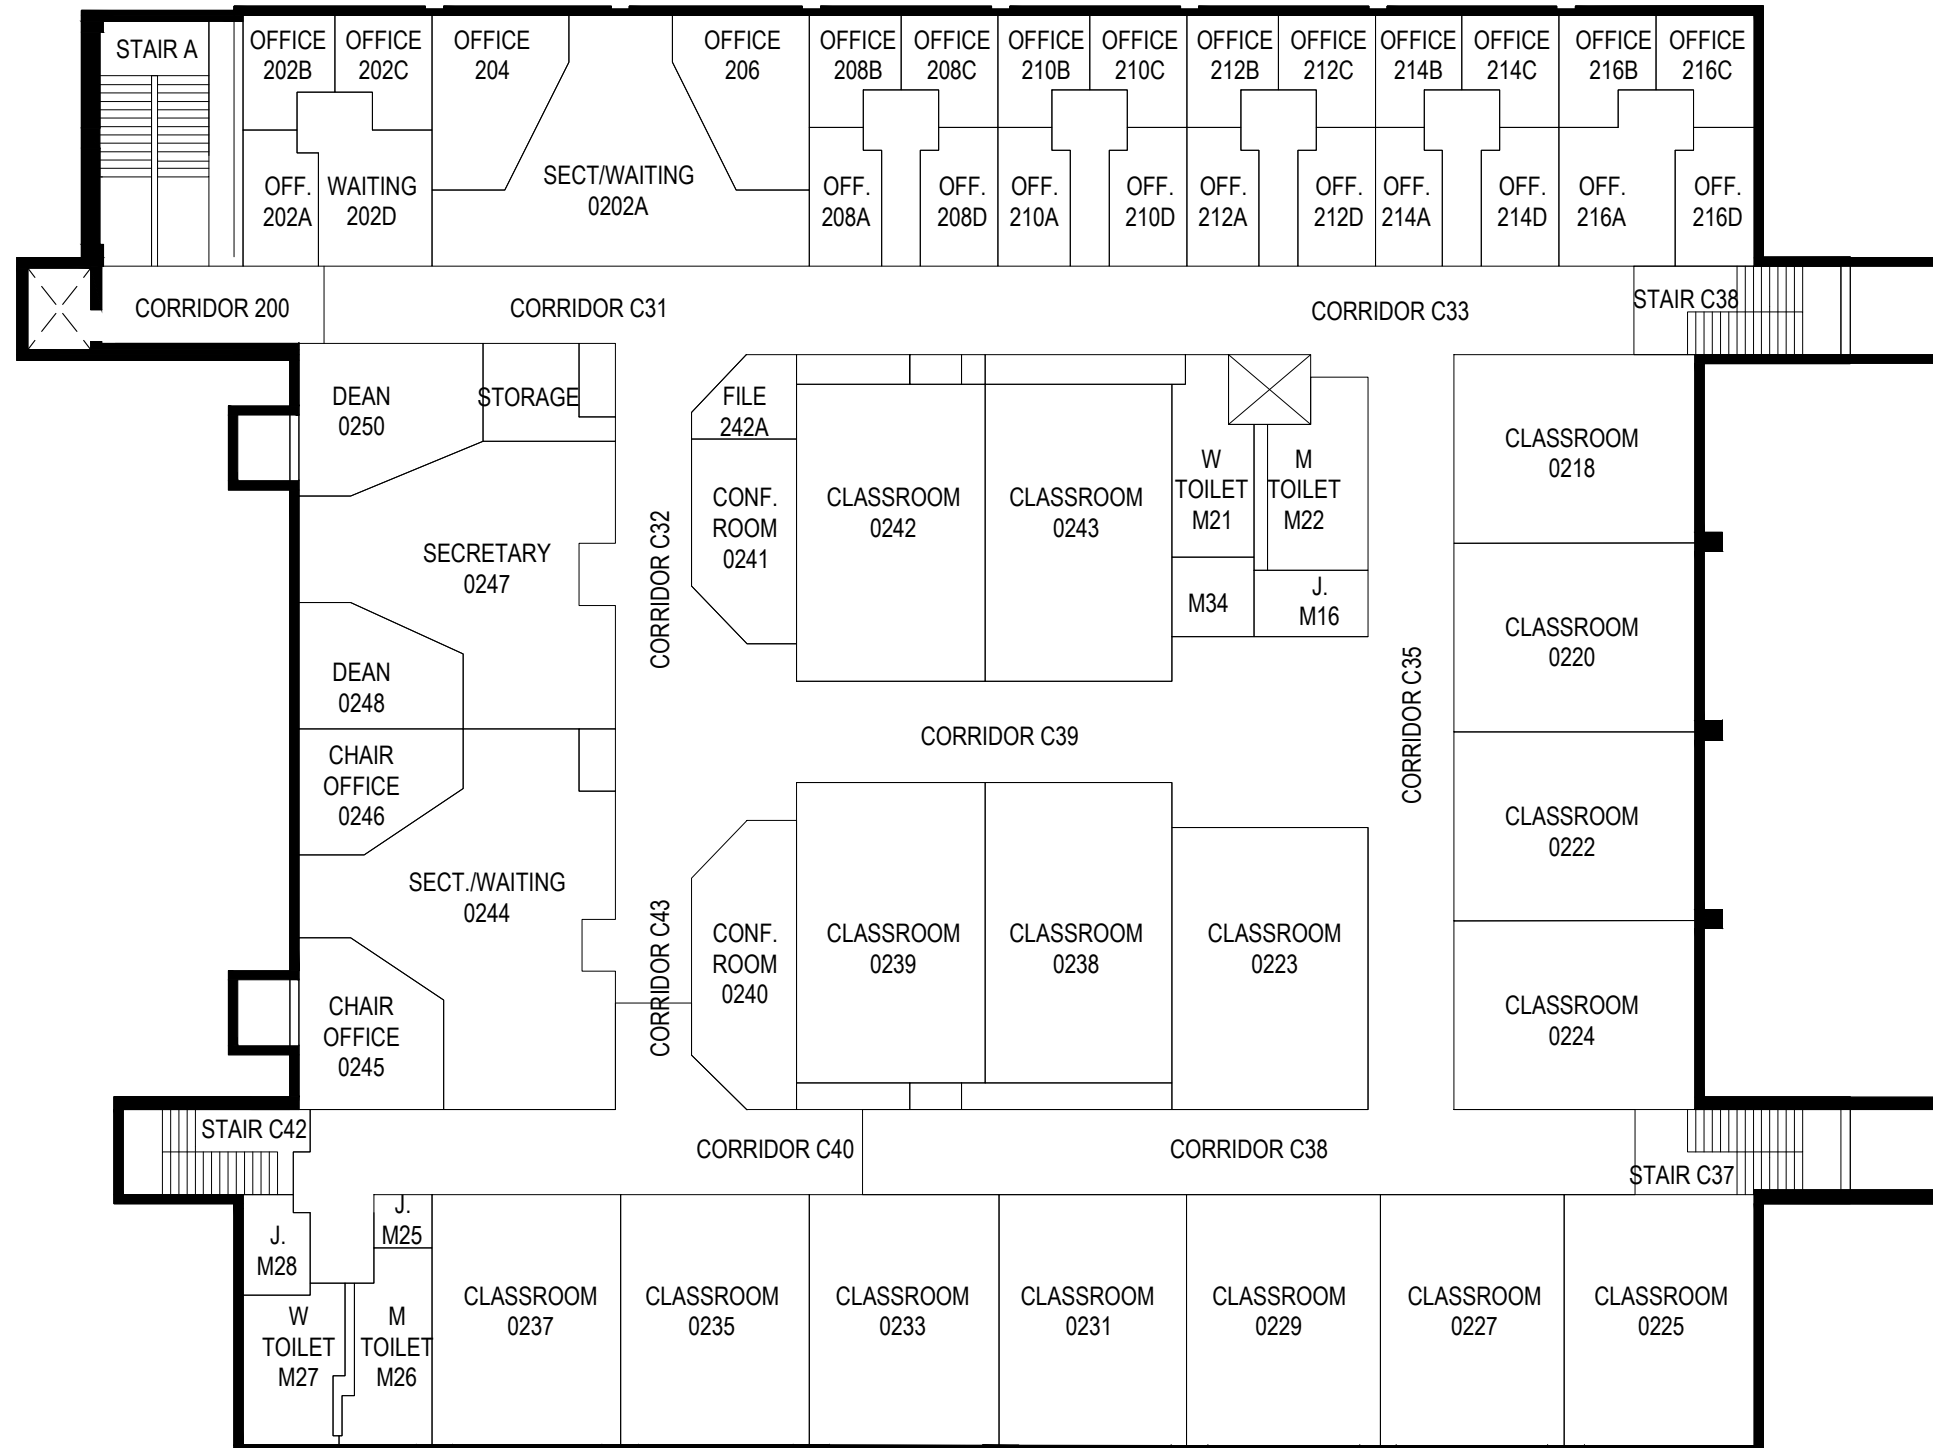

SECOND FLOOR PLAN



CLIENT

Farmingdale State College

SCALE:


1"=20'

DATE:

JUNE-2015

Gleeson - 007

H	2	architects + engineers
M	M	
Melville, NY Albany, NY New City, NY Parsippany, NJ		

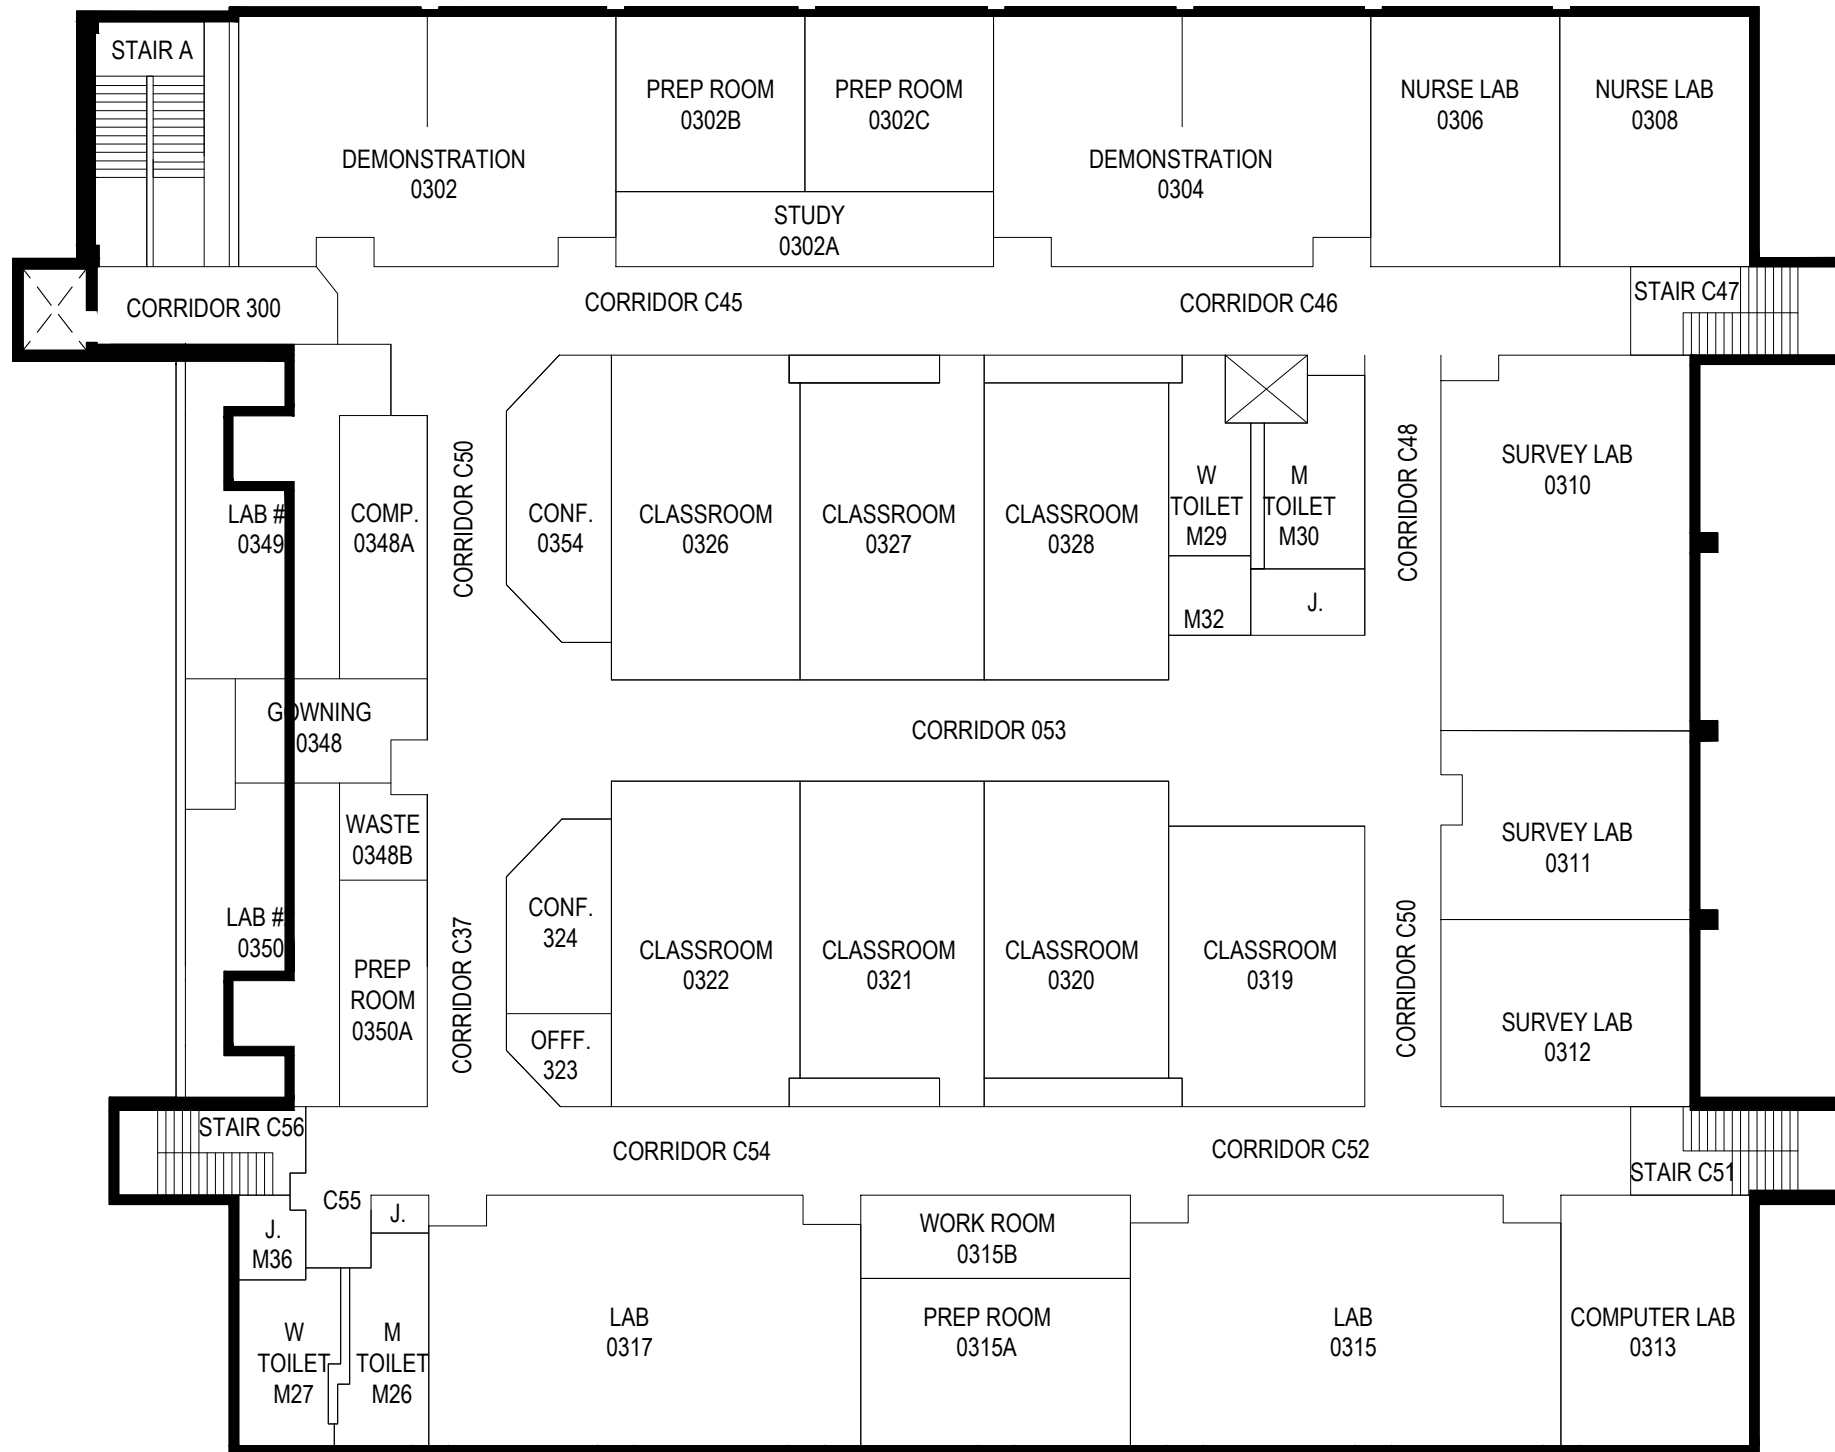

THIRD FLOOR PLAN



CLIENT

Farmingdale State College


SCALE:

1"=20'

DATE:


JUNE-2015

Gleeson - 007

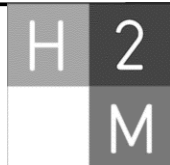

architects + engineers

Melville, NY Albany, NY
New City, NY Parsippany, NJ

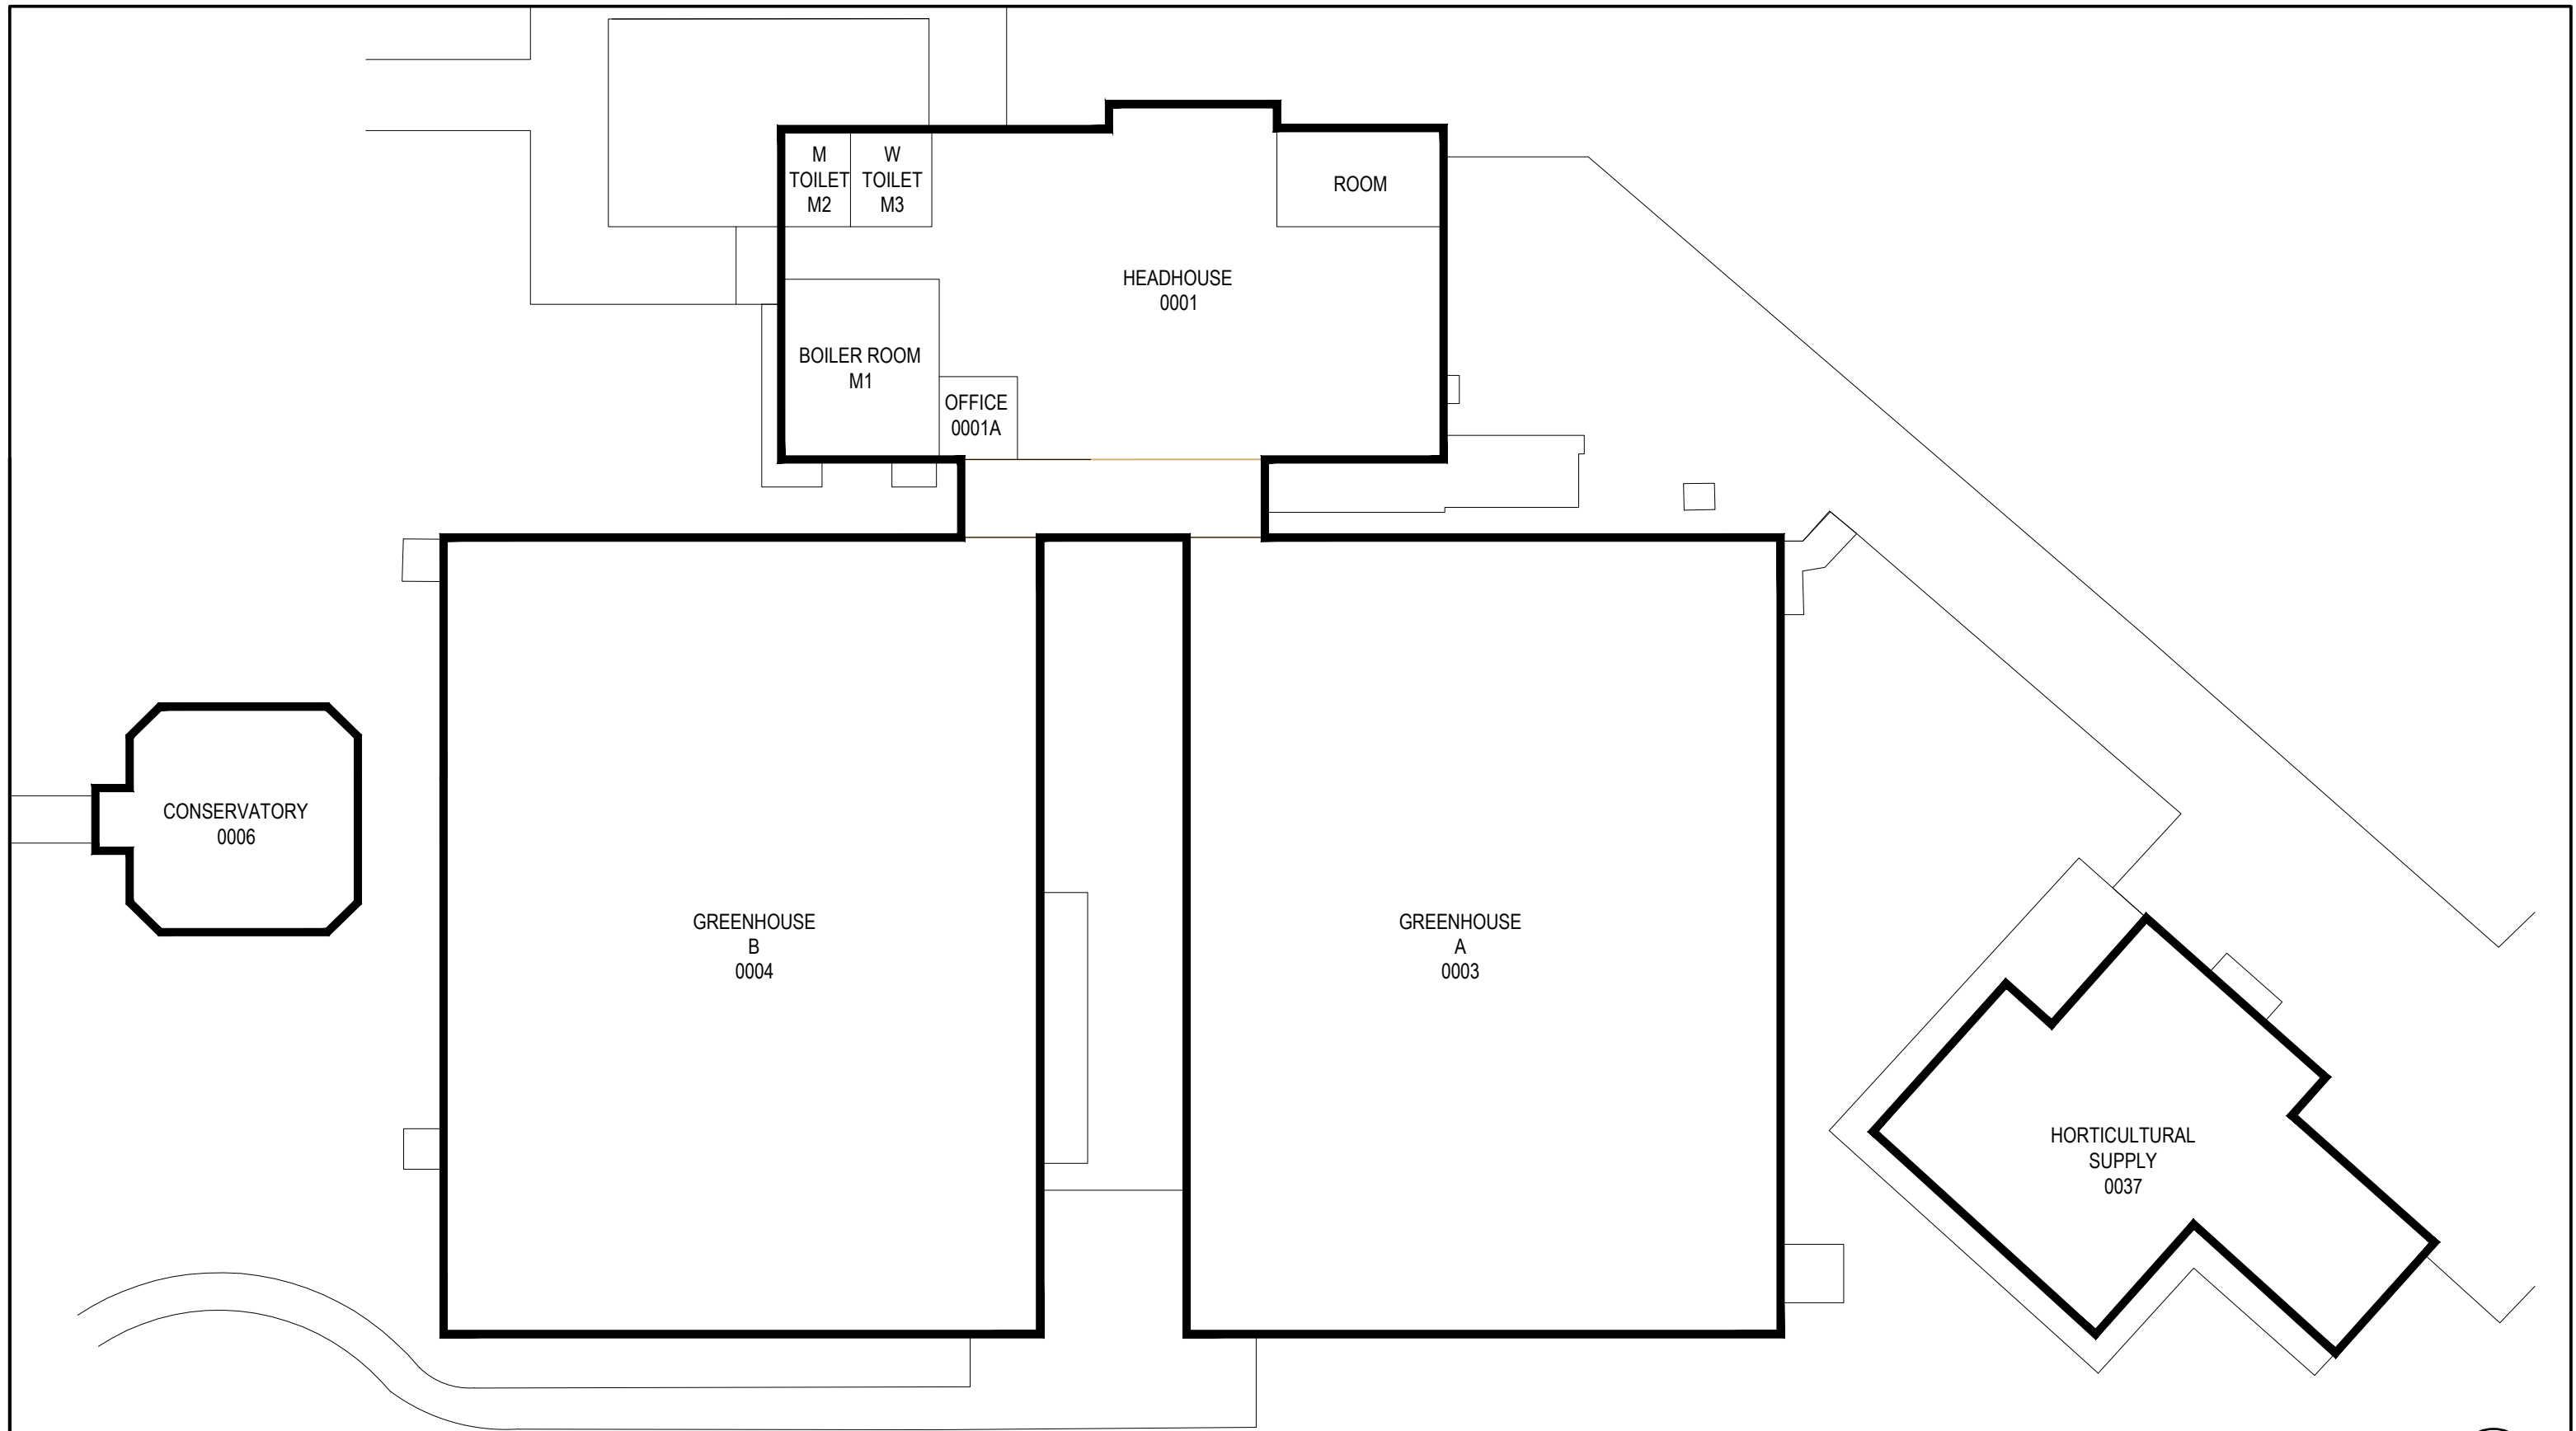

FIRST FLOOR PLAN



CLIENT

Farmingdale State College


SCALE:

1"=20'

DATE:


JUNE-2015

Greenhouse - 04

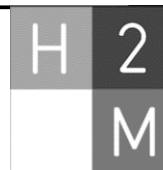

architects + engineers

Melville, NY Albany, NY
New City, NY Parsippany, NJ

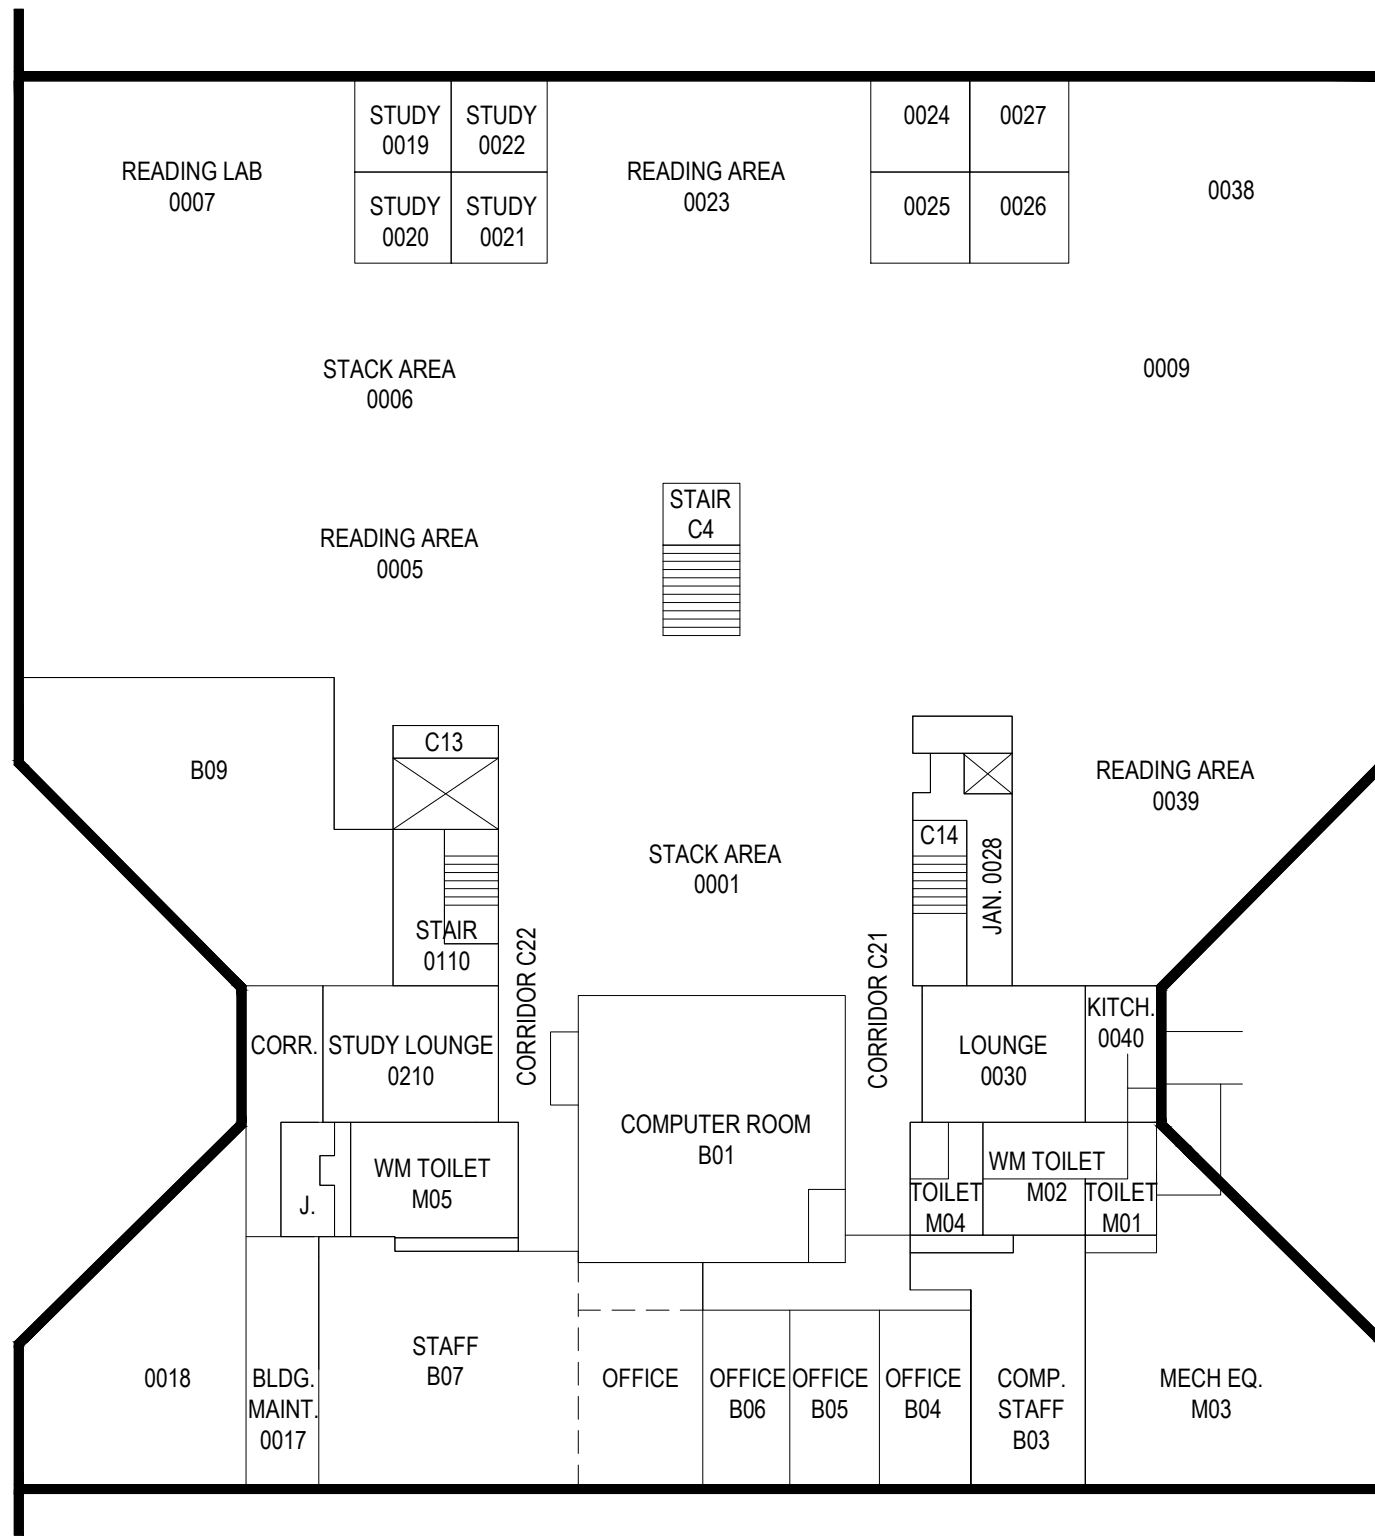

LOWER LEVEL FLOOR PLAN



CLIENT

Farmingdale State College

SCALE:

1"=20'

DATE:


JUNE-2015

Greenley - 18



architects + engineers

Melville, NY Albany, NY
New City, NY Parsippany, NJ

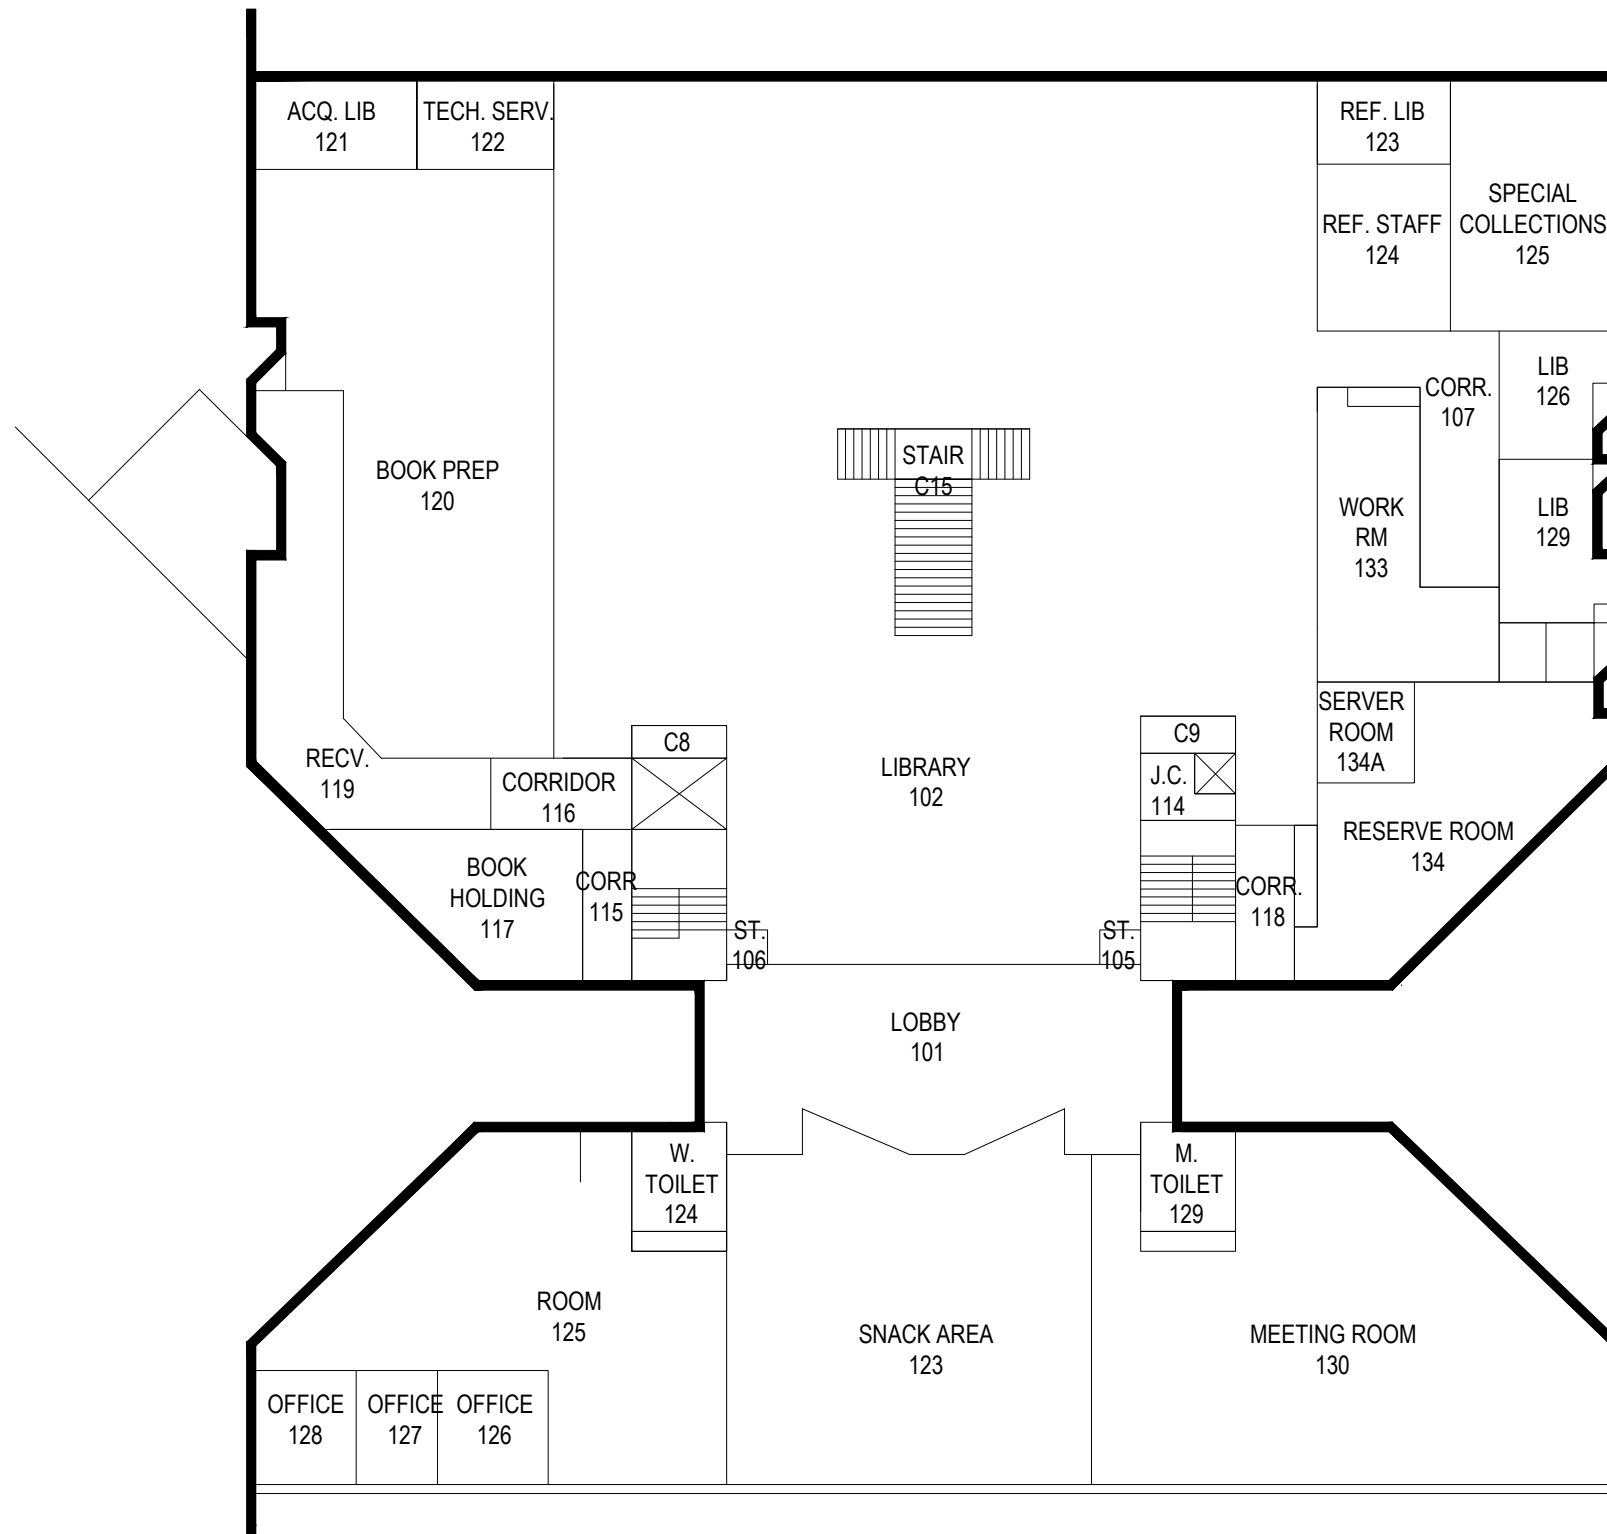

FIRST FLOOR PLAN



CLIENT

Farmingdale State College


SCALE:

1"=20'

DATE:


JUNE-2015

Greenley - 18

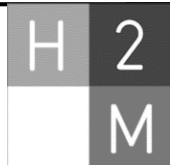

architects + engineers

Melville, NY Albany, NY
New City, NY Parsippany, NJ

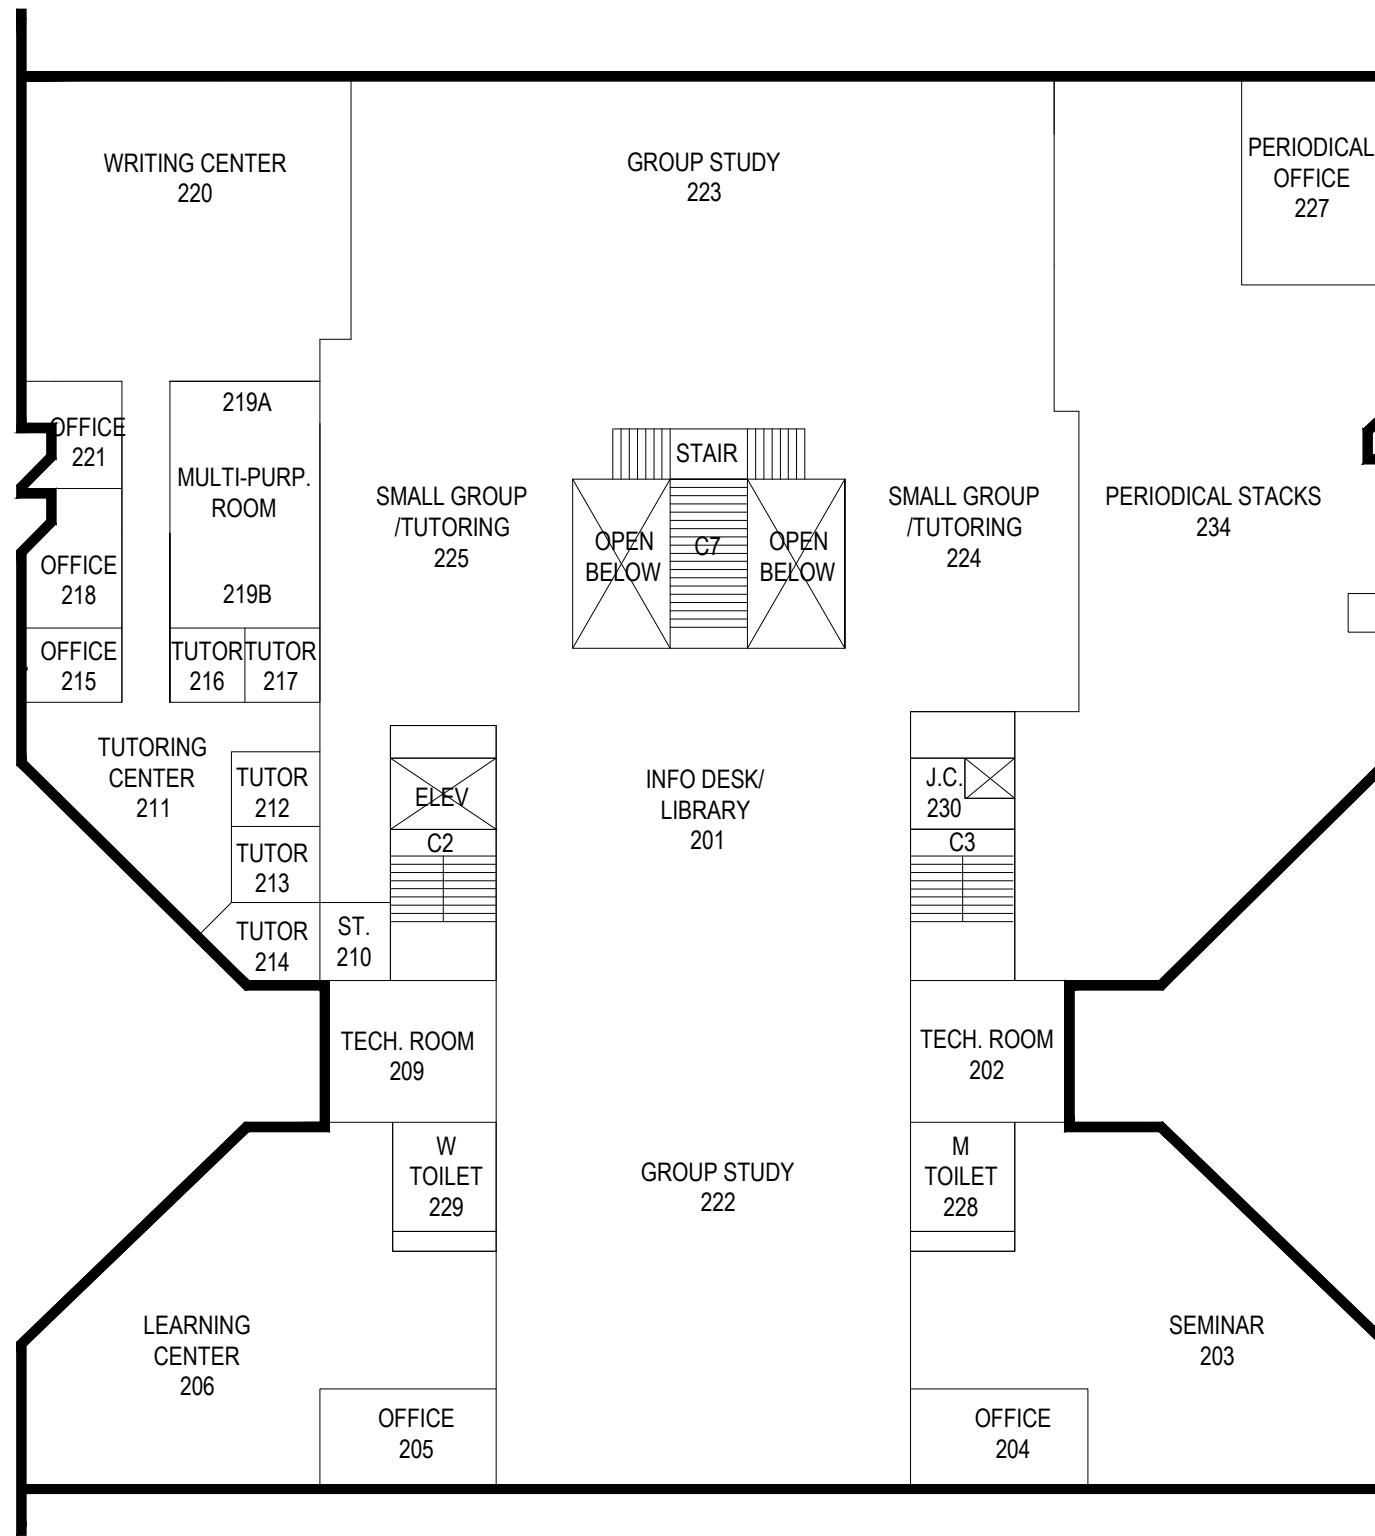

SECOND FLOOR PLAN



CLIENT

Farmingdale State College

SCALE:

1"=20'

DATE:


JUNE-2015

Greenley - 18



architects + engineers

Melville, NY Albany, NY
New City, NY Parsippany, NJ

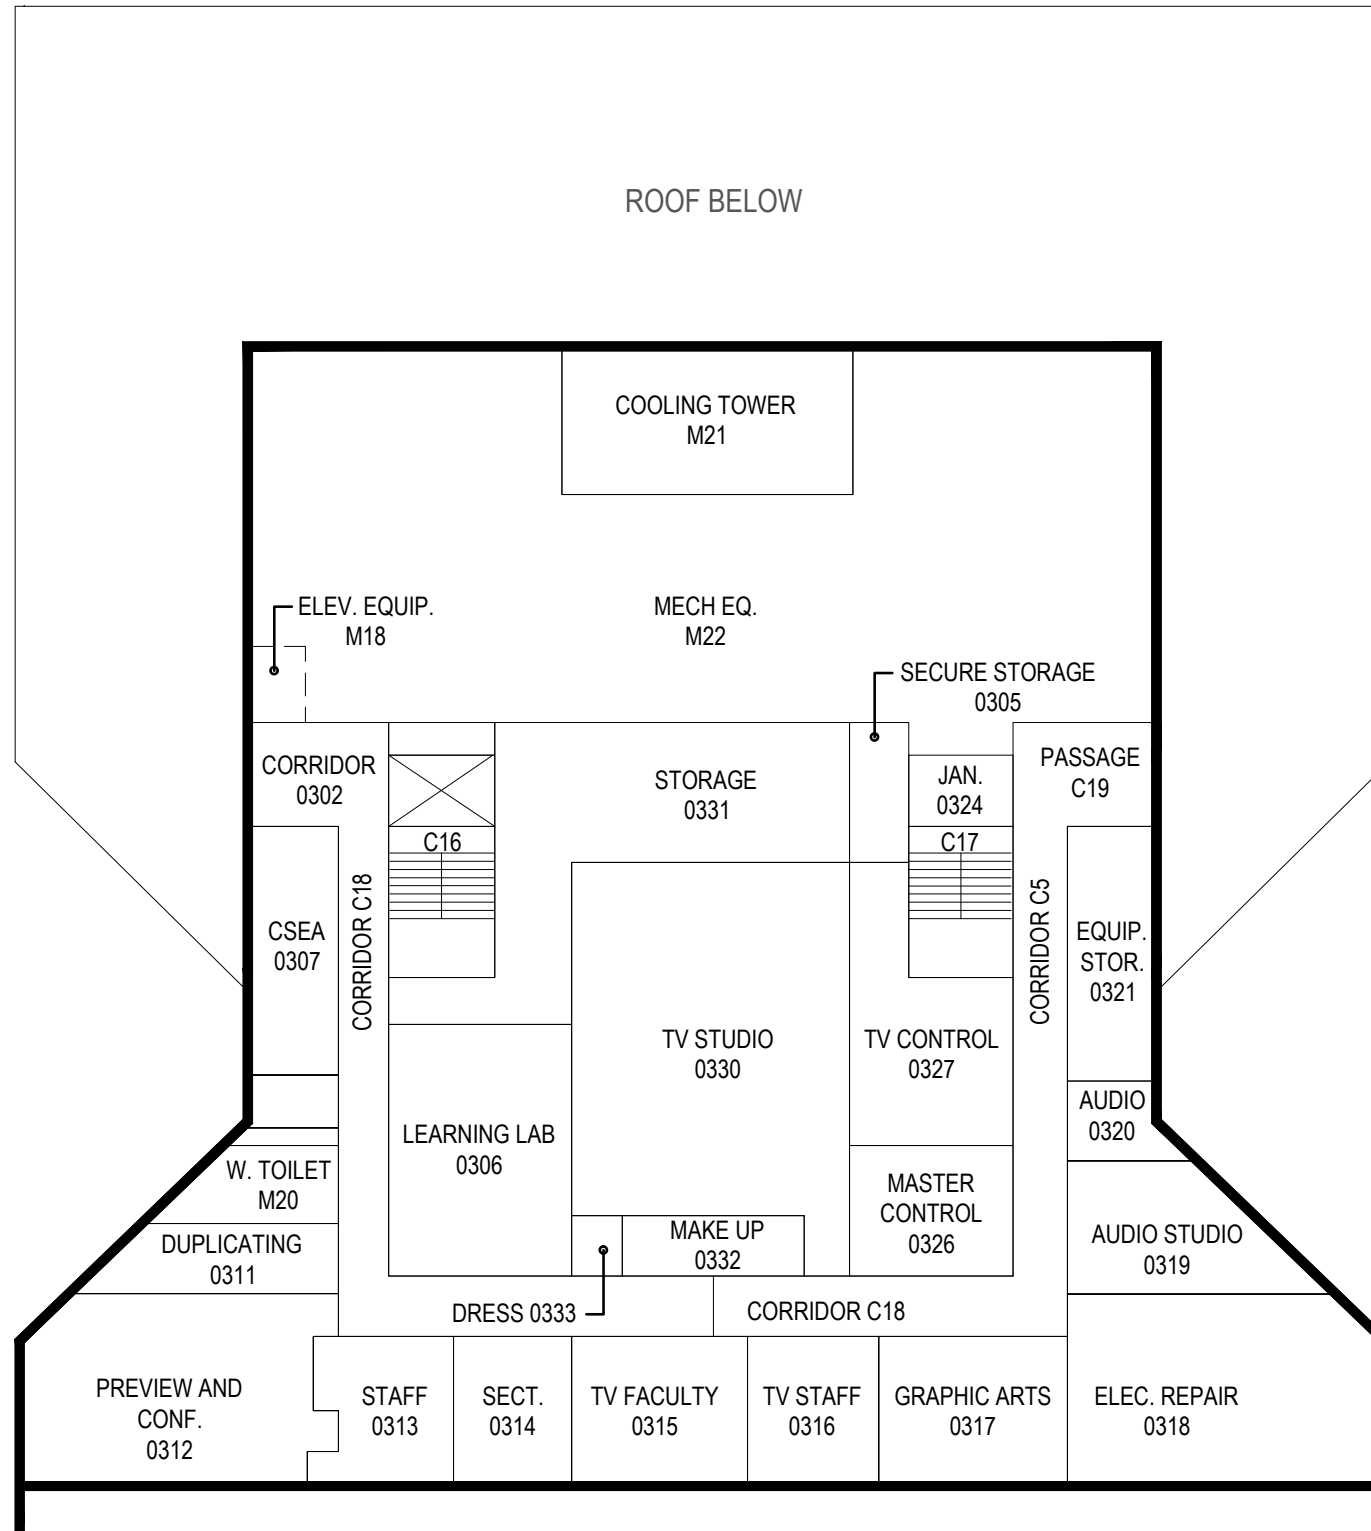

THIRD FLOOR PLAN

CLIENT

Farmingdale State College


SCALE:

1"=20'

DATE:

JUNE-2015



Greenley - 18

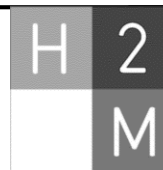

architects + engineers

Melville, NY Albany, NY
New City, NY Parsippany, NJ



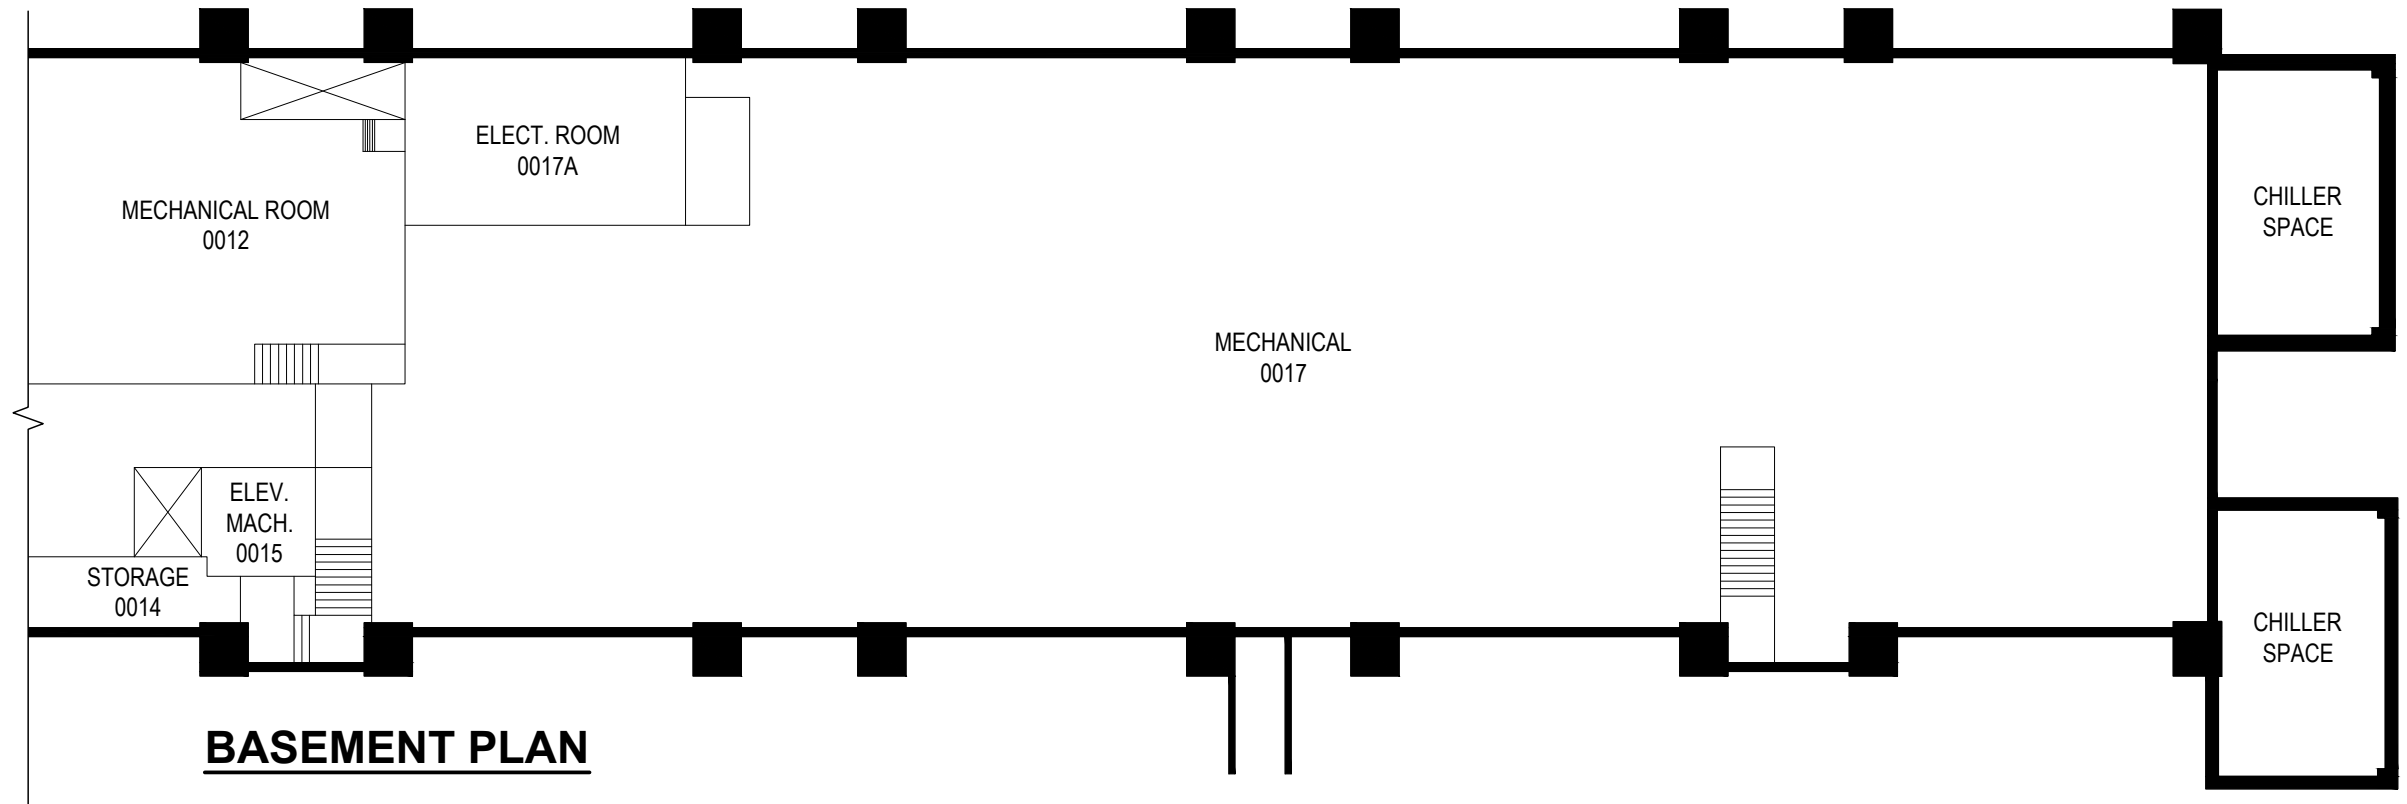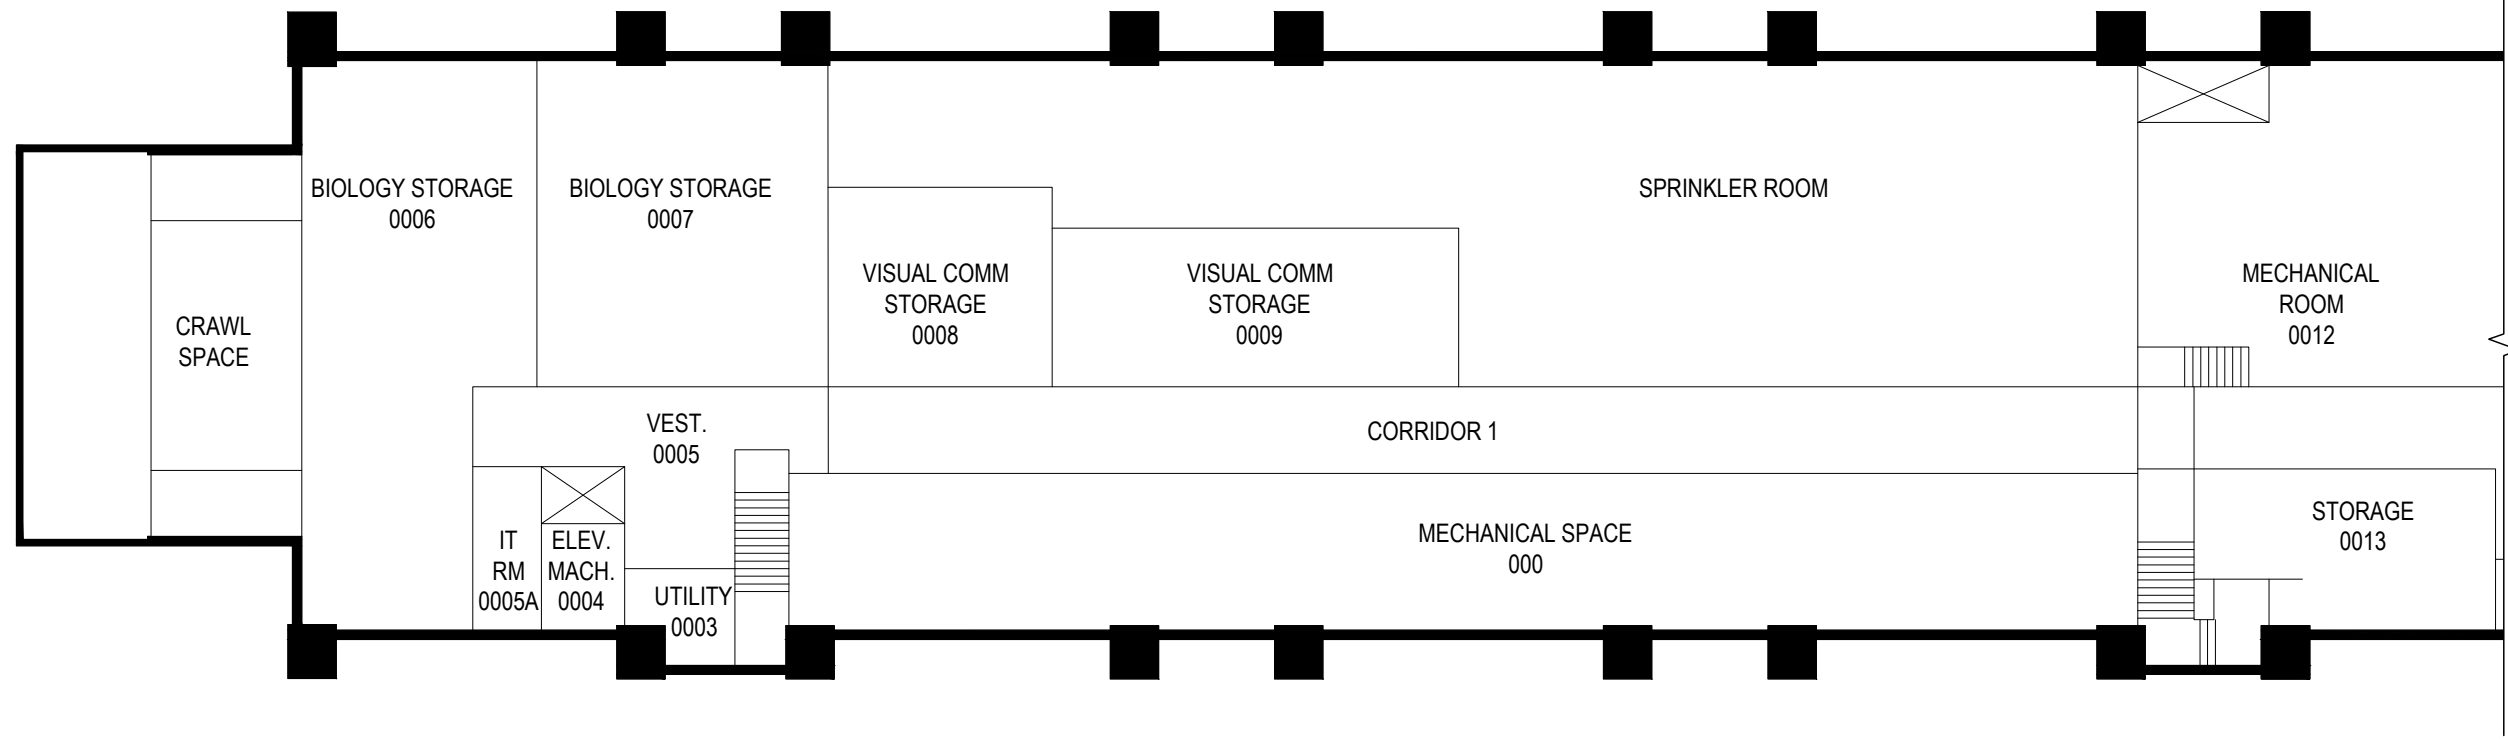

BASEMENT PLAN





CLIENT
Farmingdale State College

SCALE:
1"=20'
DATE:
JUNE-2015

Hale Hall - 014

H 2 M
architects + engineers
Melville, NY Albany, NY
New City, NY Parsippany, NJ

22

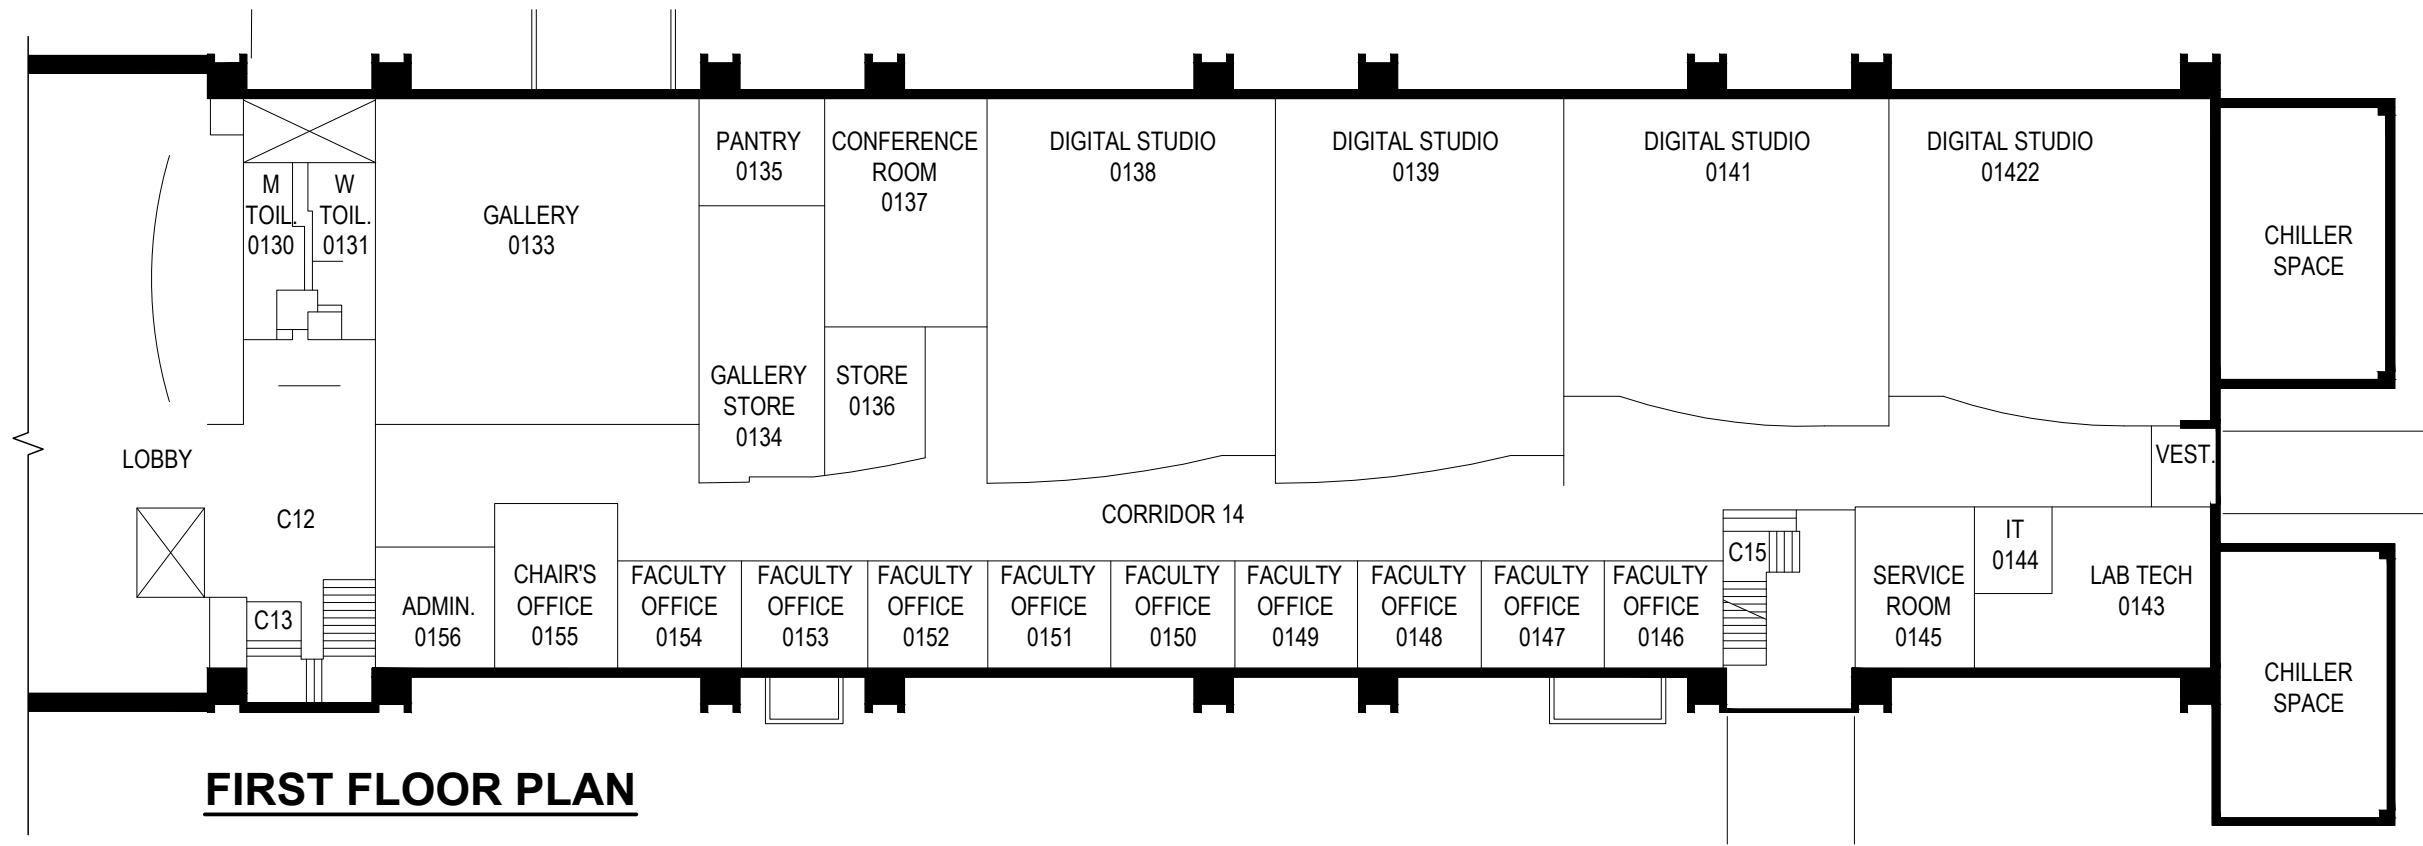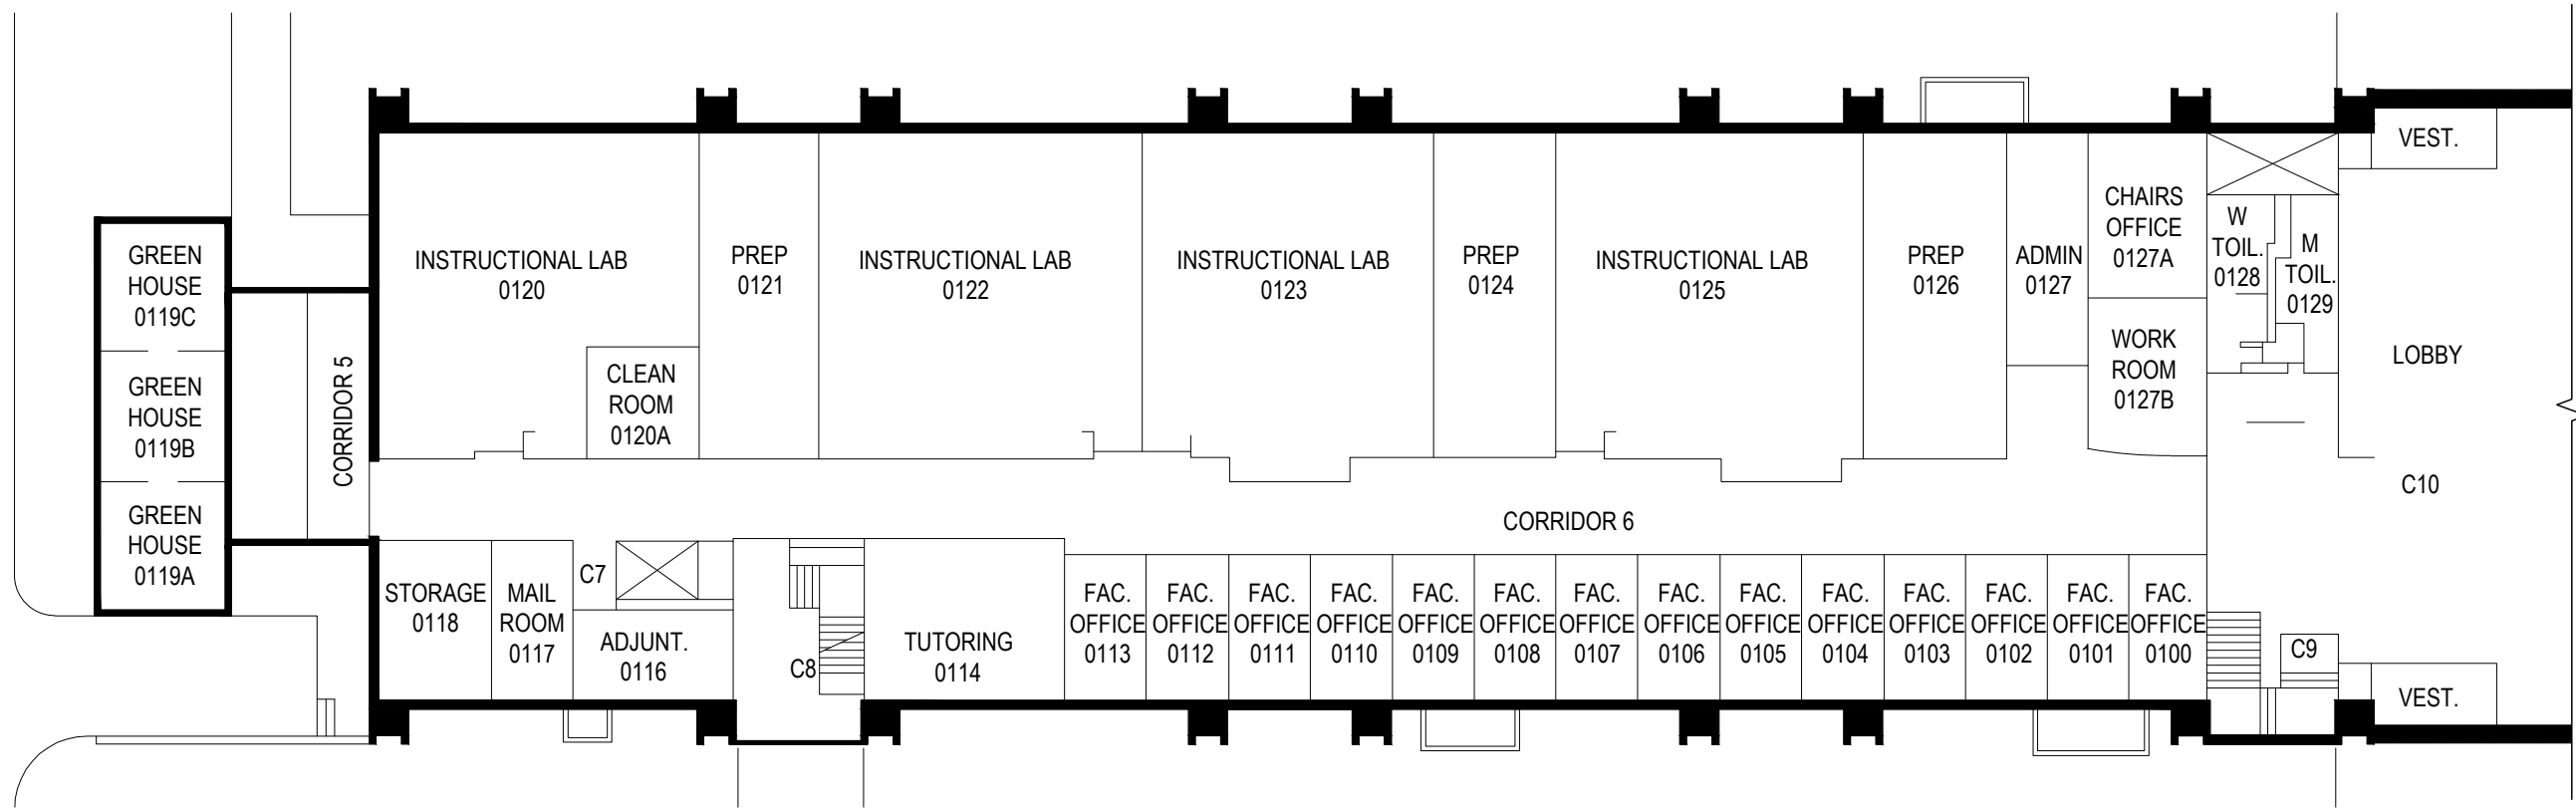

FIRST FLOOR PLAN





CLIENT
Farmingdale State College

SCALE:
1"=20'
 DATE:
JUNE-2015

Hale Hall - 014

H 2 M
 architects + engineers
 Melville, NY Albany, NY
 New City, NY Parsippany, NJ

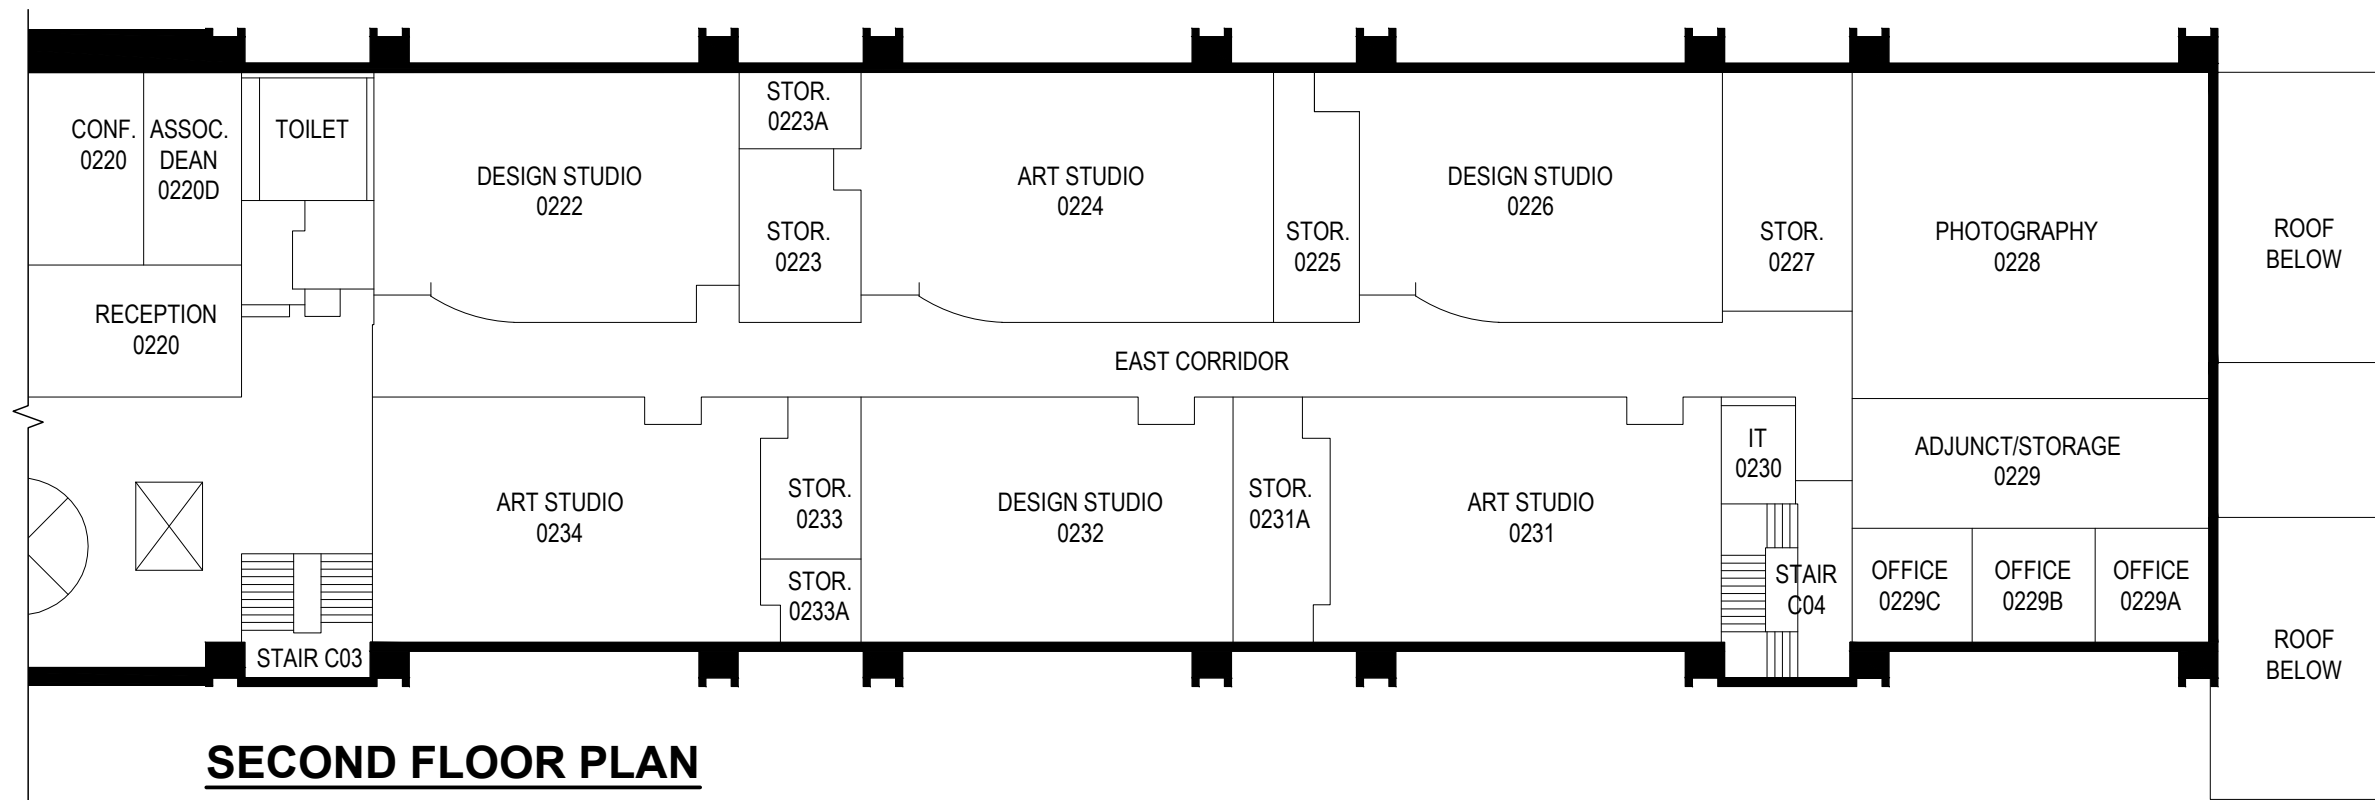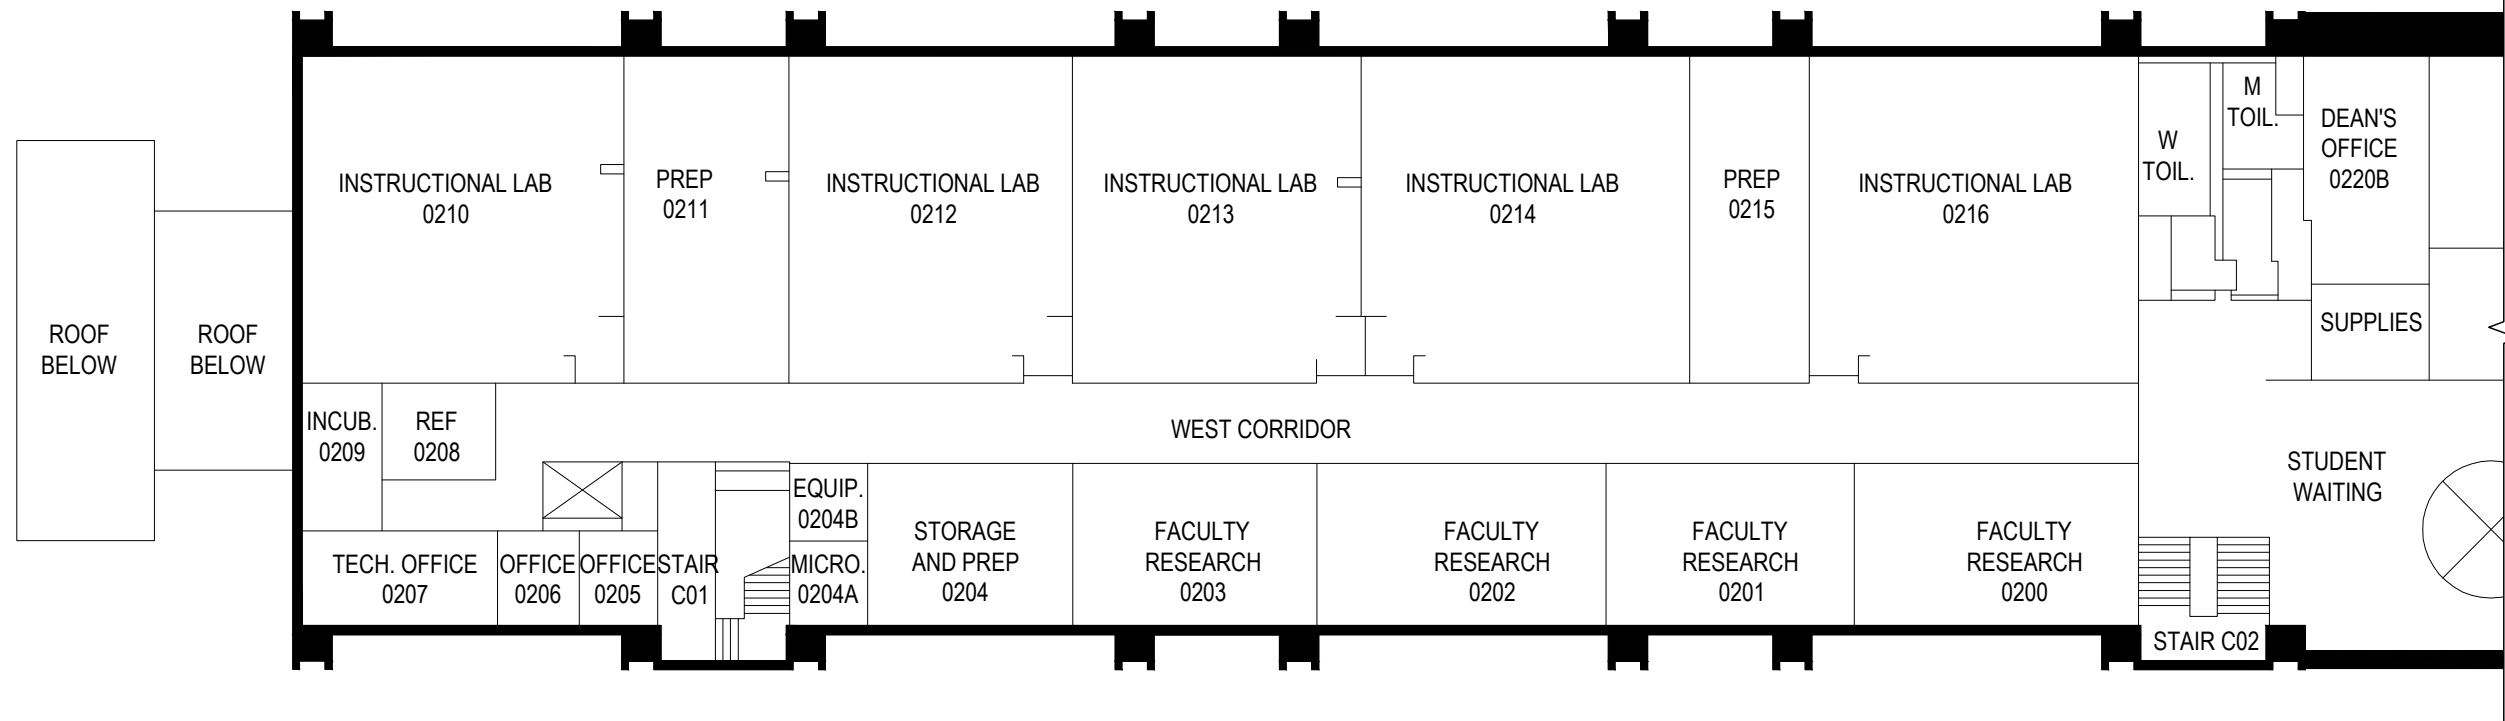

SECOND FLOOR PLAN



CLIENT

Farmingdale State College

SCALE:

1"=20'

DATE:


JUNE-2015

Hale Hall - 014



architects + engineers

Melville, NY Albany, NY
New City, NY Parsippany, NJ

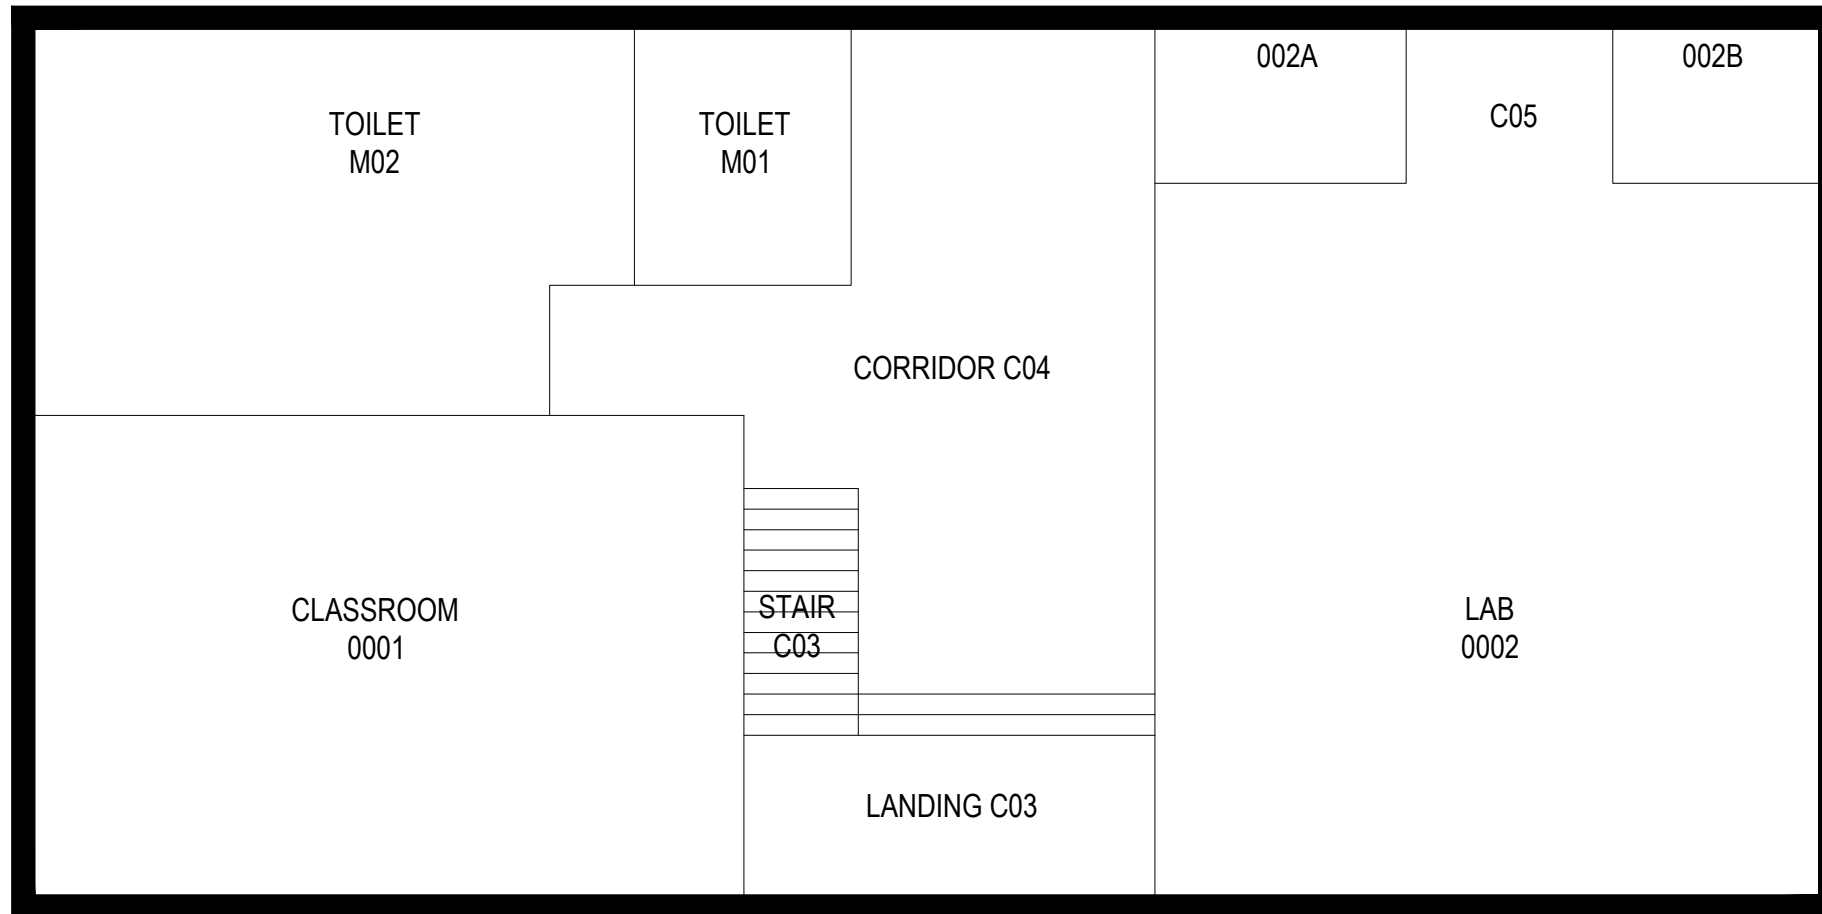

BASEMENT FLOOR PLAN



CLIENT

Farmingdale State College

SCALE:

1/8"=1'-0"

DATE:


JUNE-2015

Hick's Hall - 005



architects + engineers

Melville, NY Albany, NY
New City, NY Parsippany, NJ

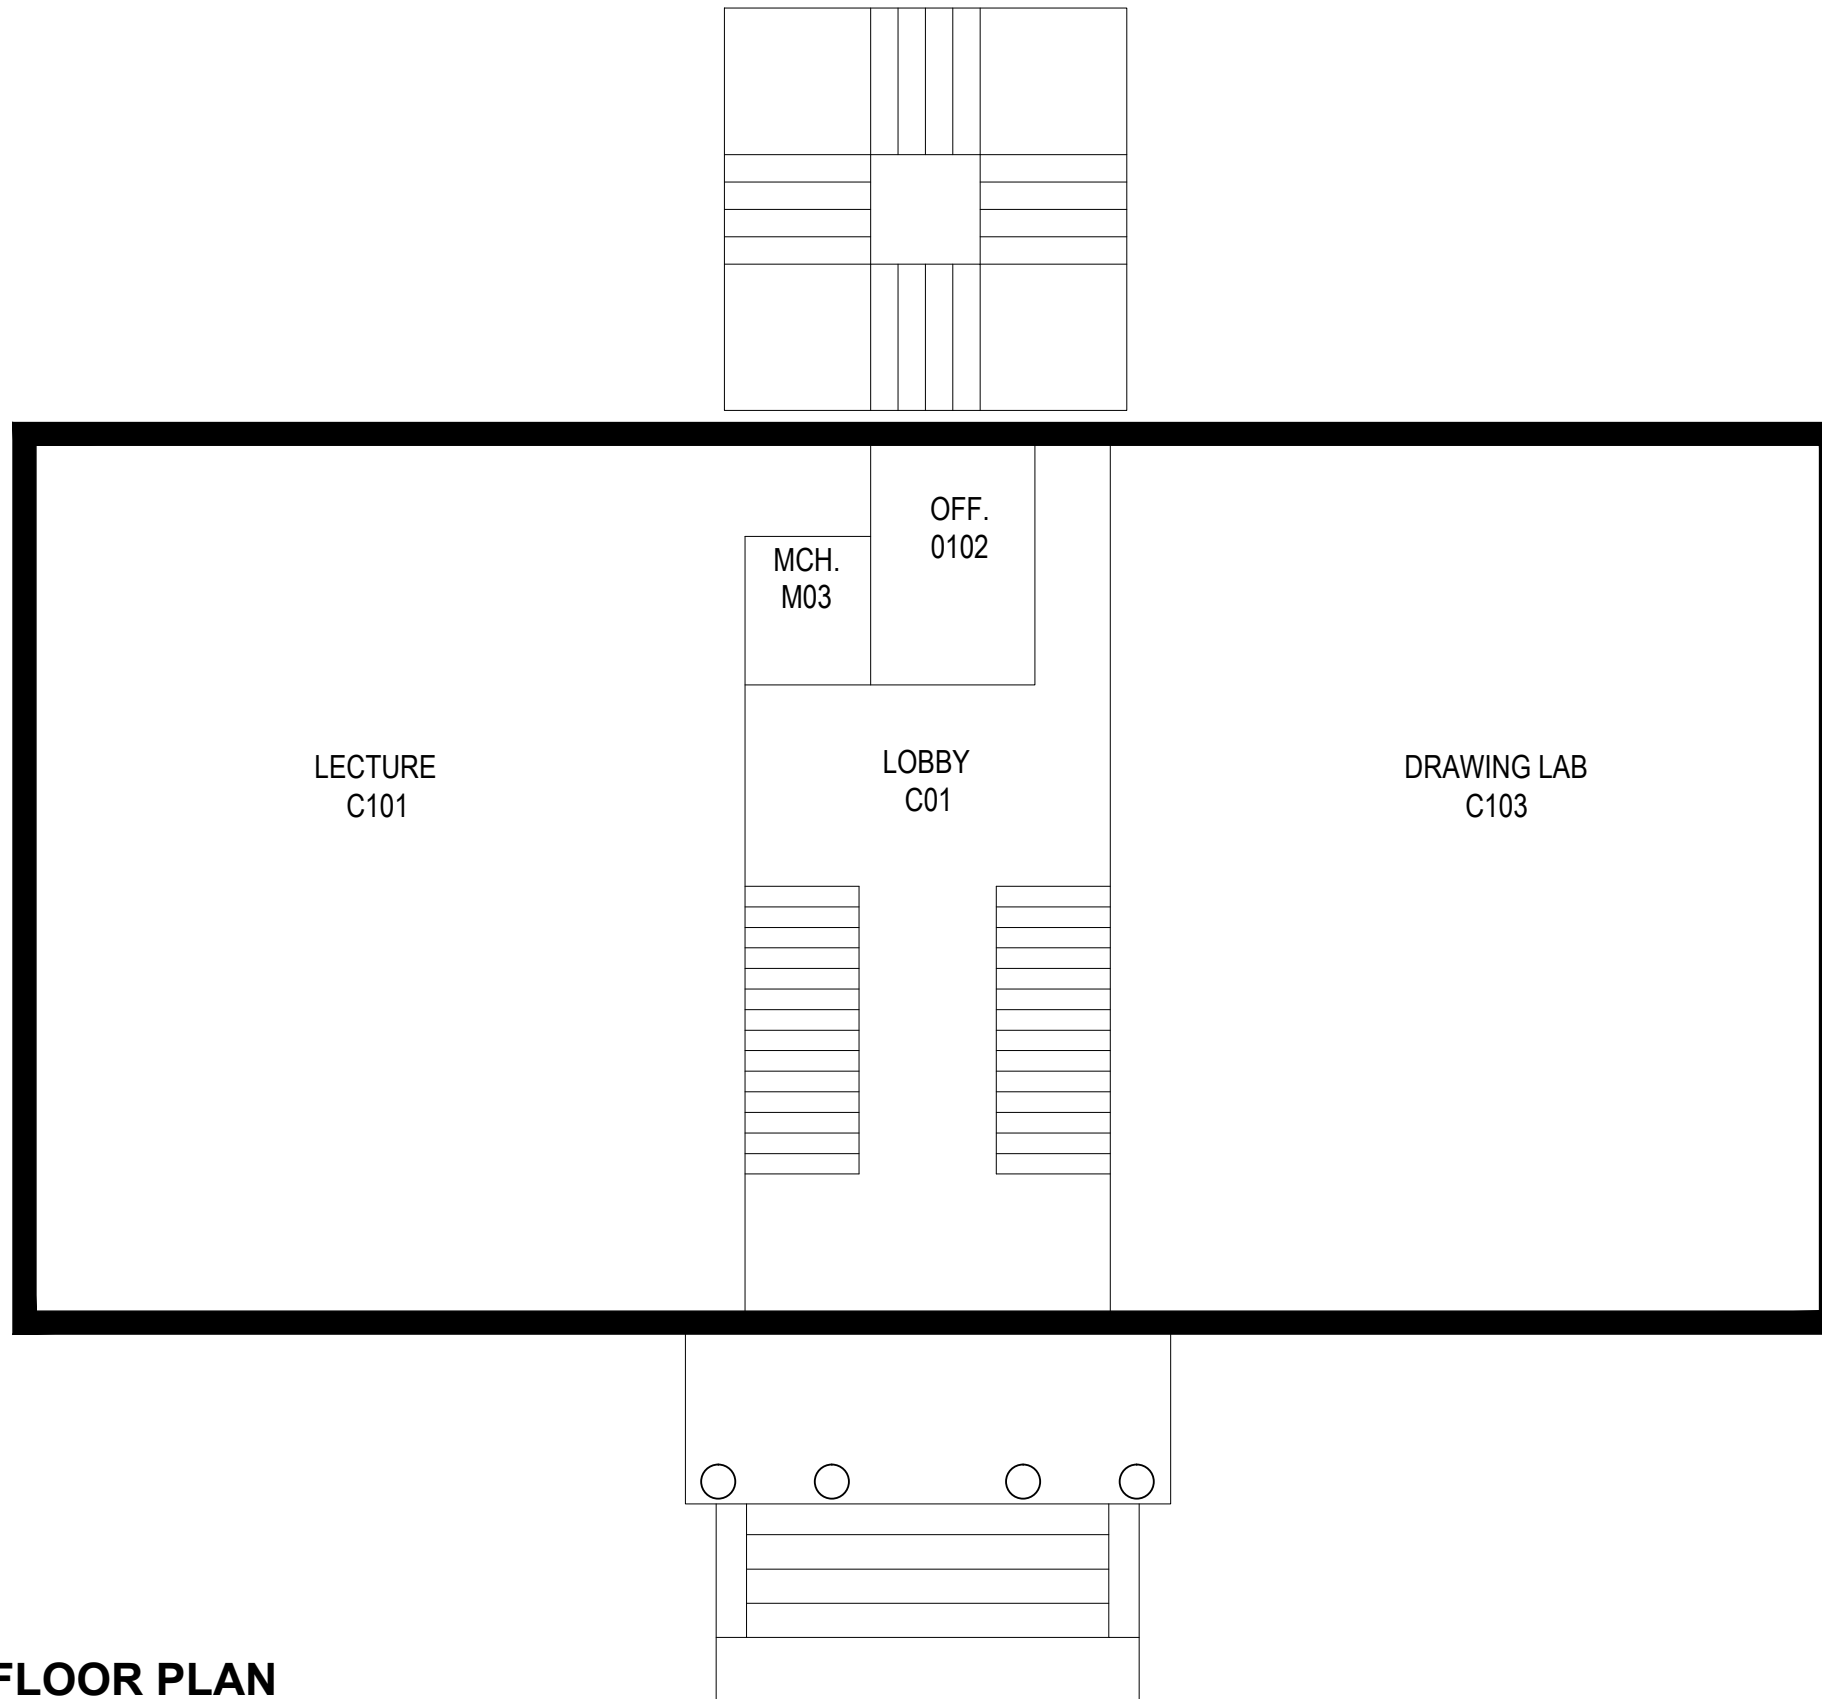

FIRST FLOOR PLAN



CLIENT

Farmingdale State College

SCALE:

1/8"=1'-0"

DATE:



JUNE-2015

Hick's Hall - 005



architects + engineers

Melville, NY Albany, NY
New City, NY Parsippany, NJ

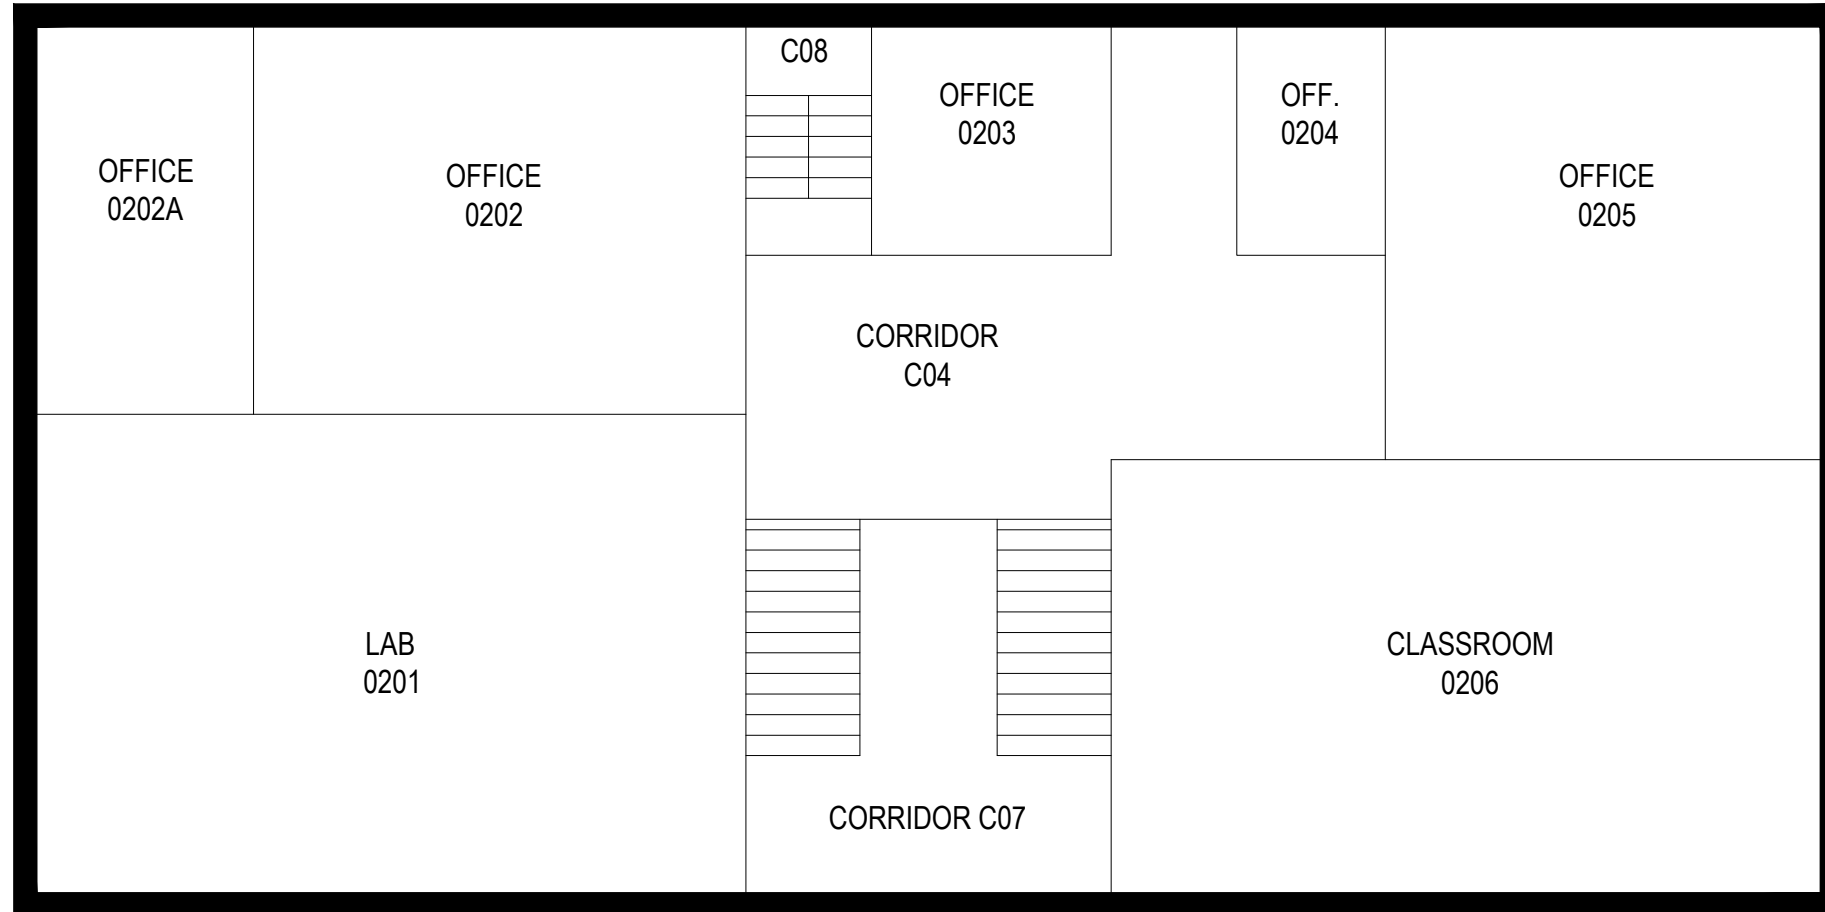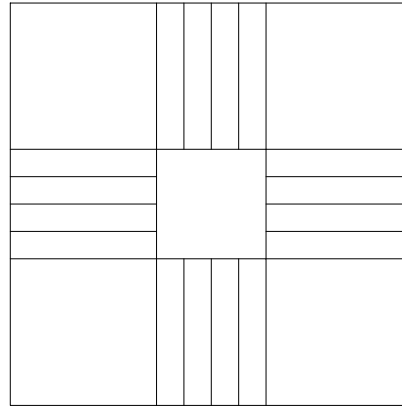

SECOND FLOOR PLAN



CLIENT

Farmingdale State College


SCALE:

1/8"=1'-0"

DATE:


JUNE-2015

Hick's Hall - 005

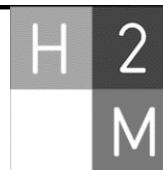

architects + engineers

 Melville, NY Albany, NY
New City, NY Parsippany, NJ



ATTIC
0300

THIRD FLOOR PLAN



CLIENT

Farmingdale State College


SCALE:

1/8"=1'-0"

DATE:


JUNE-2015

Hick's Hall - 005

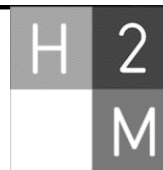

architects + engineers

Melville, NY Albany, NY
New City, NY Parsippany, NJ

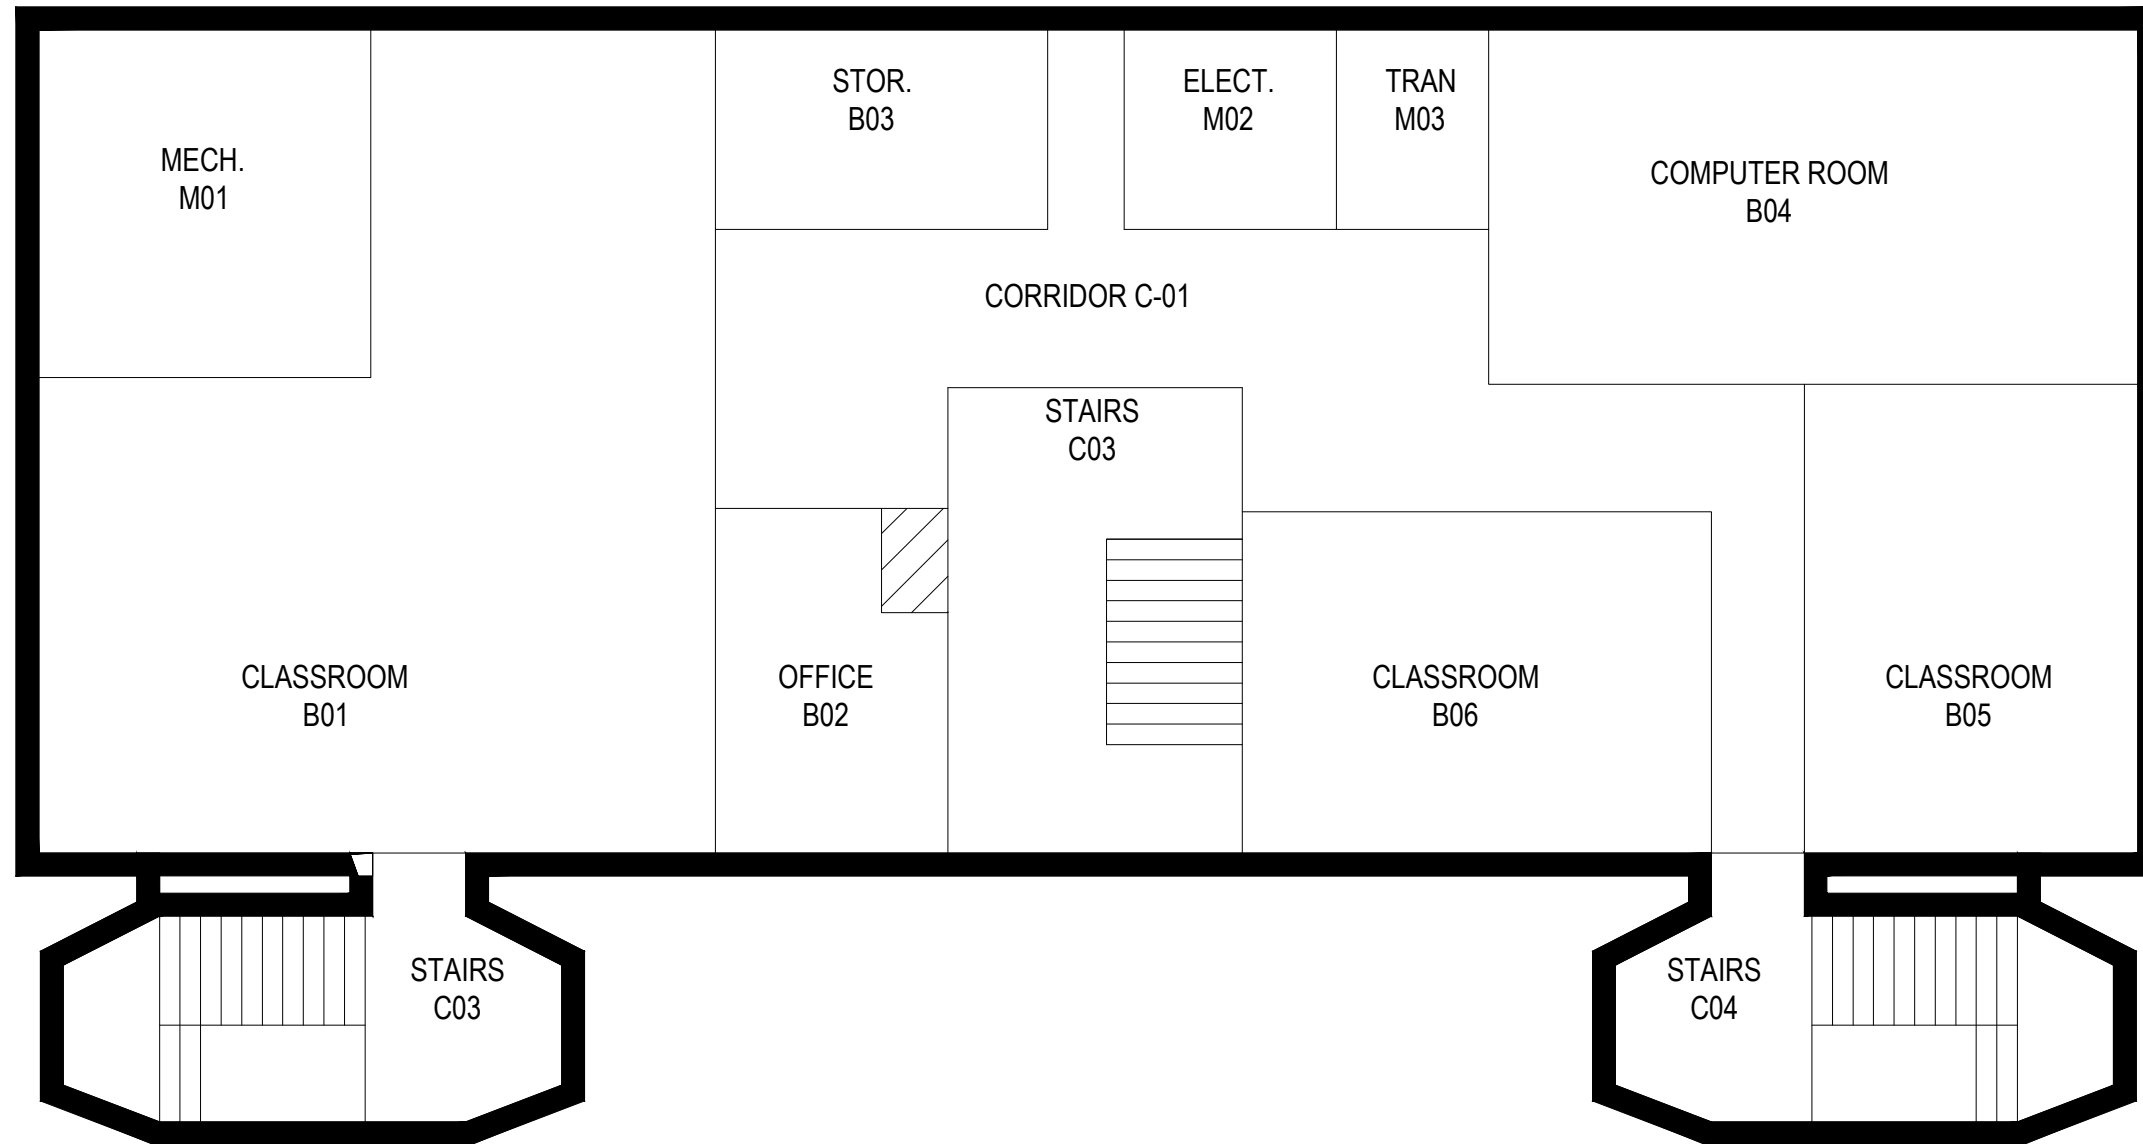

BASEMENT FLOOR PLAN



CLIENT

Farmingdale State College

SCALE:

1/8"=1'-0"

DATE:


JUNE-2015

Hooper Hall - 015



architects + engineers

Melville, NY Albany, NY
New City, NY Parsippany, NJ

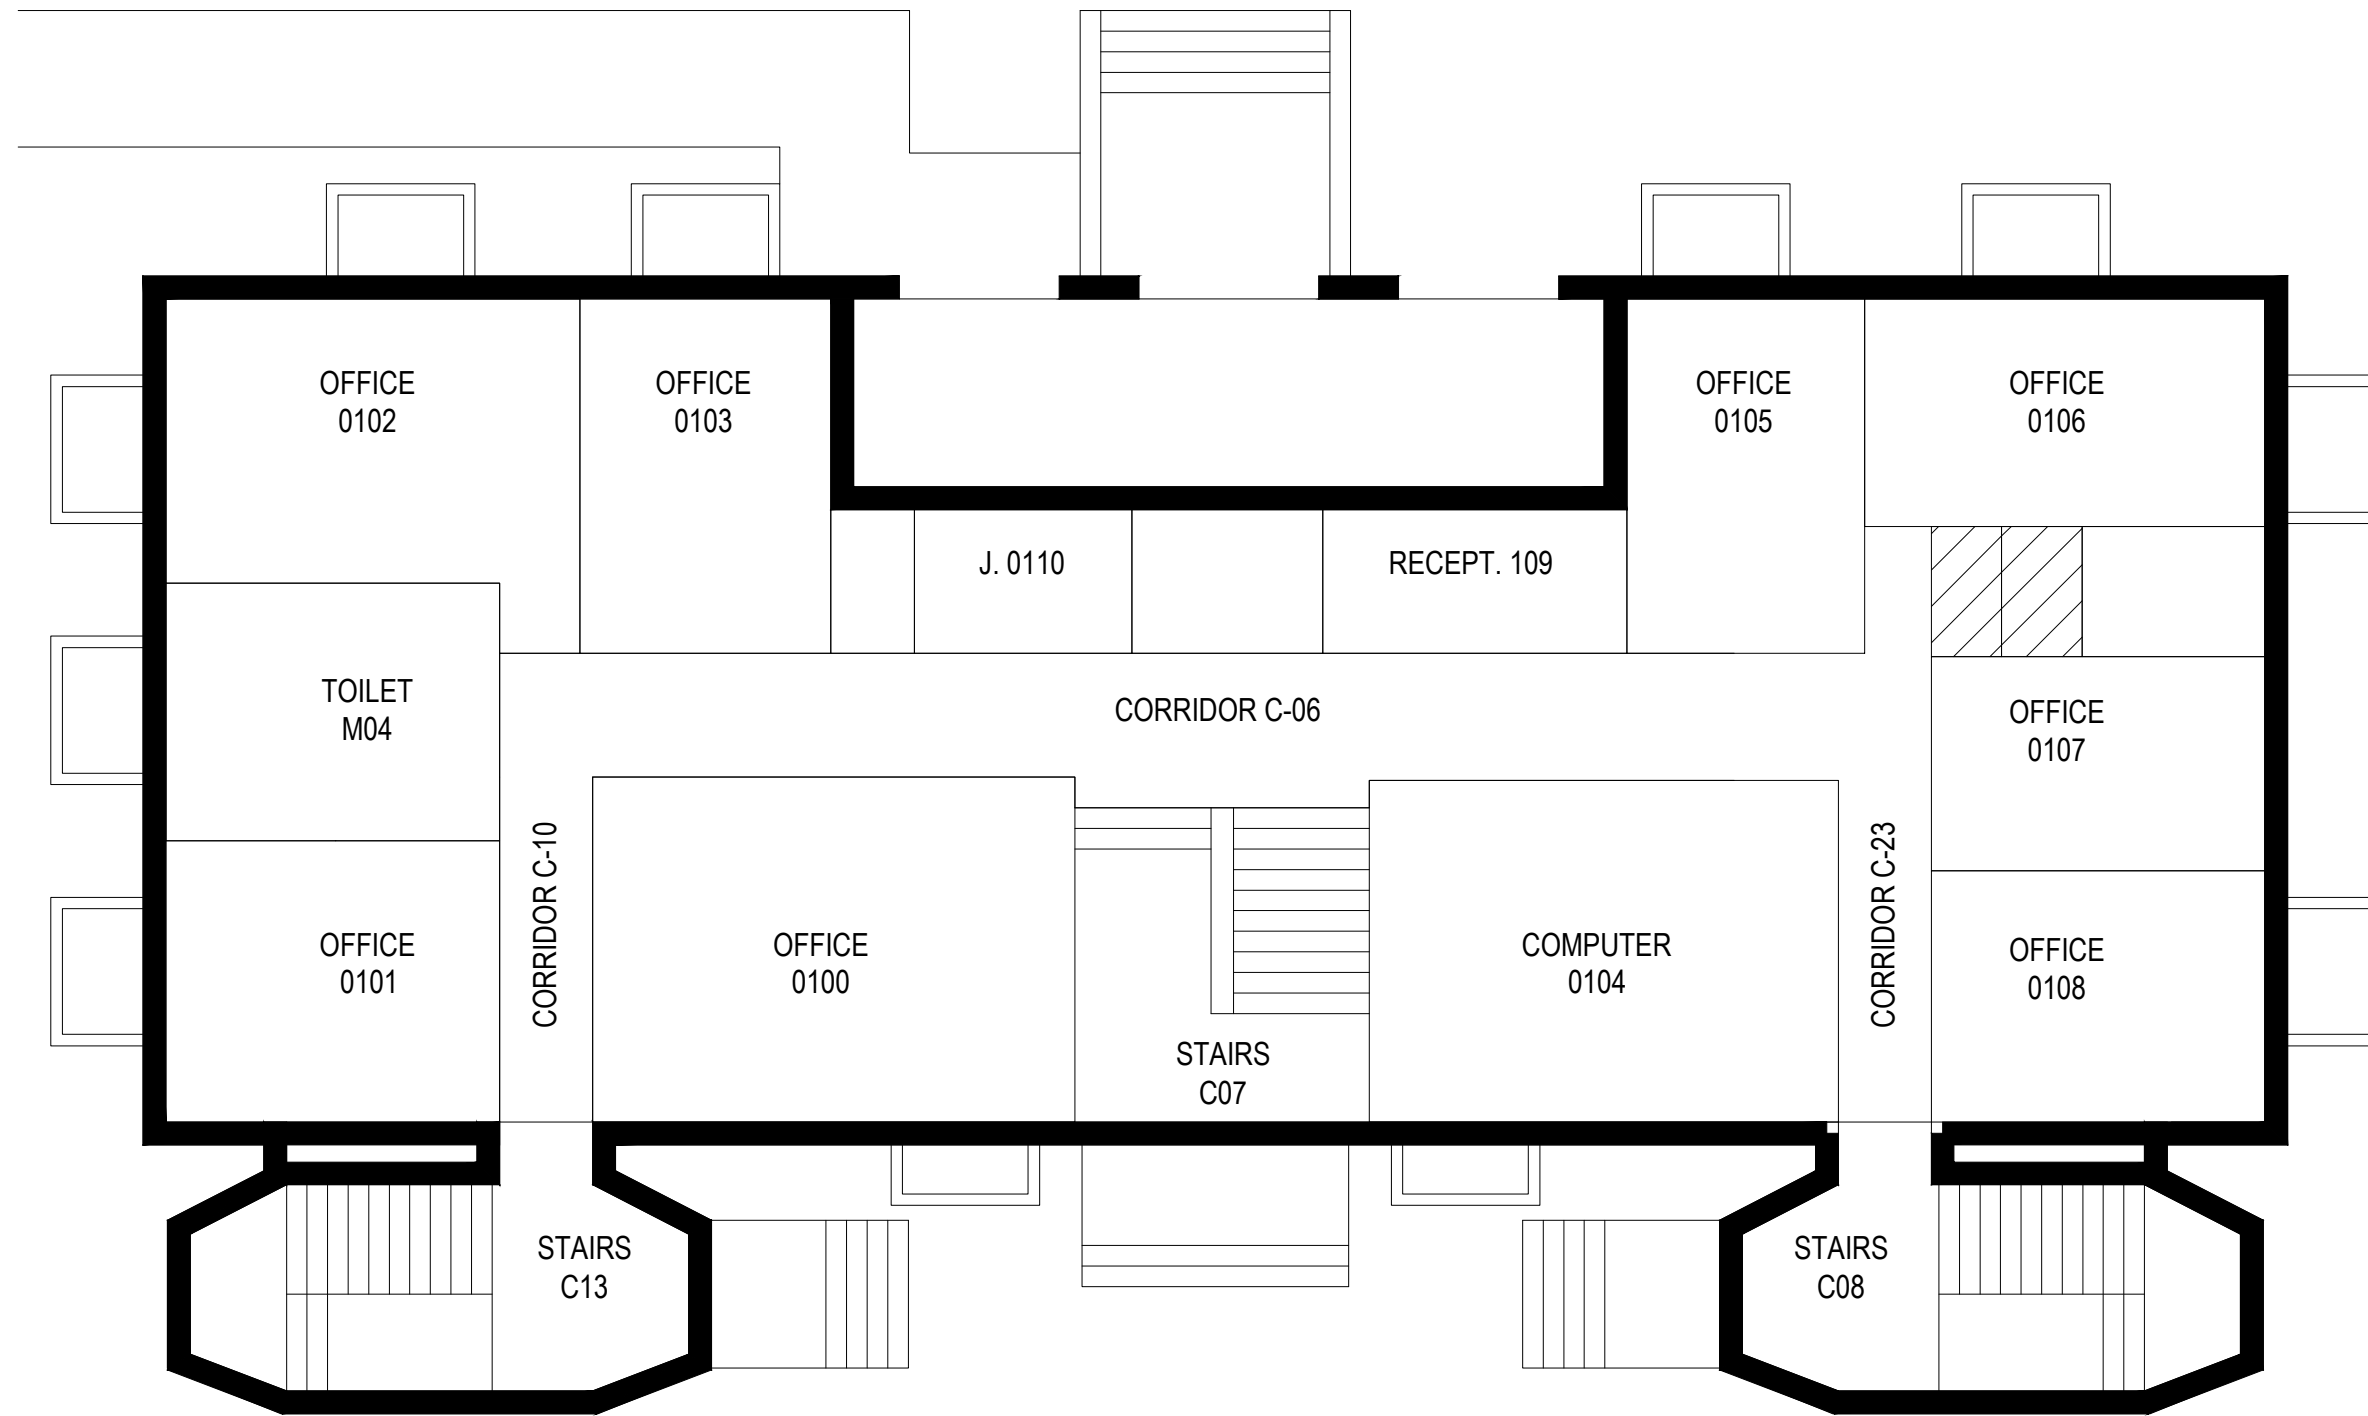

FIRST FLOOR PLAN



CLIENT

Farmingdale State College

SCALE:

1/8"=1'-0"

DATE:


JUNE-2015

Hooper Hall - 015



architects + engineers

Melville, NY Albany, NY
New City, NY Parsippany, NJ

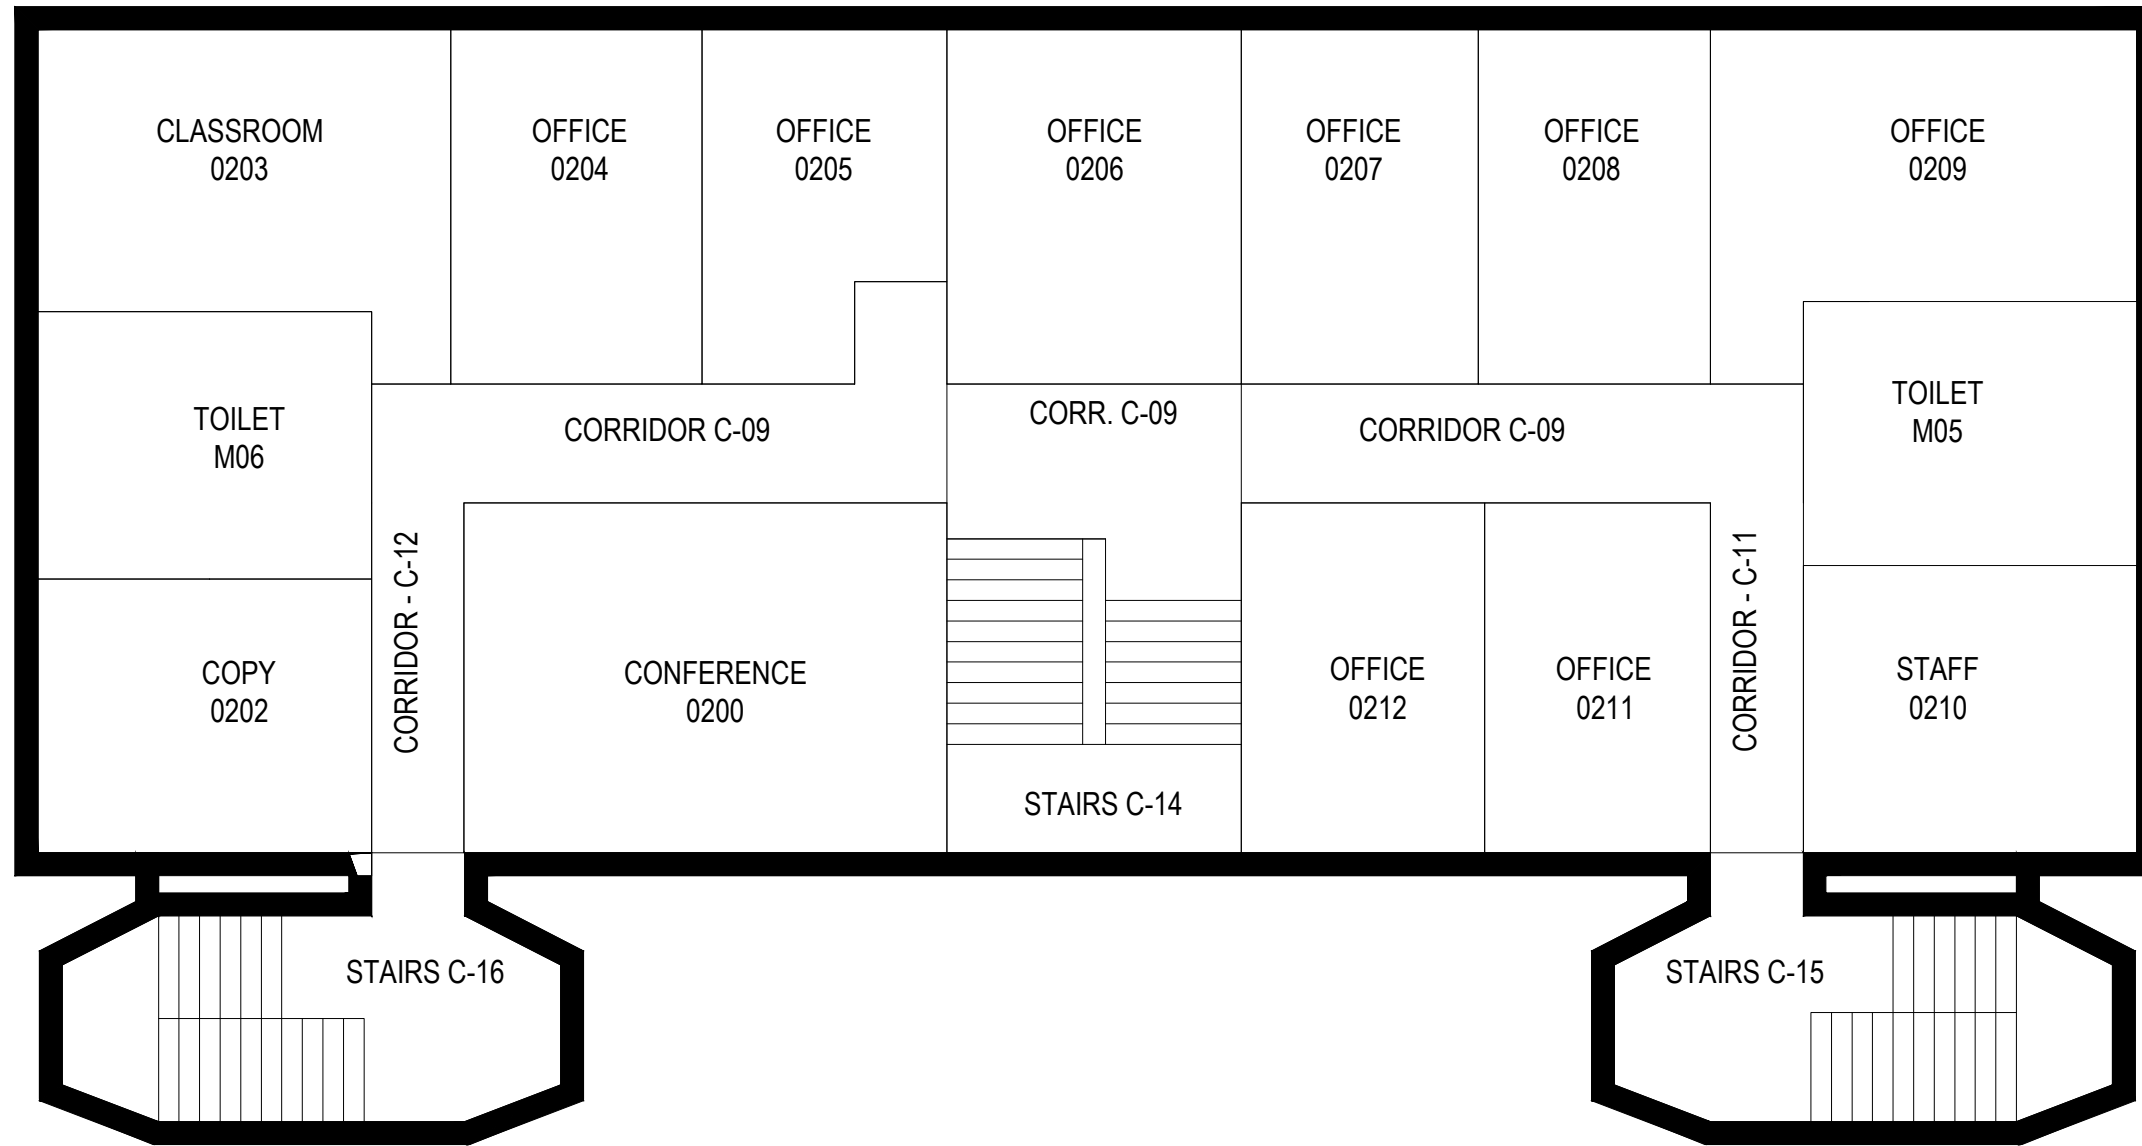

SECOND FLOOR PLAN



CLIENT

Farmingdale State College

SCALE:

1/8"=1'-0"

DATE:


JUNE-2015

Hooper Hall - 015



architects + engineers

Melville, NY Albany, NY
New City, NY Parsippany, NJ

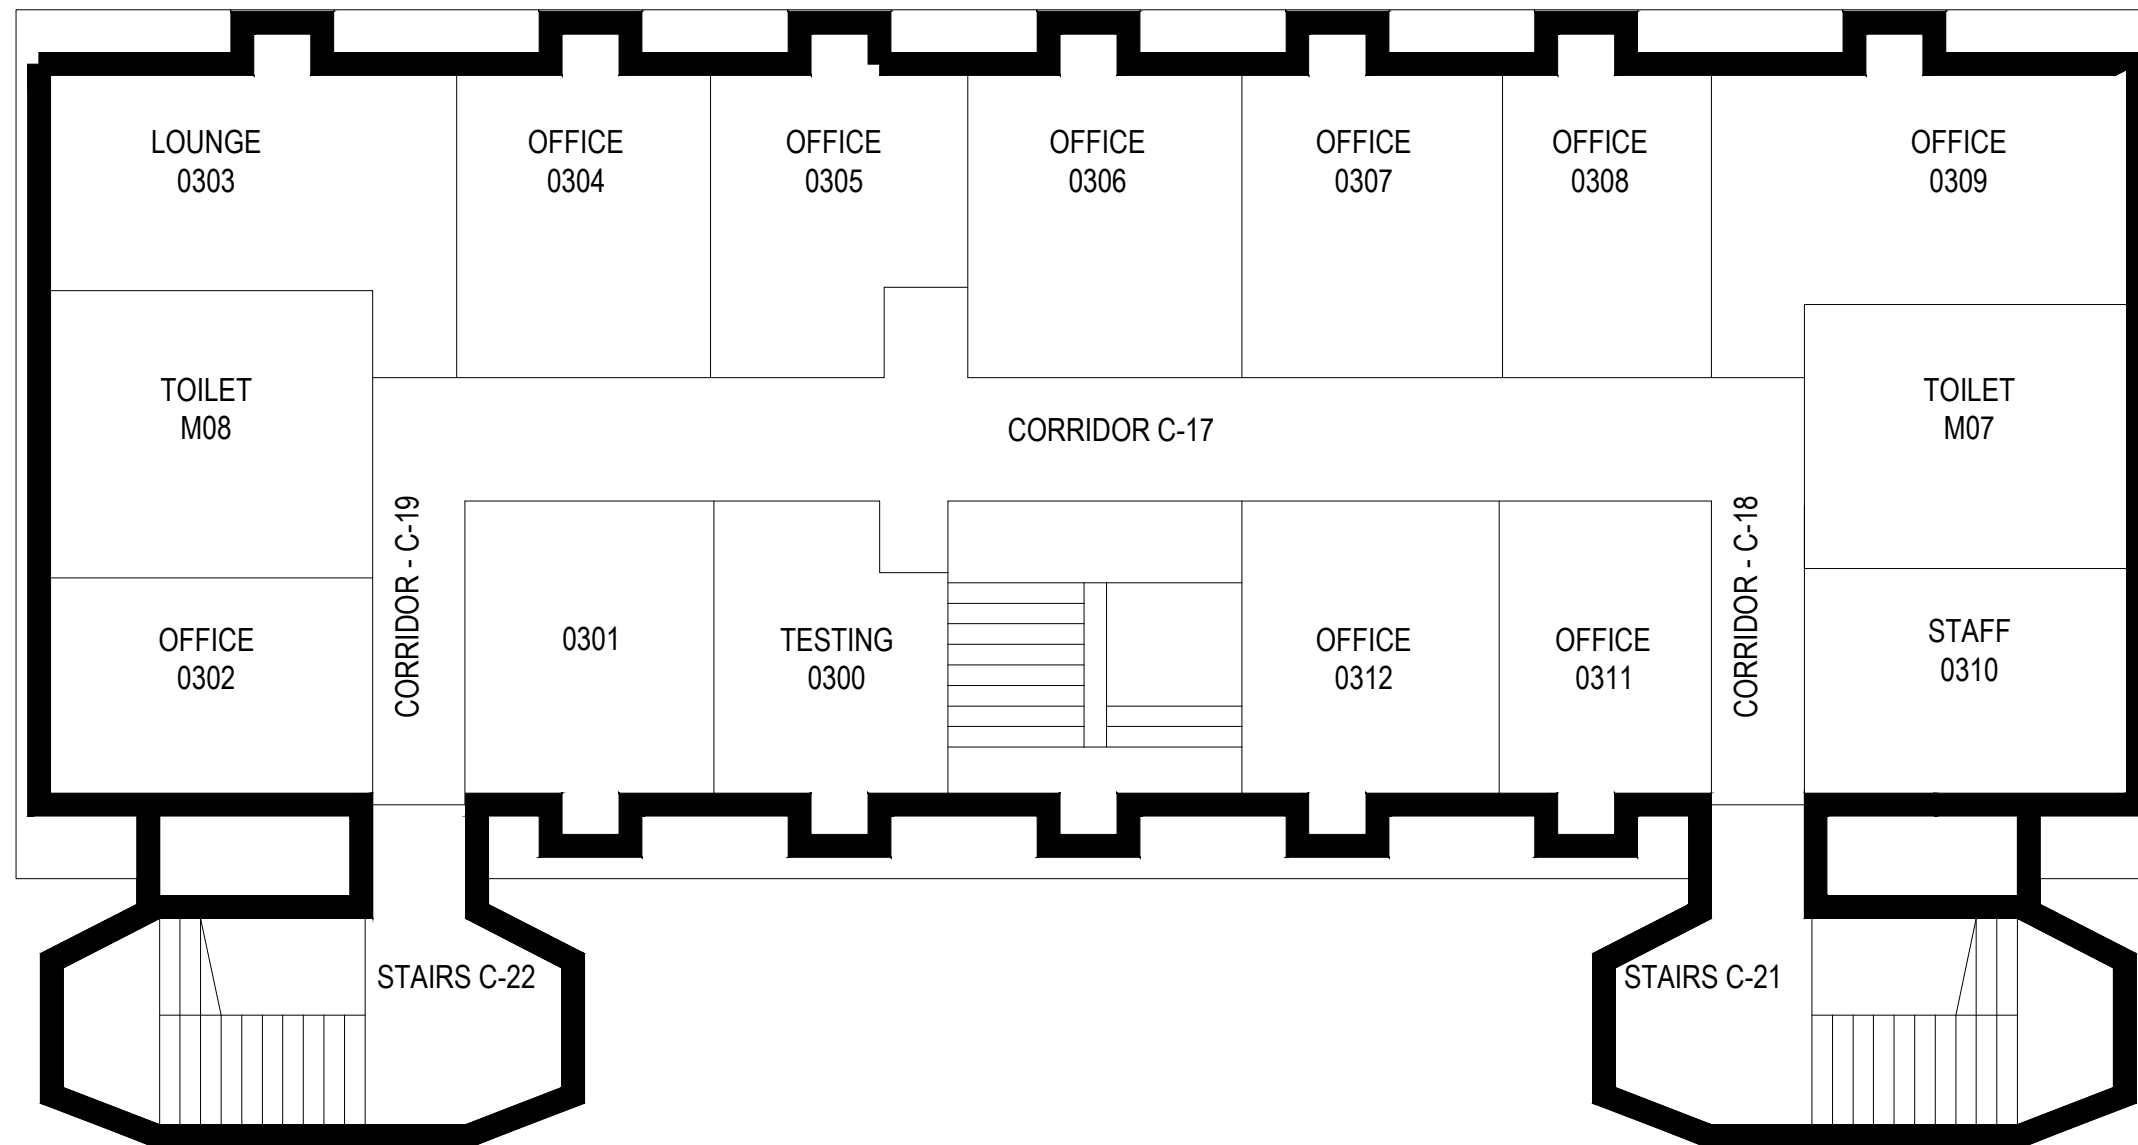

THIRD FLOOR PLAN



CLIENT

Farmingdale State College

SCALE:

1/8"=1'-0"

DATE:


JUNE-2015

Hooper Hall- 015



architects + engineers

Melville, NY Albany, NY
New City, NY Parsippany, NJ

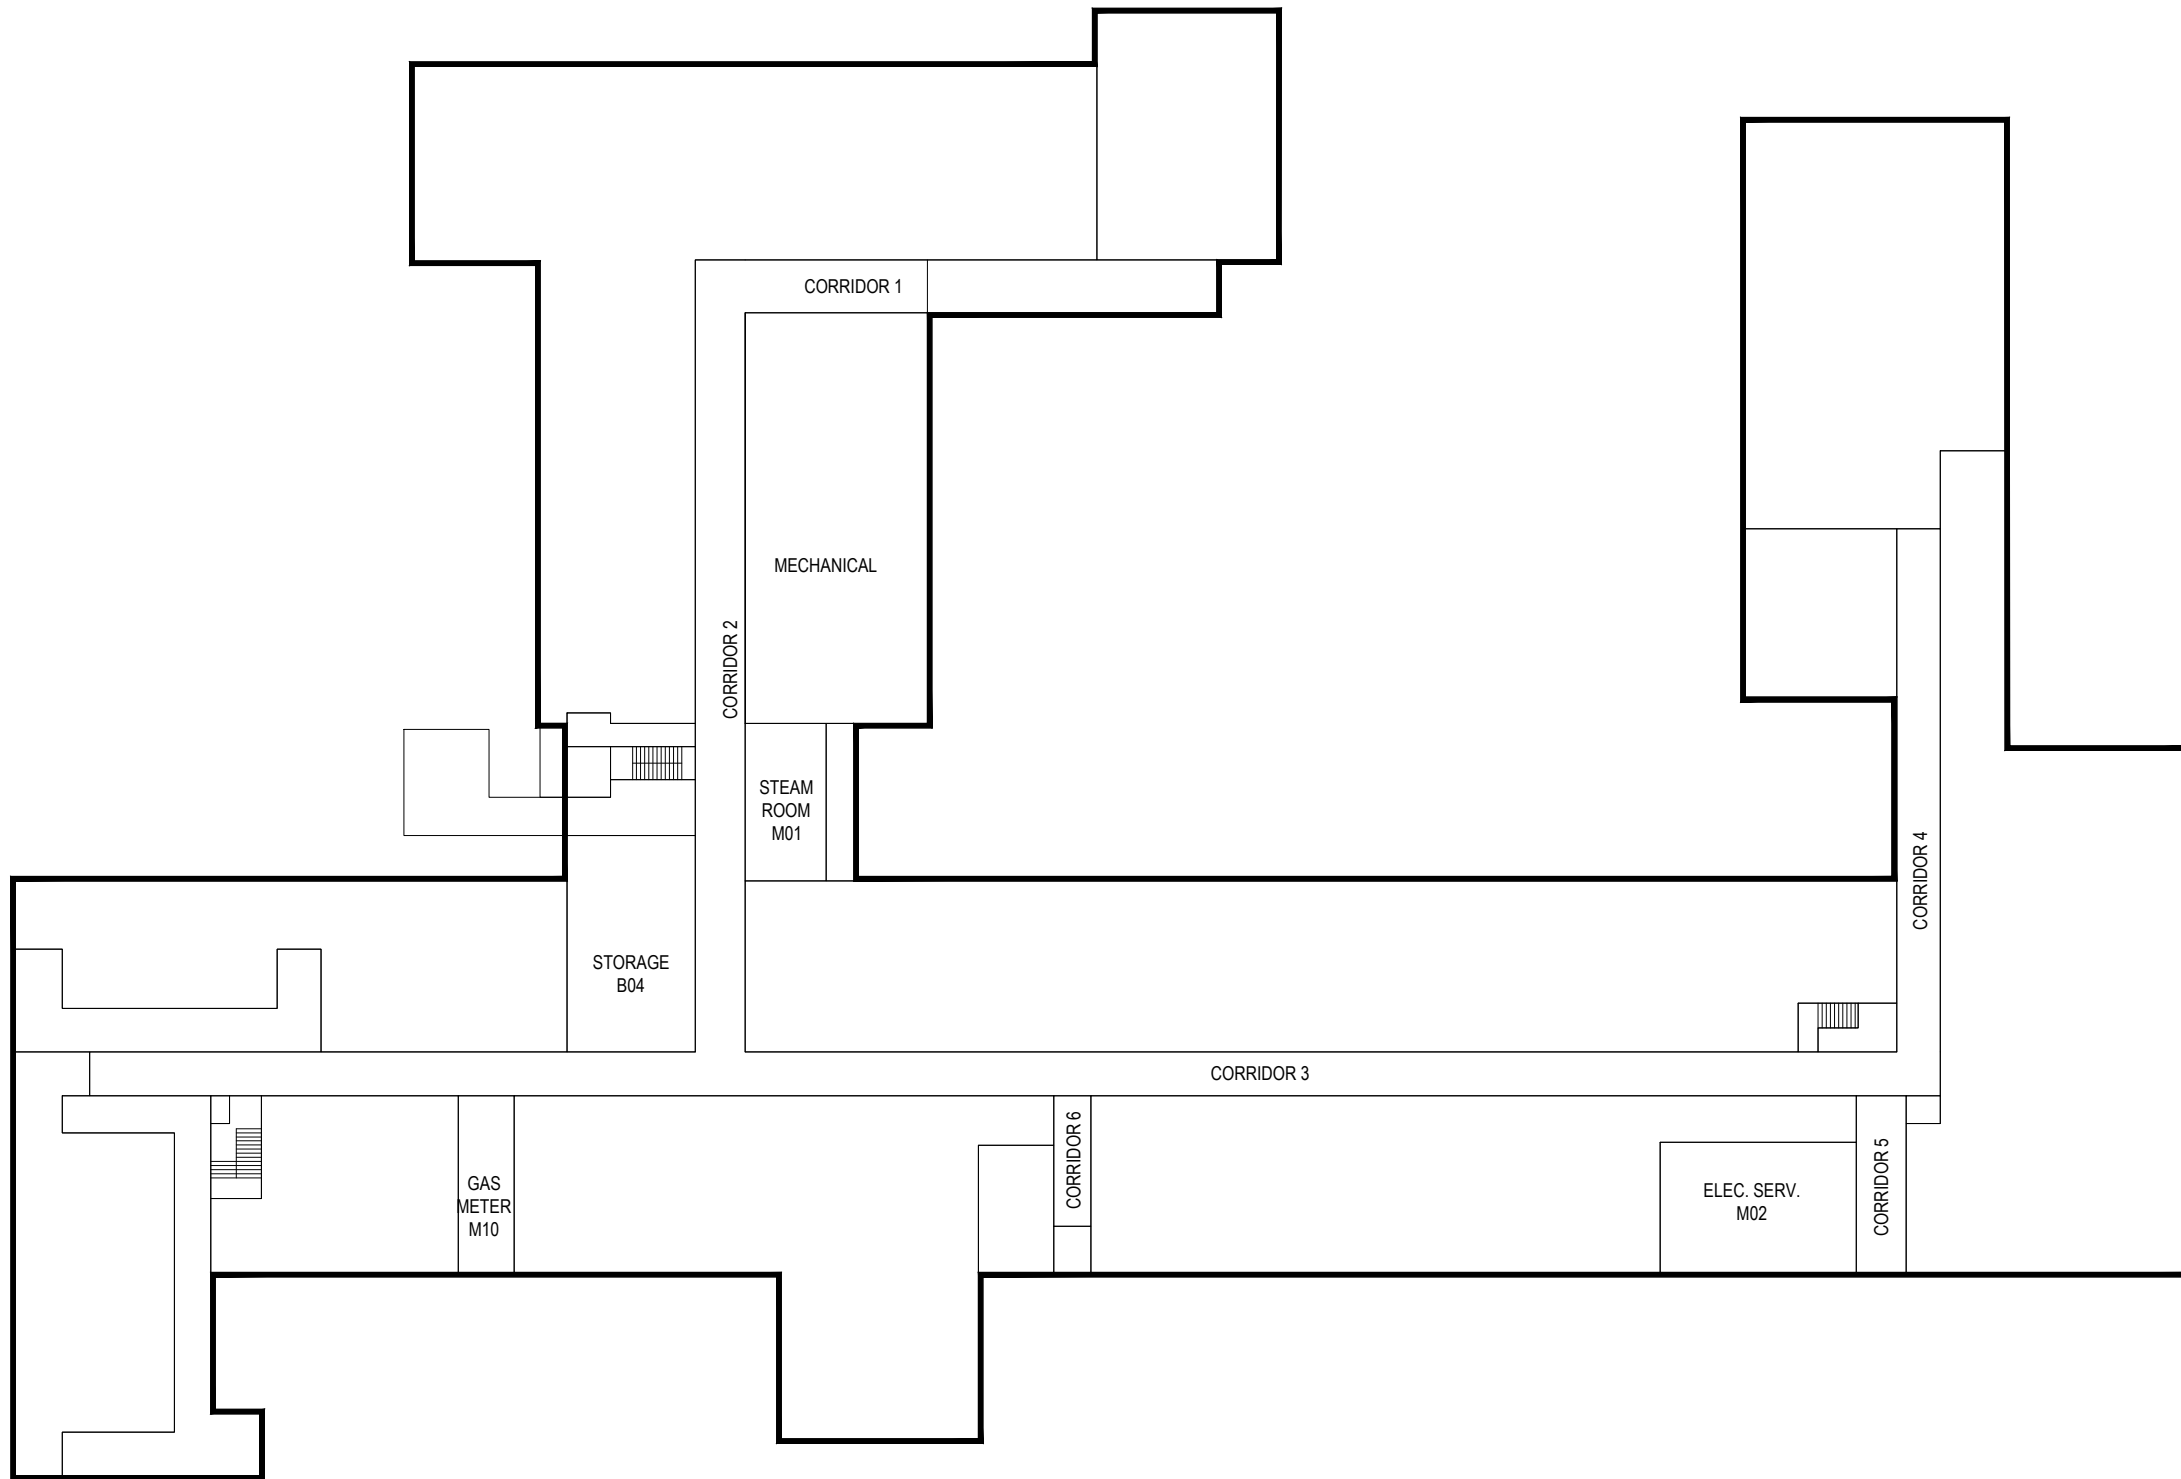

BASEMENT FLOOR PLAN



CLIENT

Farmingdale State College

SCALE:

1"=40'

DATE:


JUNE-2015

Lupton Hall - 063



architects + engineers

Melville, NY Albany, NY
New City, NY Parsippany, NJ

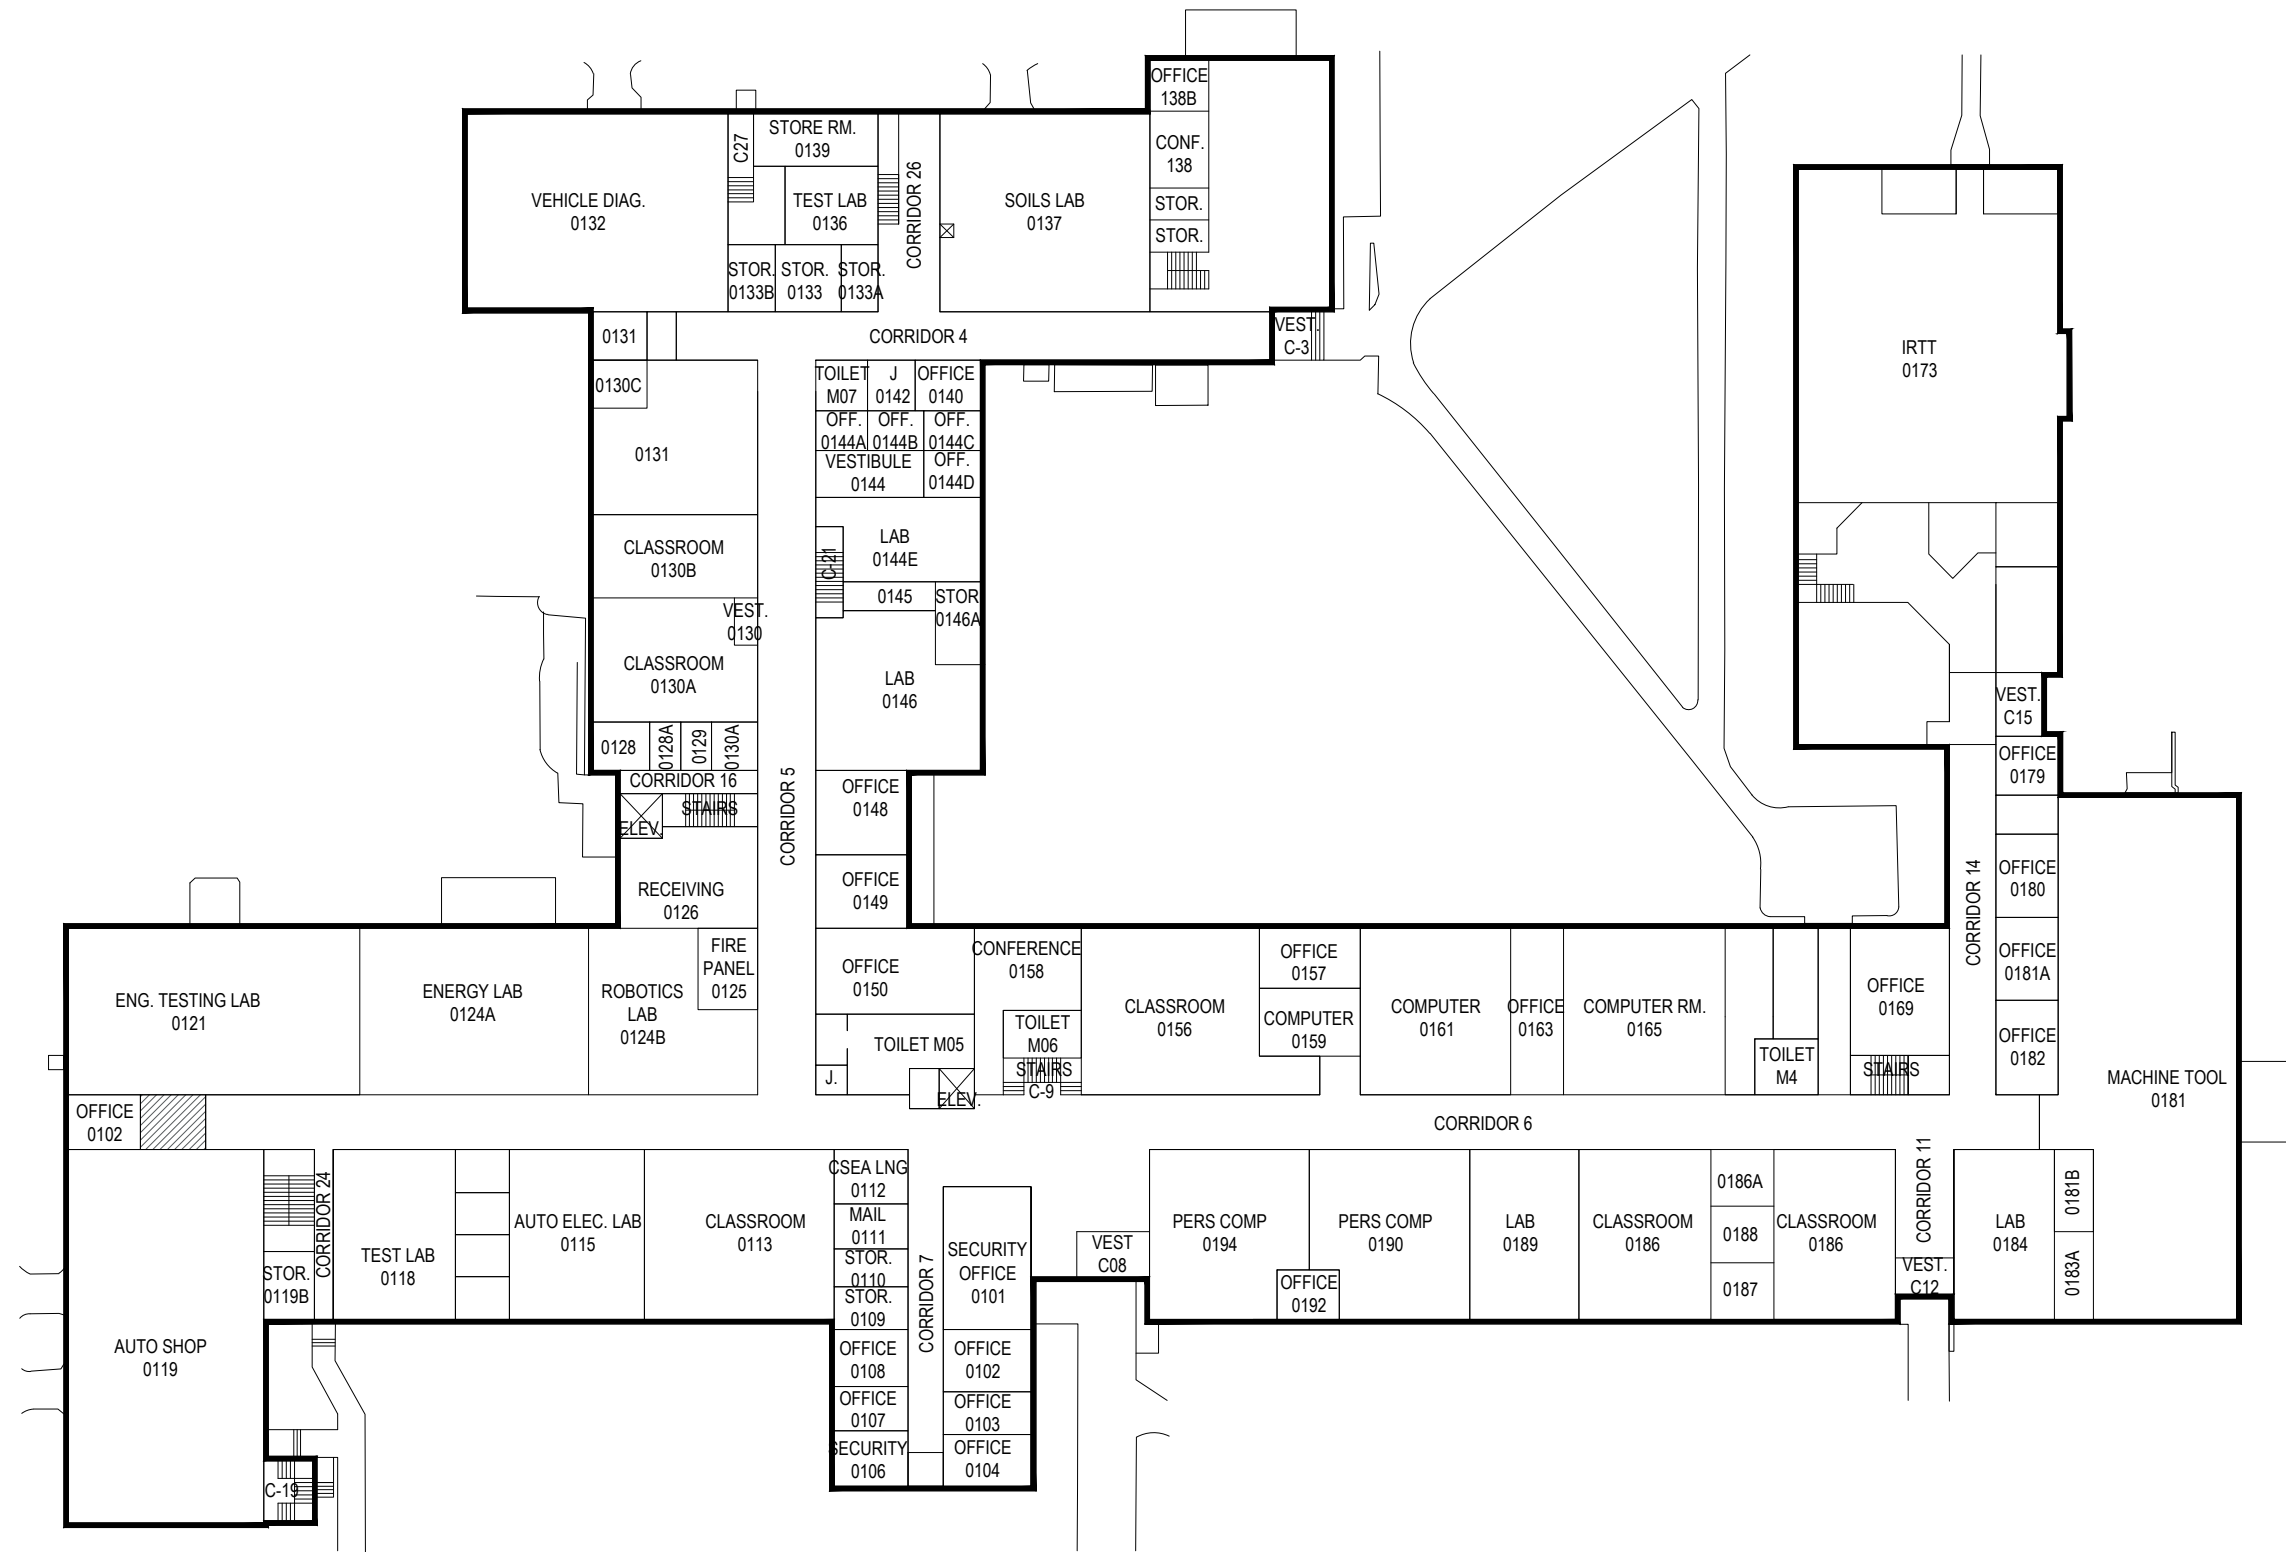

FIRST FLOOR PLAN



CLIENT

Farmingdale State College

SCALE:


1"=40'

DATE:

JUNE-2015

Lupton Hall - 063

H	2	architects + engineers
M	M	
Melville, NY New City, NY	Albany, NY Parsippany, NJ	

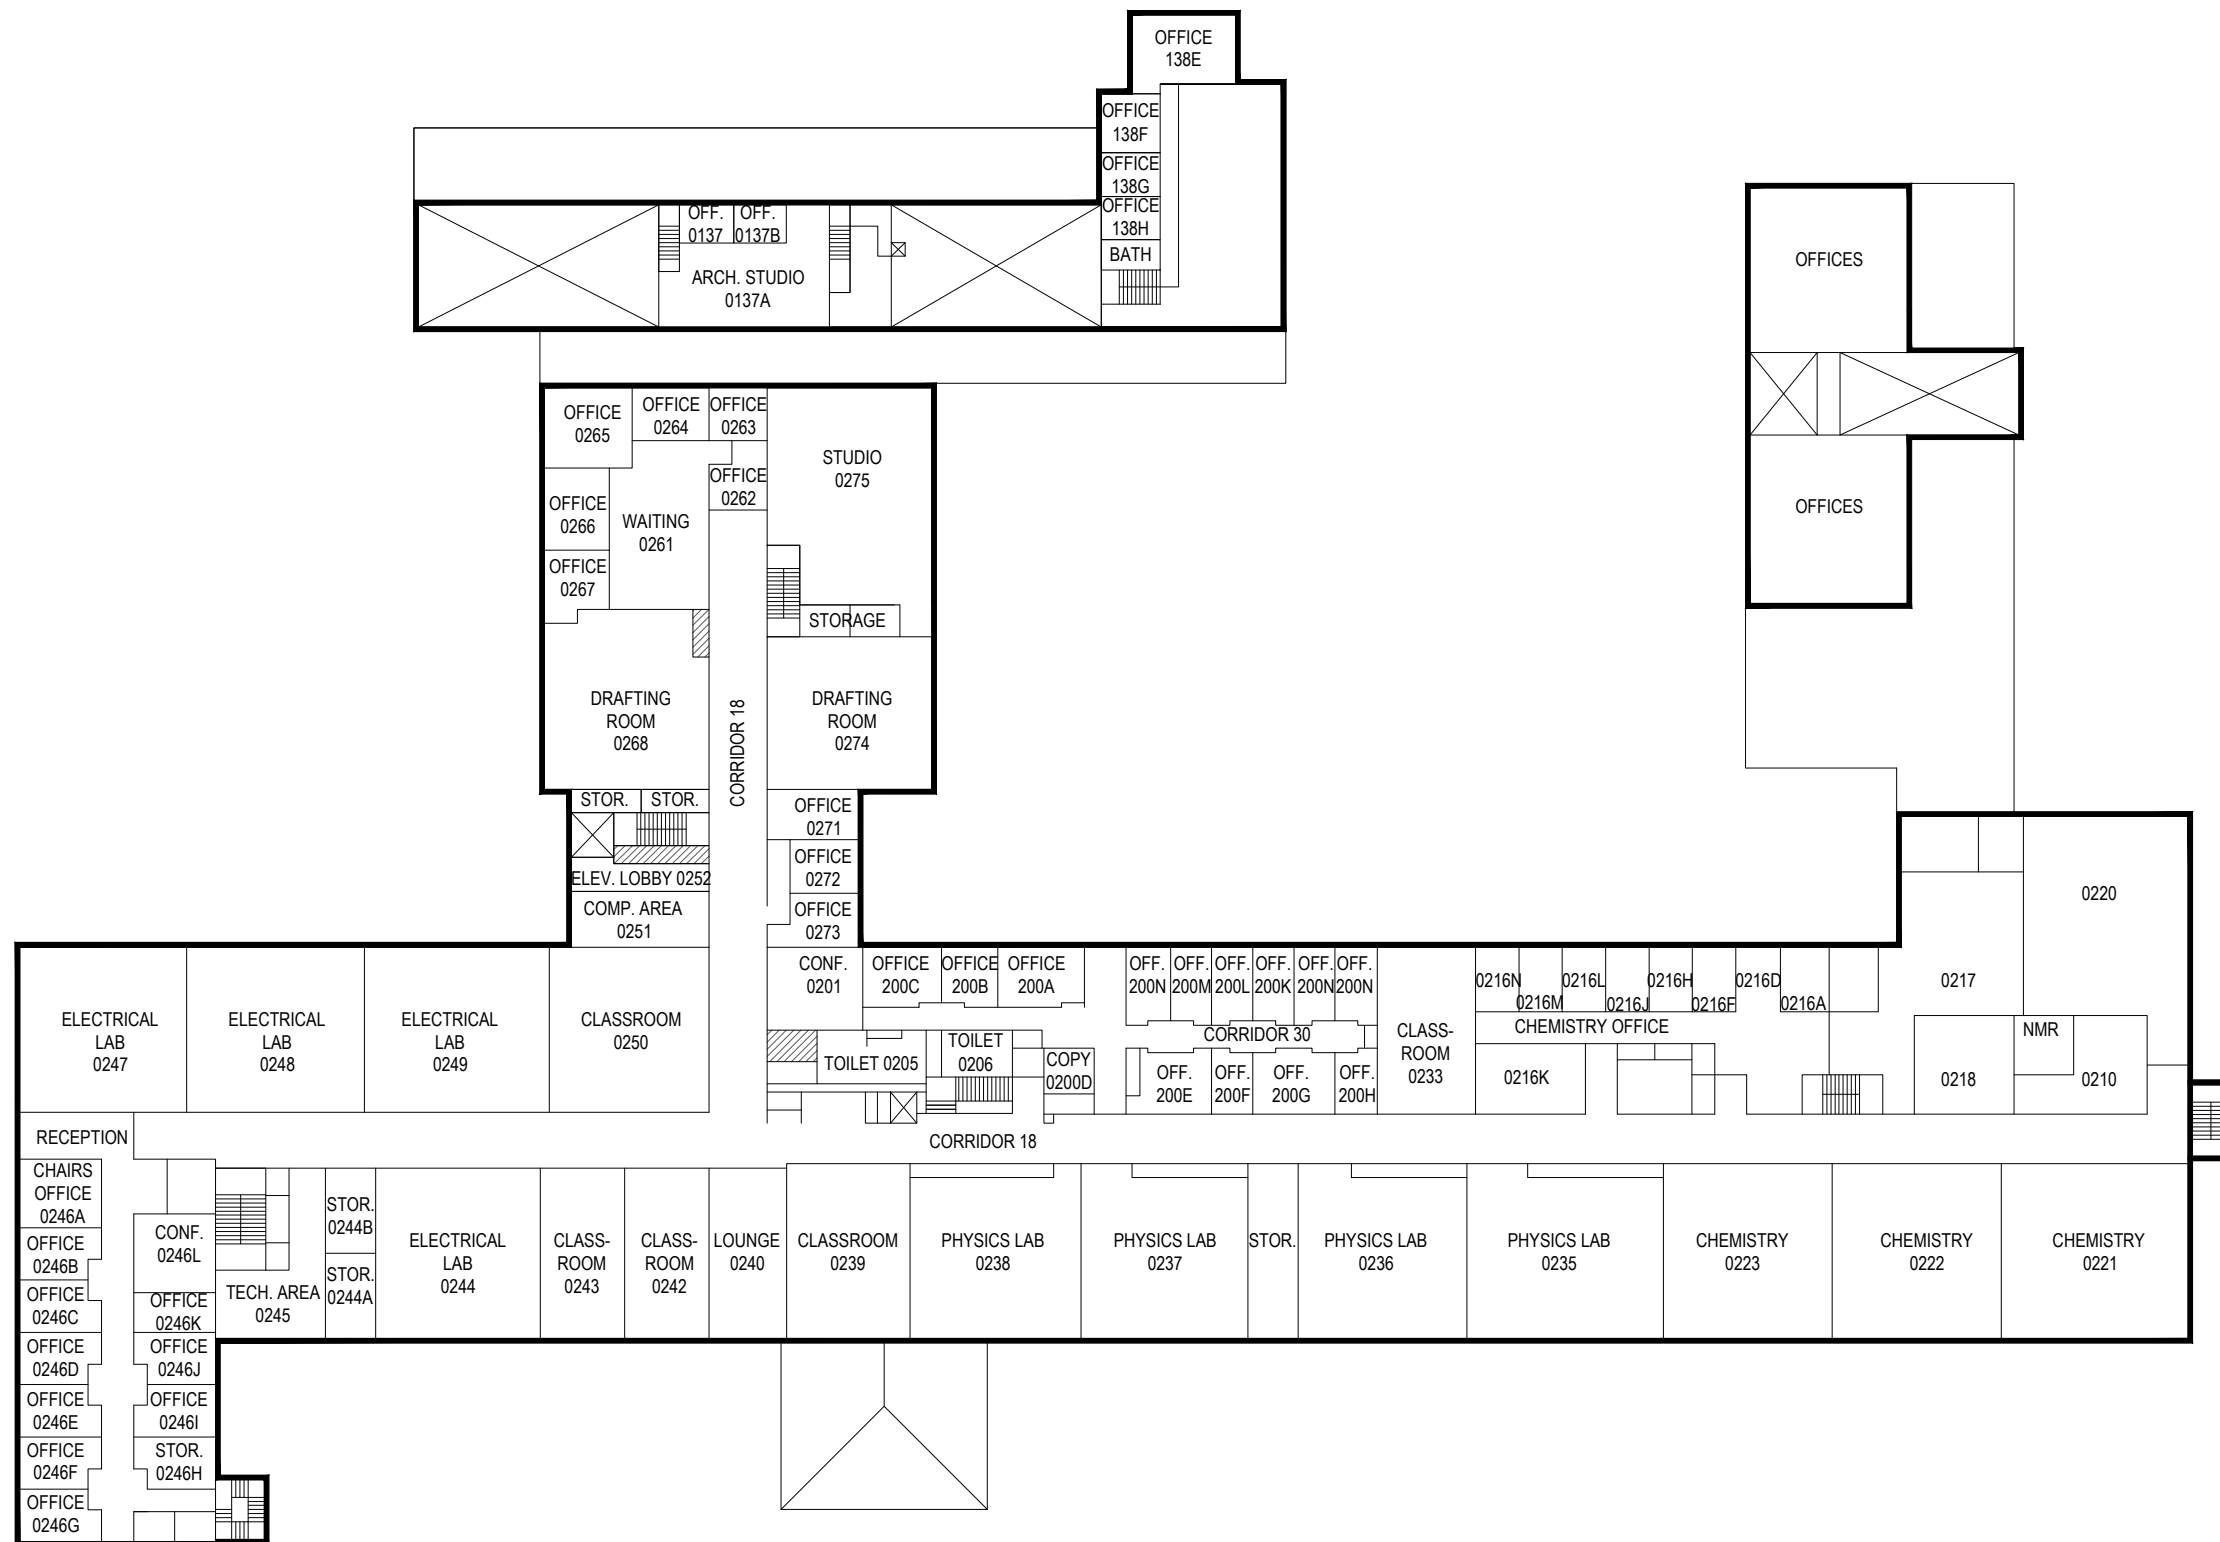

SECOND FLOOR PLAN



CLIENT

Farmingdale State College

SCALE:

1"=40'

DATE:


JUNE-2015

Lupton Hall - 063




architects + engineers

Melville, NY Albany, NY
New City, NY Parsippany, NJ

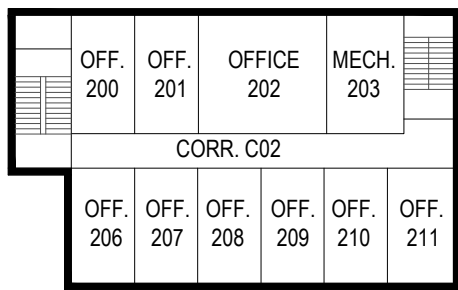

SECOND FLOOR PLAN

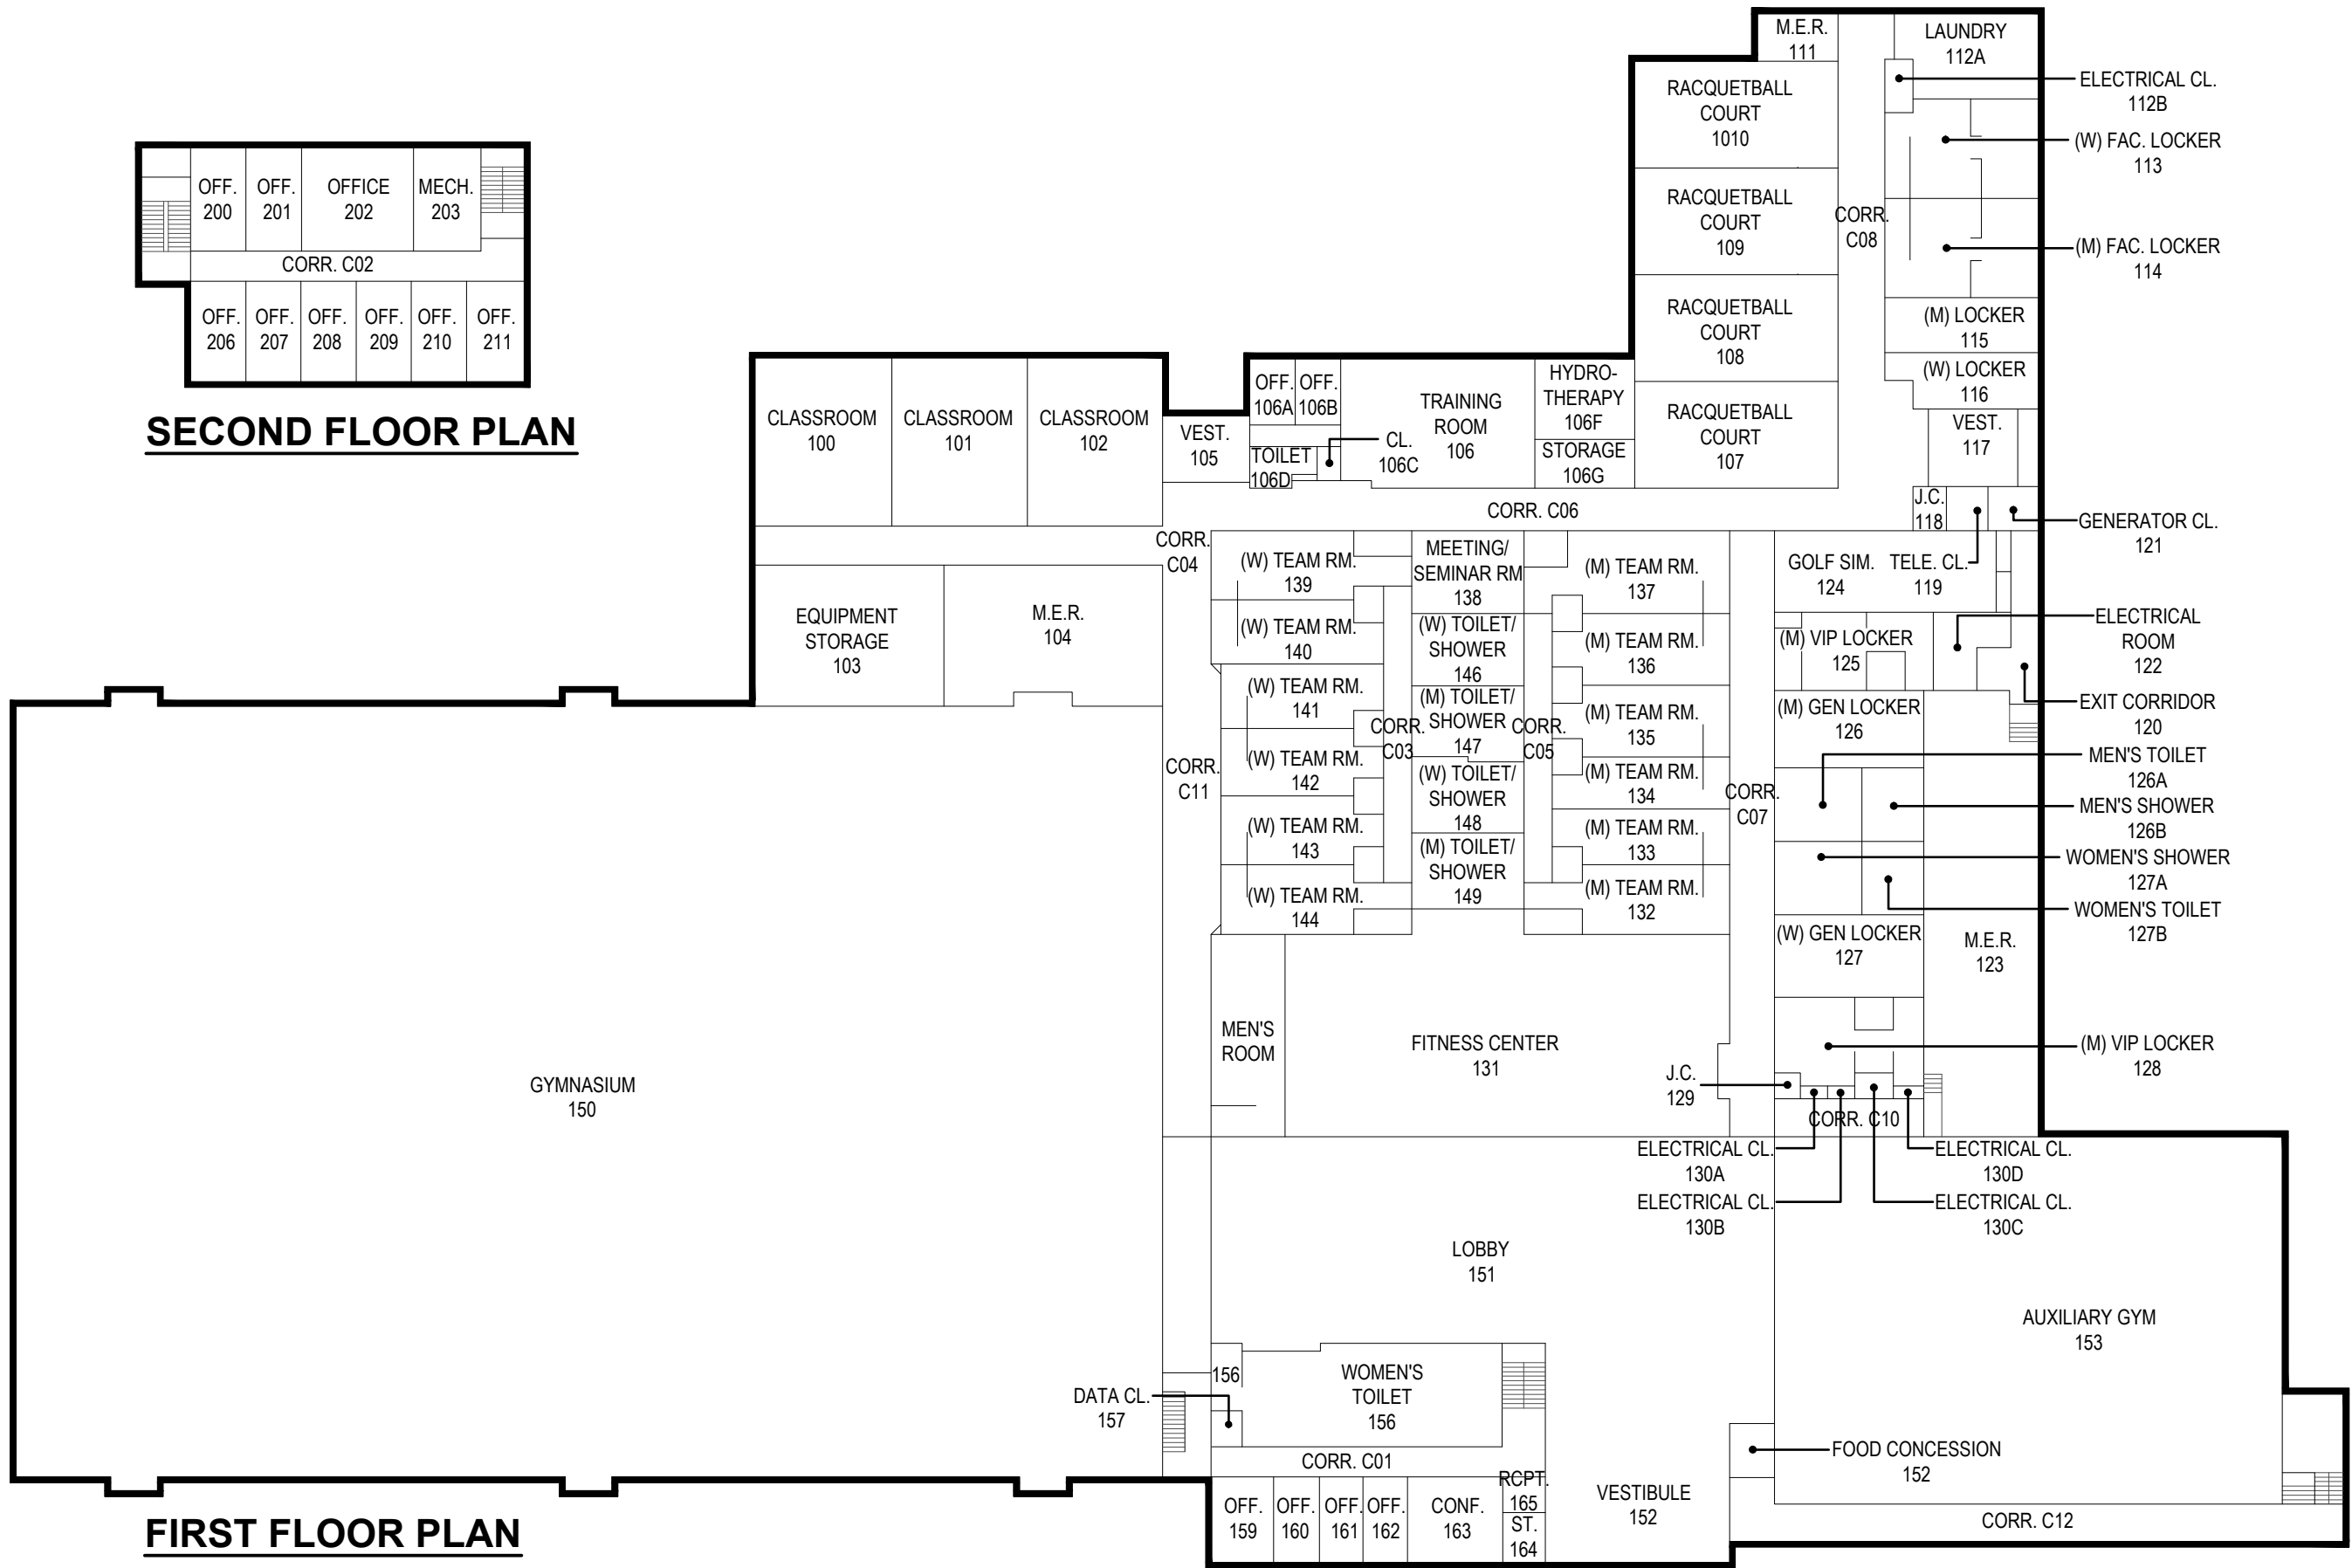


FIRST FLOOR PLAN

CLIENT
Farmingdale State College

SCALE:
1/32"=1'-0"
 DATE:
JUNE-2015

Nold Hall - 085

H 2 M
 architects + engineers
 Melville, NY Albany, NY
 New City, NY Parsippany, NJ

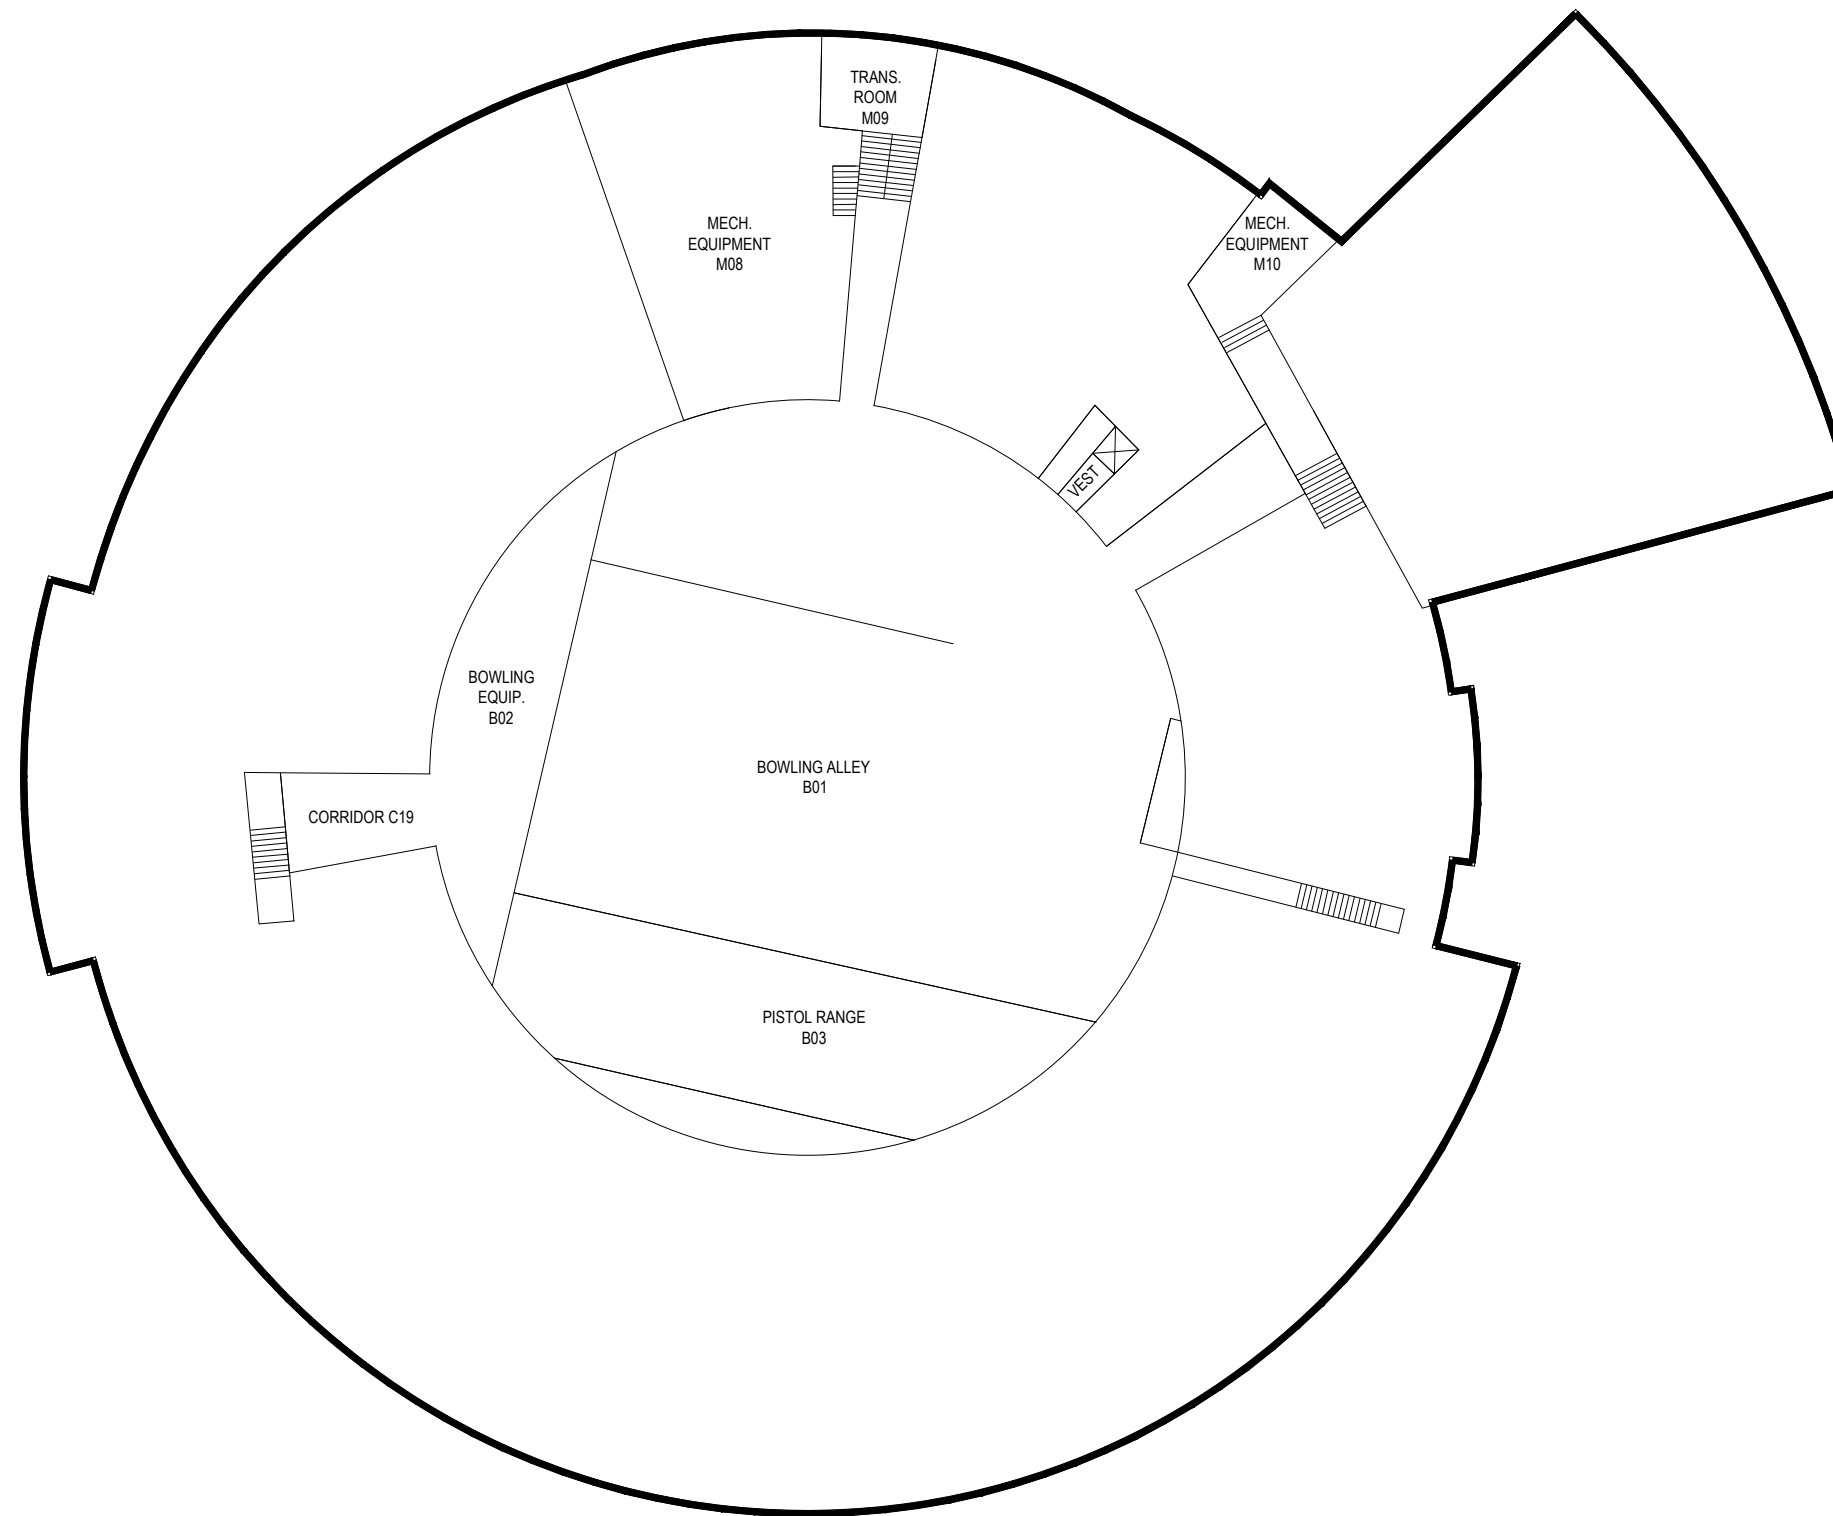

BASEMENT FLOOR PLAN



CLIENT

Farmingdale State College

SCALE:

1/16"=1'-0"

DATE:


JUNE-2015

Roosevelt - 042




architects + engineers

Melville, NY Albany, NY
New City, NY Parsippany, NJ

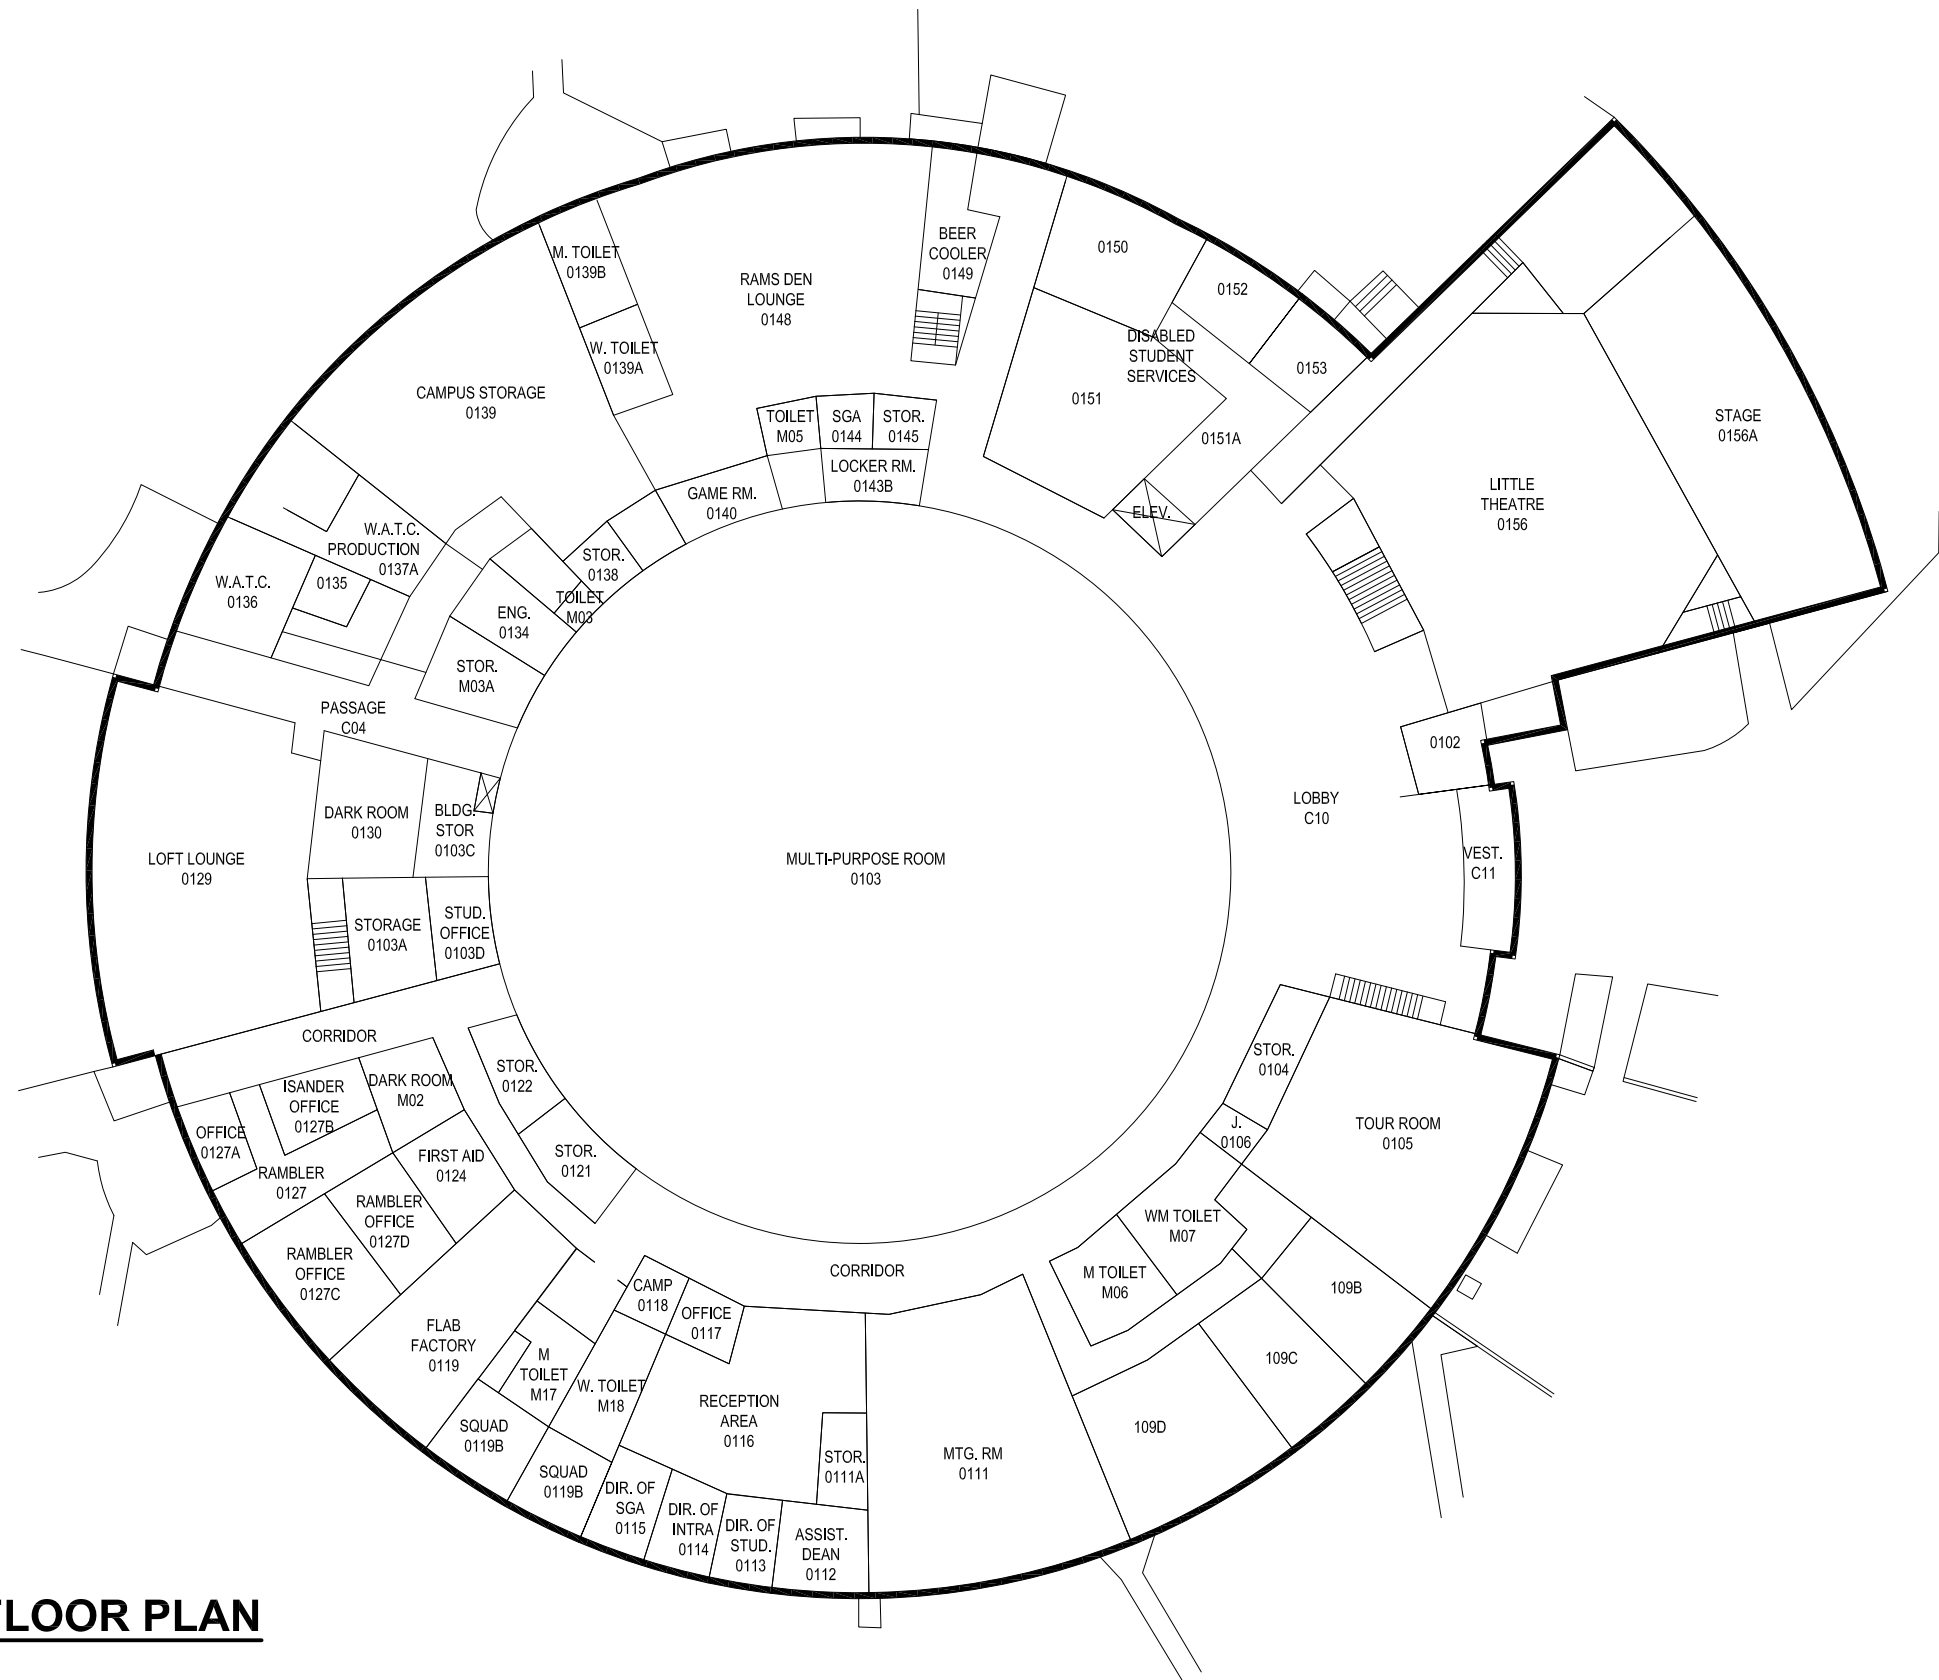

FIRST FLOOR PLAN



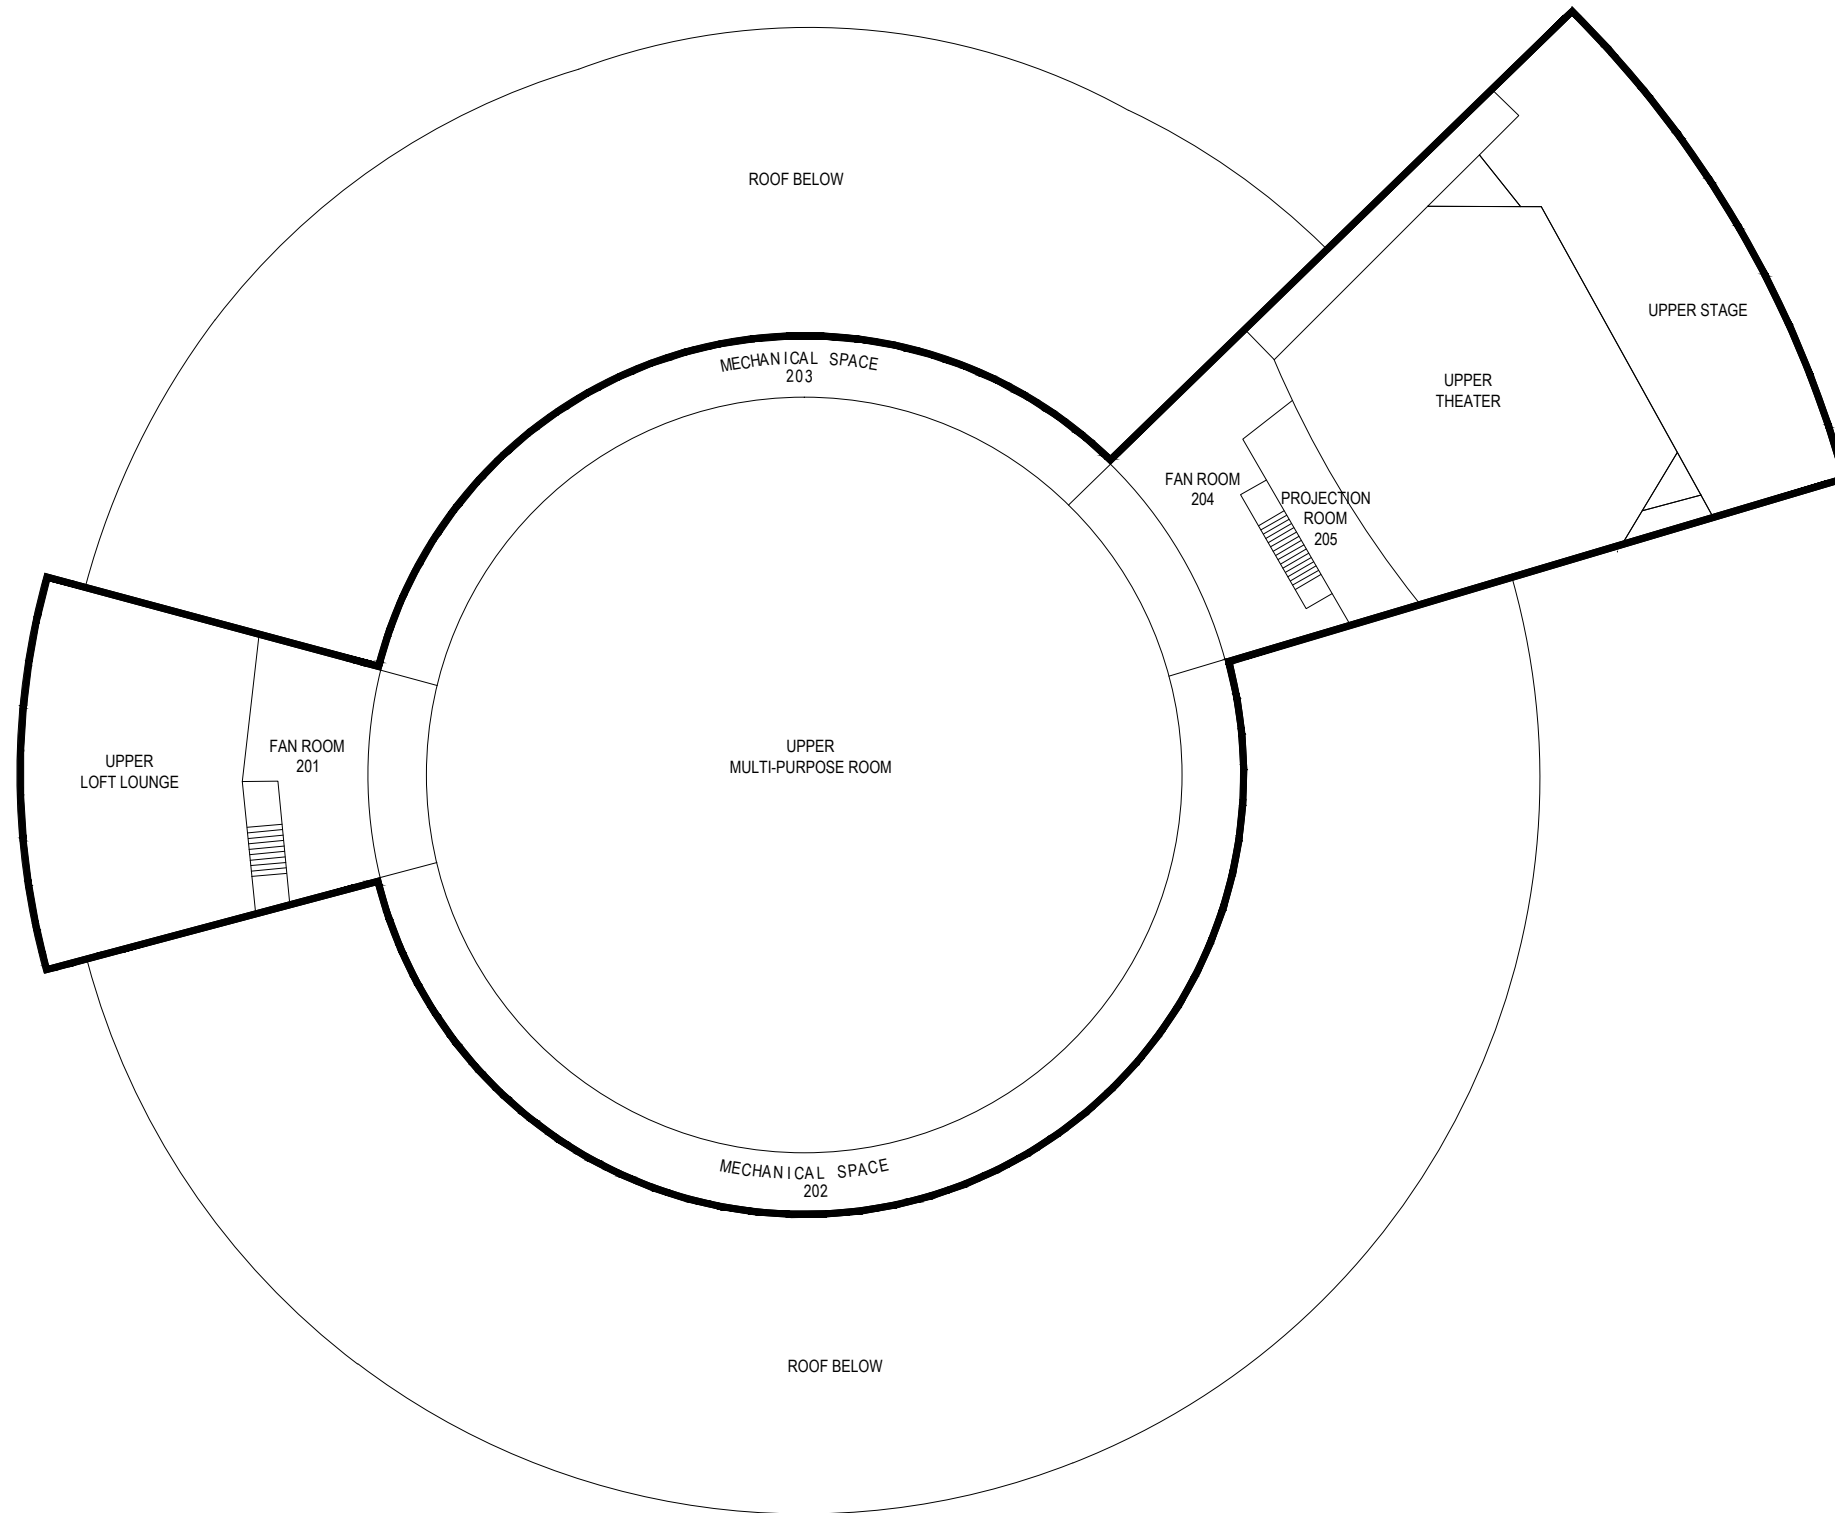

SECOND FLOOR PLAN



CLIENT

Farmingdale State College

SCALE:

1"=30'-0"

DATE:


JUNE-2015

Roosevelt Hall - 042



architects + engineers

Melville, NY Albany, NY
New City, NY Parsippany, NJ

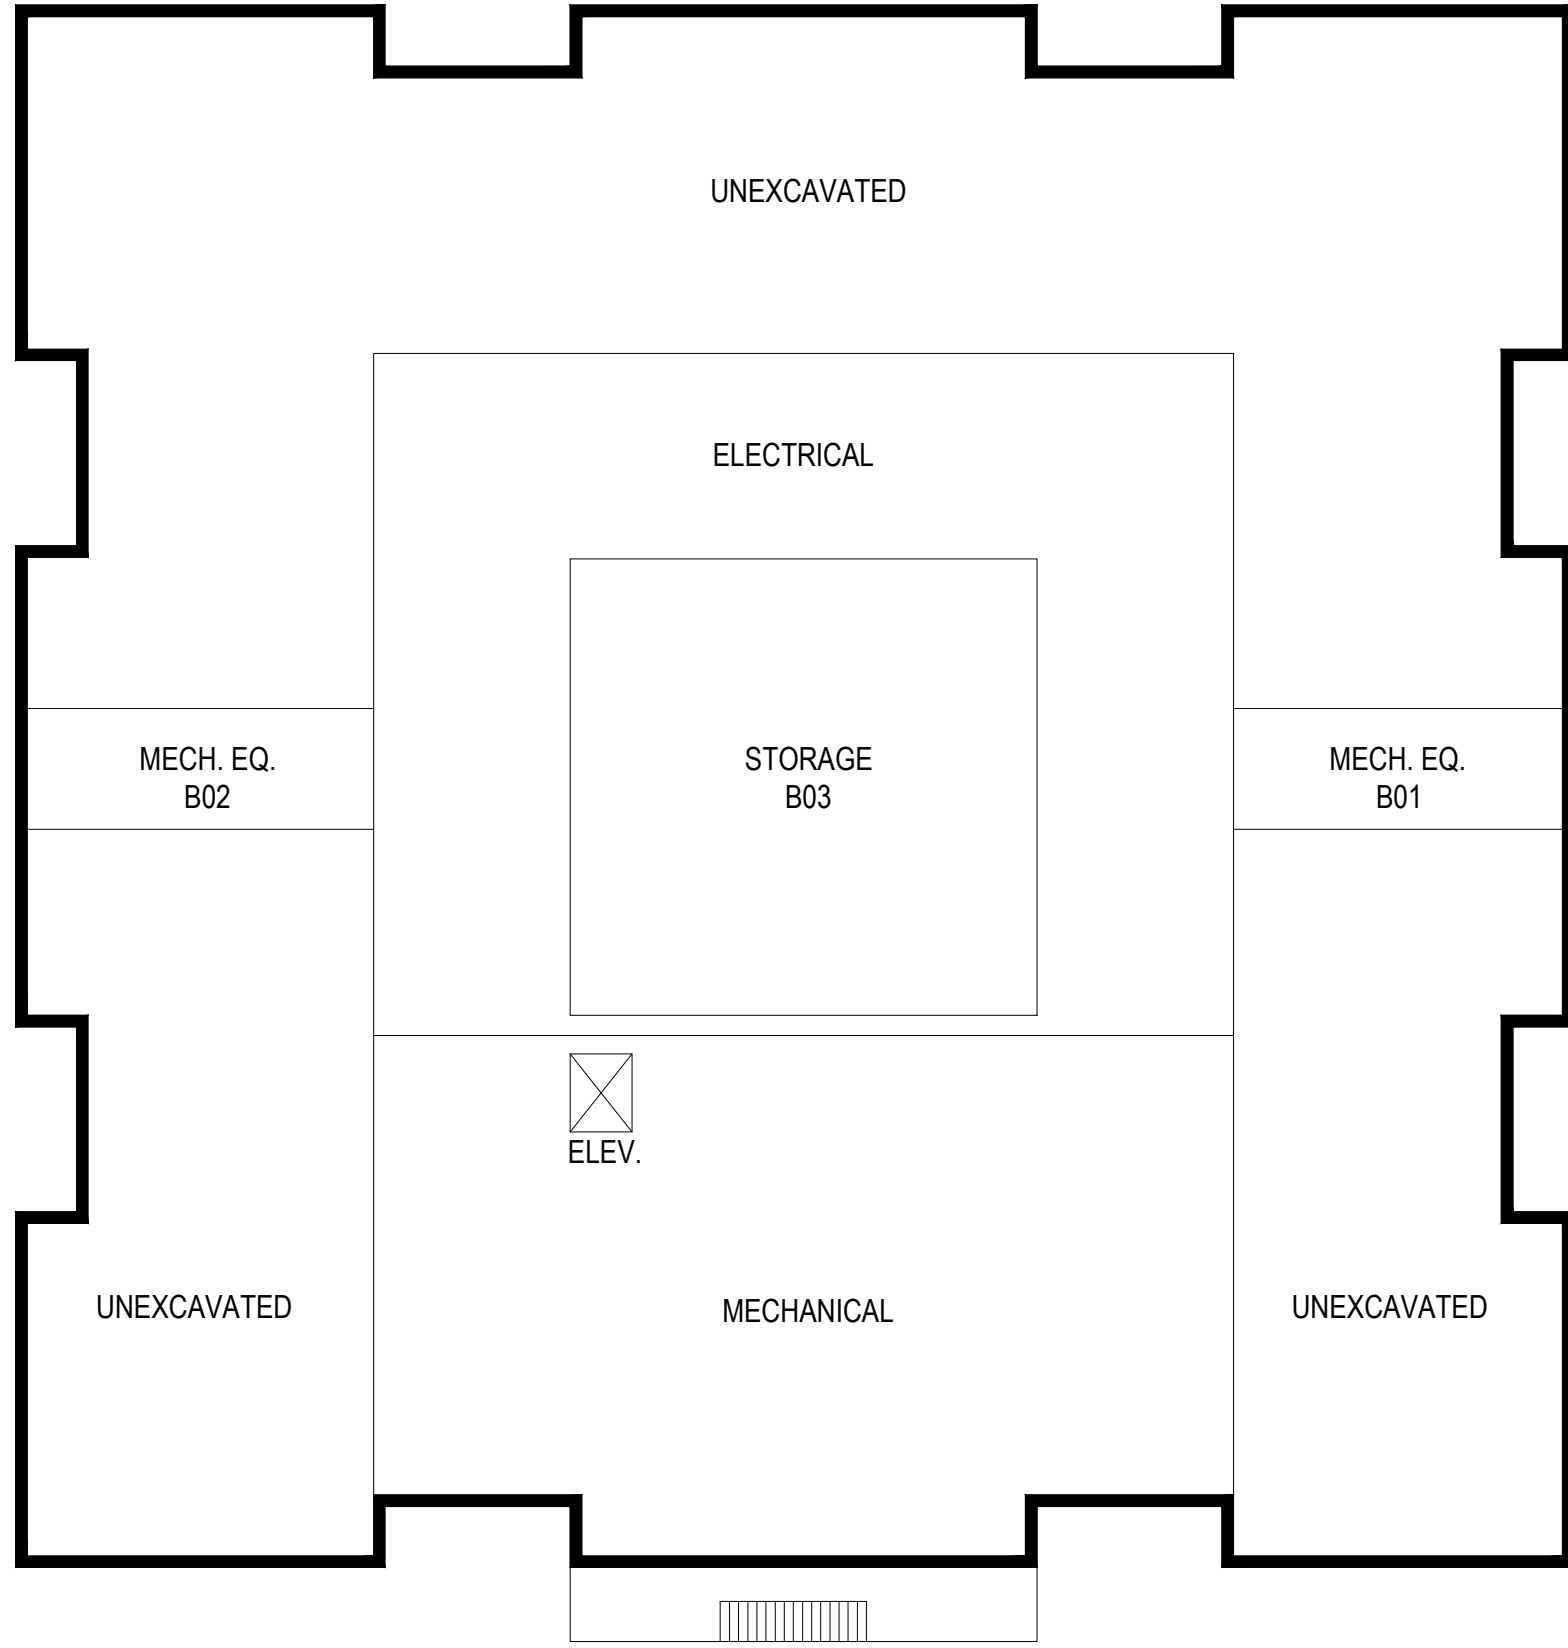

BASEMENT FLOOR PLAN



CLIENT

Farmingdale State College


SCALE:

1/16"=1'-0"

DATE:

JUNE-2015


Sinclair Hall- 094

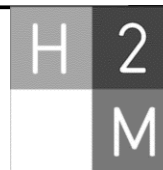

architects + engineers

Melville, NY Albany, NY
New City, NY Parsippany, NJ

40

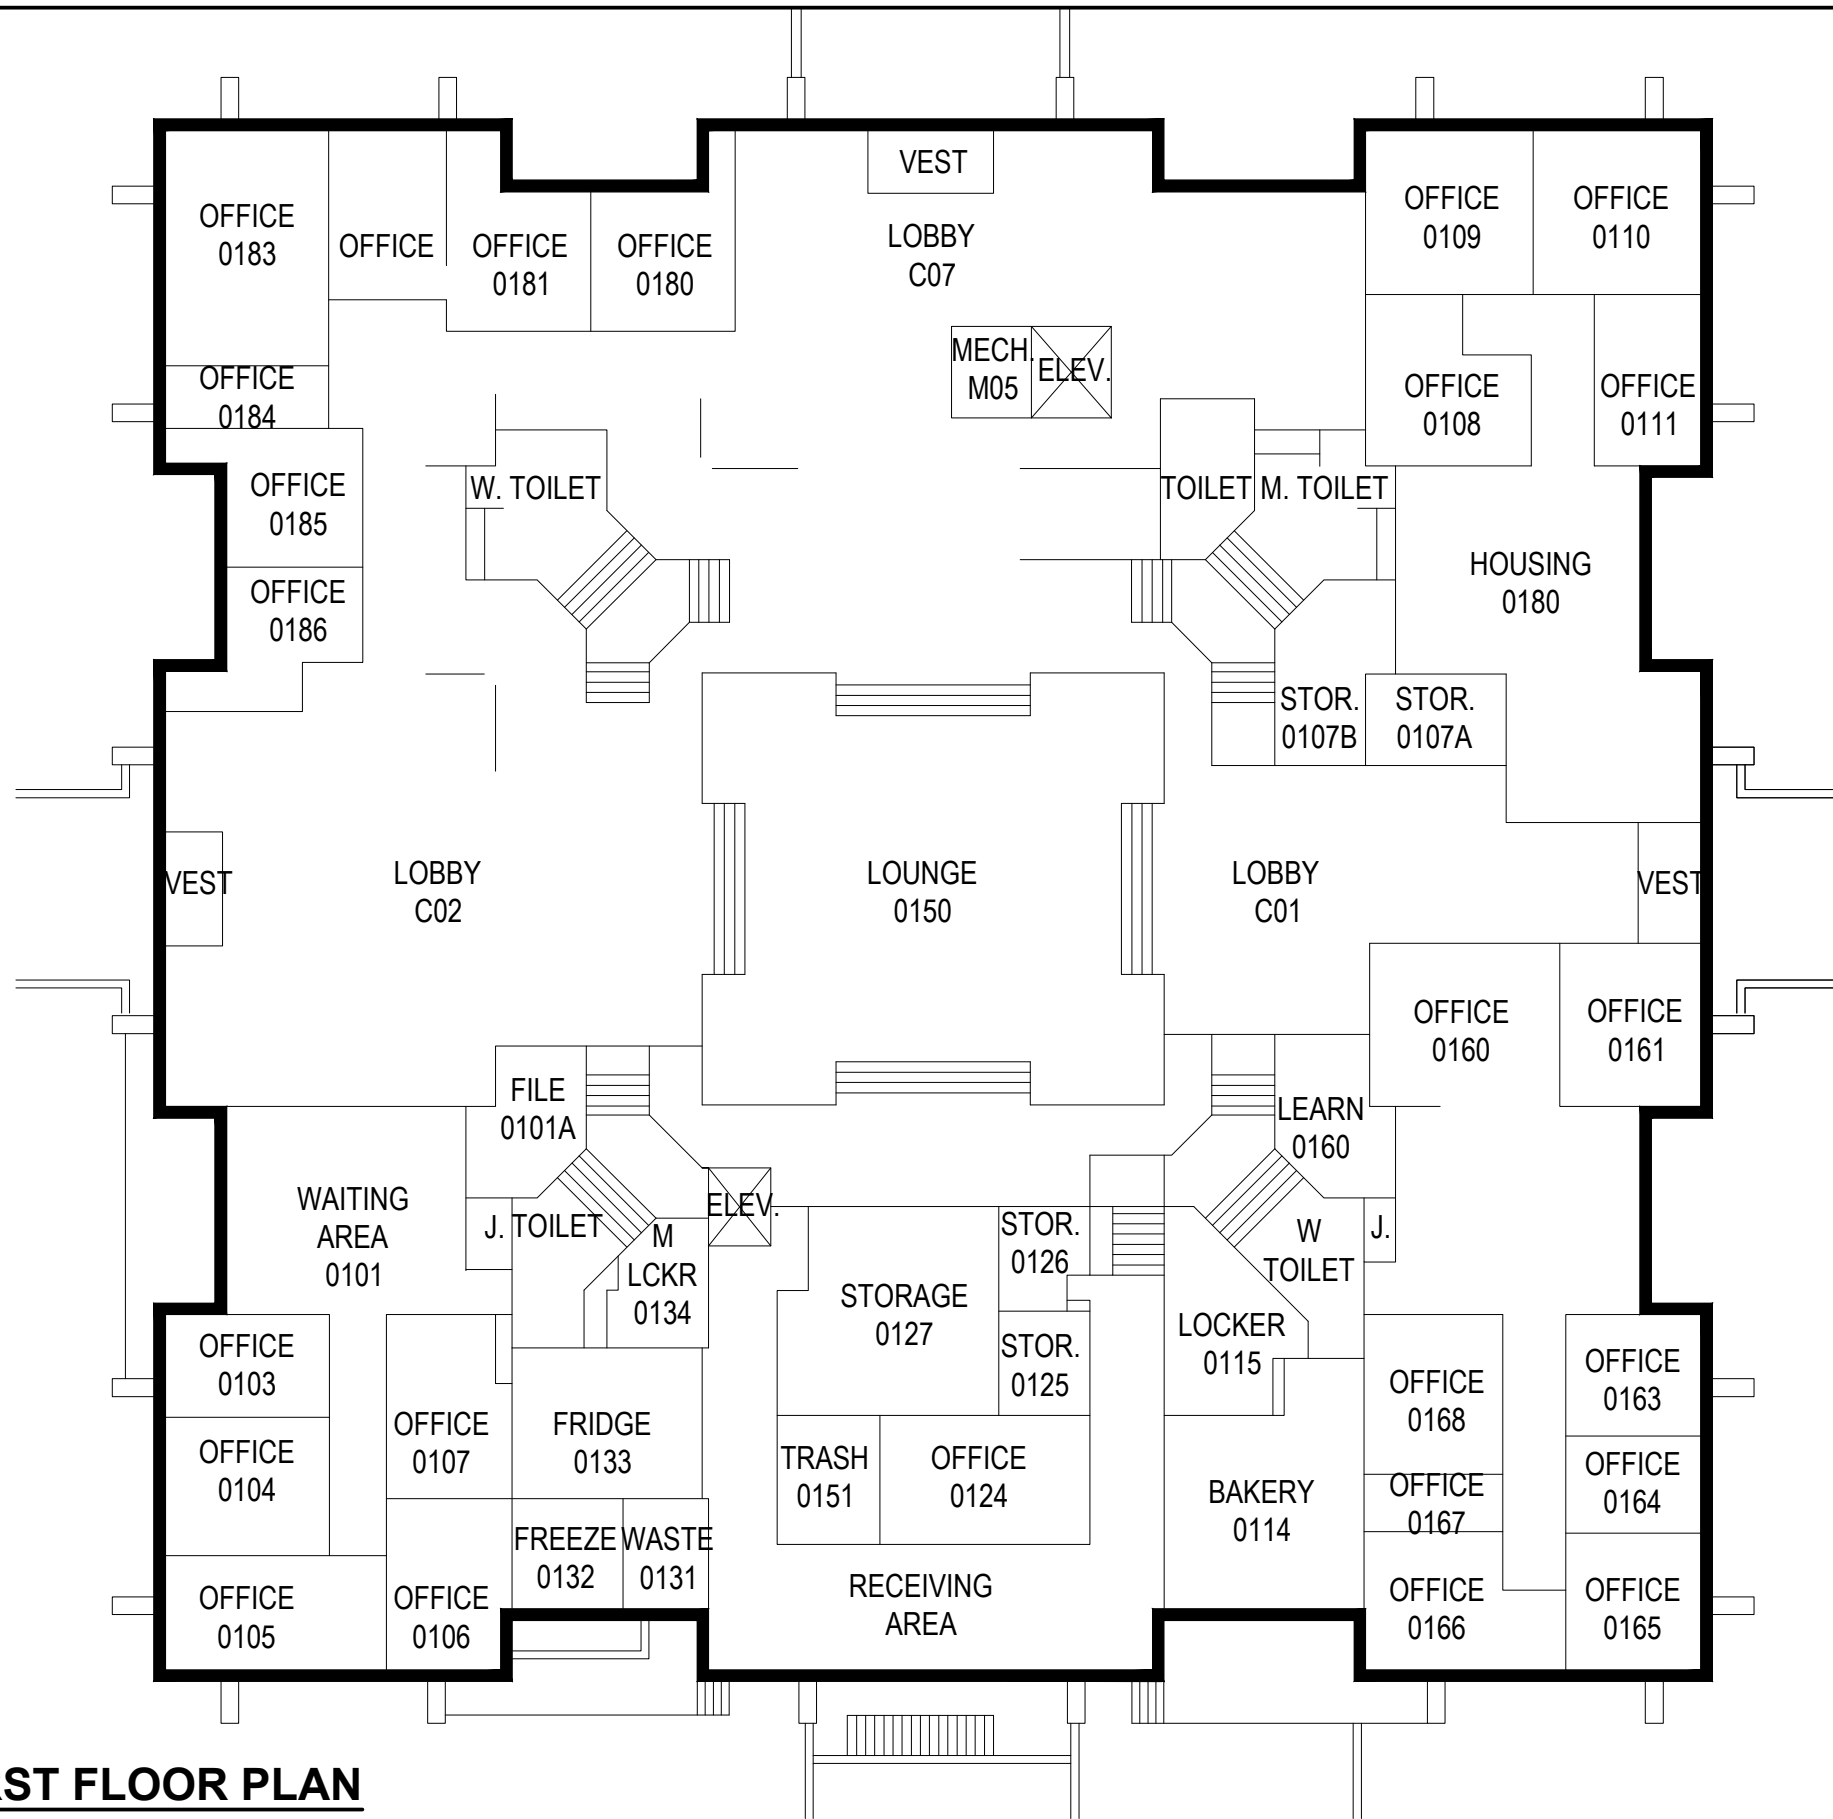

FIRST FLOOR PLAN



CLIENT

Farmingdale State College

SCALE:


1/16"=1'-0"

DATE:

JUNE-2015

Sinclair Hall- 094

H	2	architects + engineers
M	M	
Melville, NY New City, NY		Albany, NY Parsippany, NJ

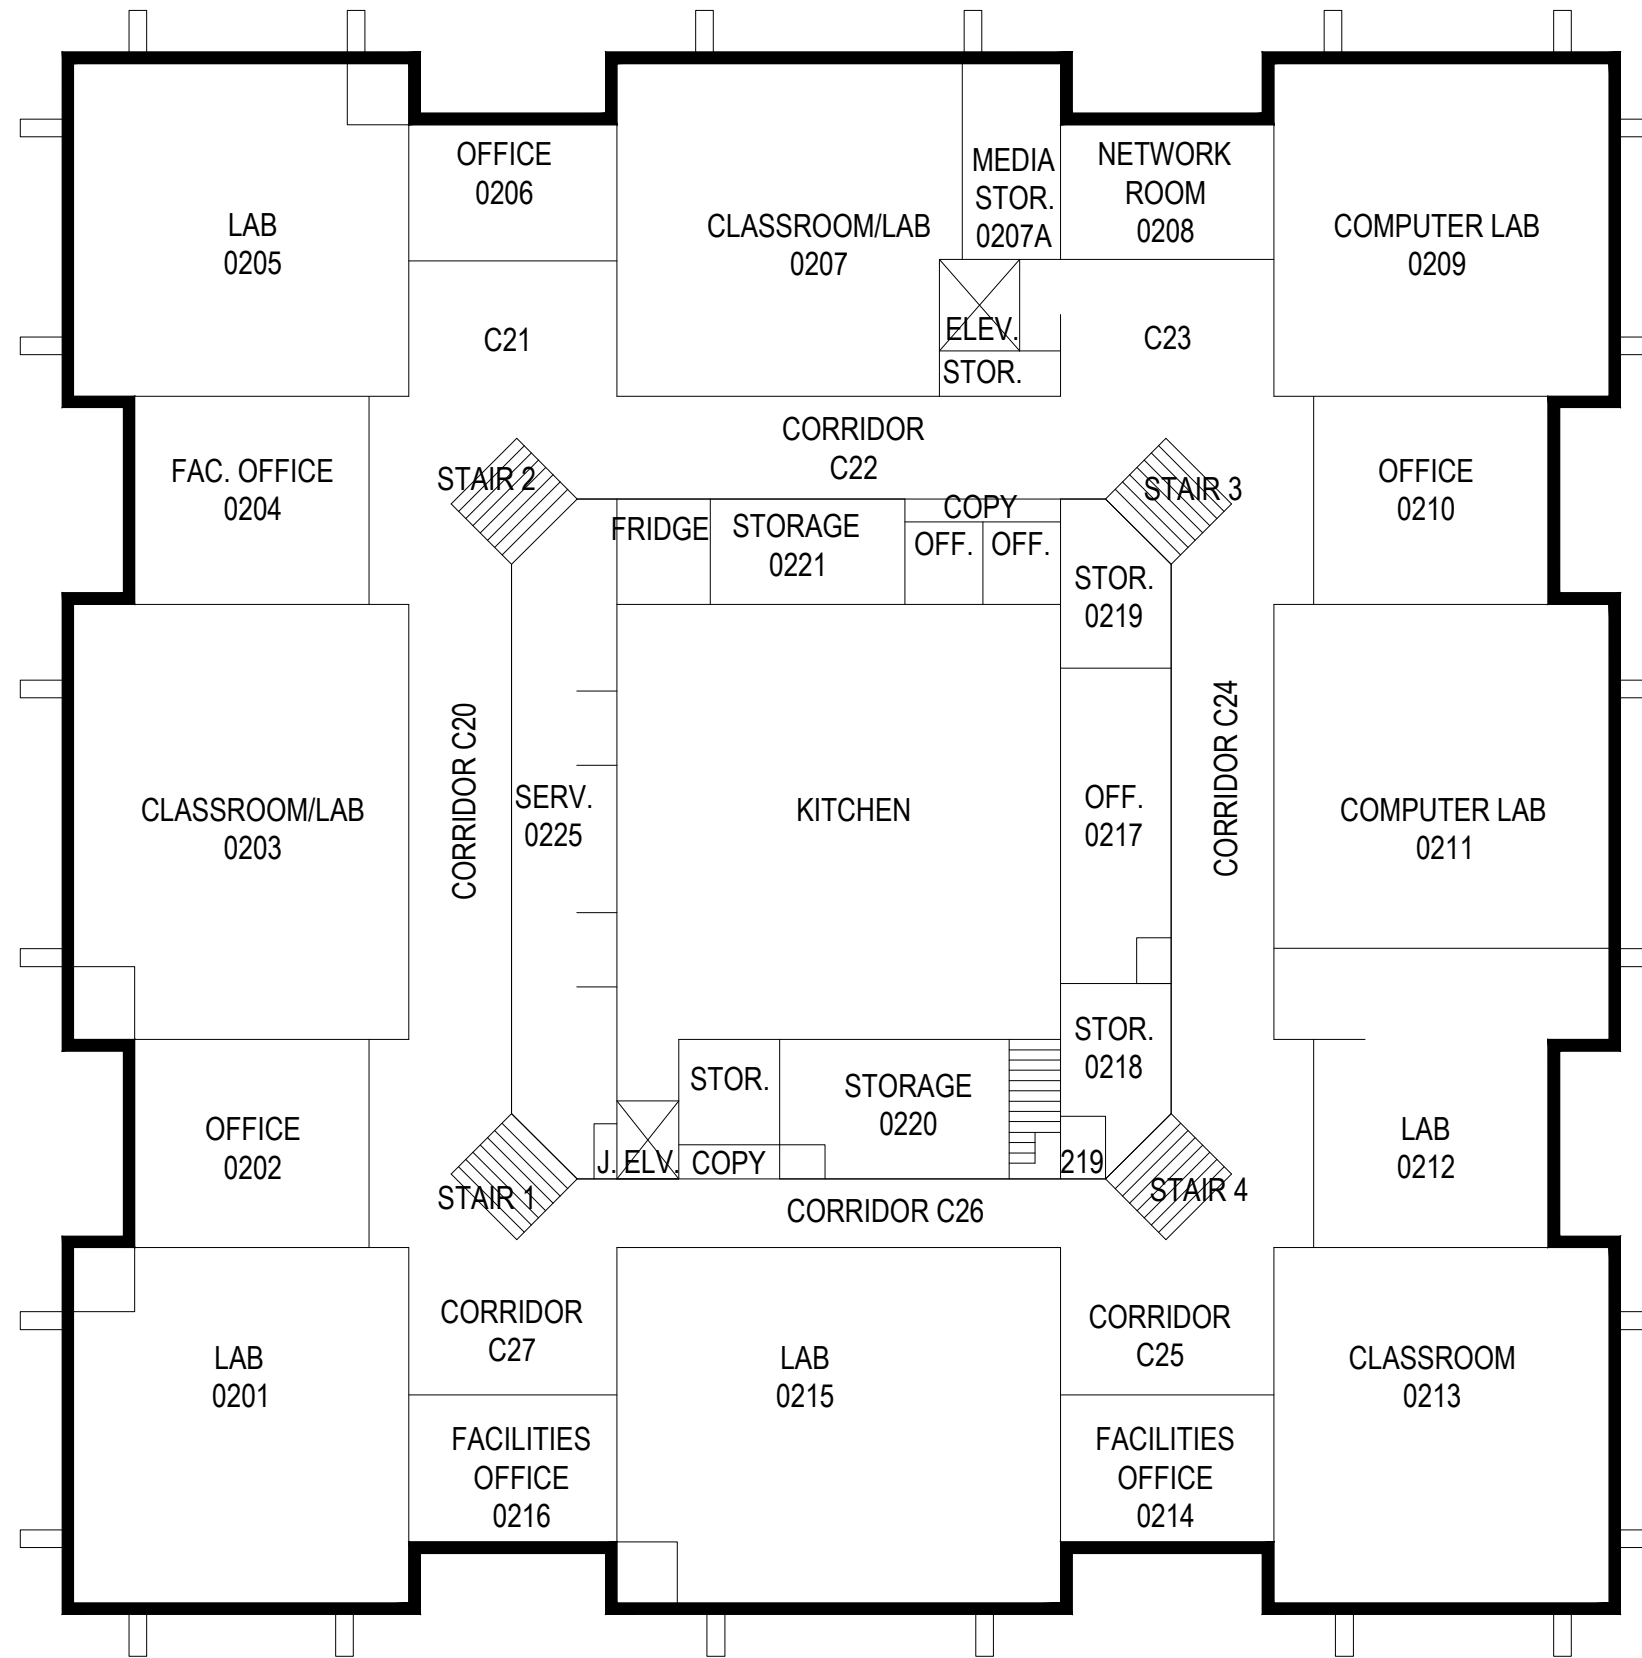

SECOND FLOOR PLAN



CLIENT

Farmingdale State College

SCALE:

1/16"=1'-0"

DATE:


JUNE-2015

Sinclair Hall- 094



architects + engineers

Melville, NY Albany, NY
New City, NY Parsippany, NJ

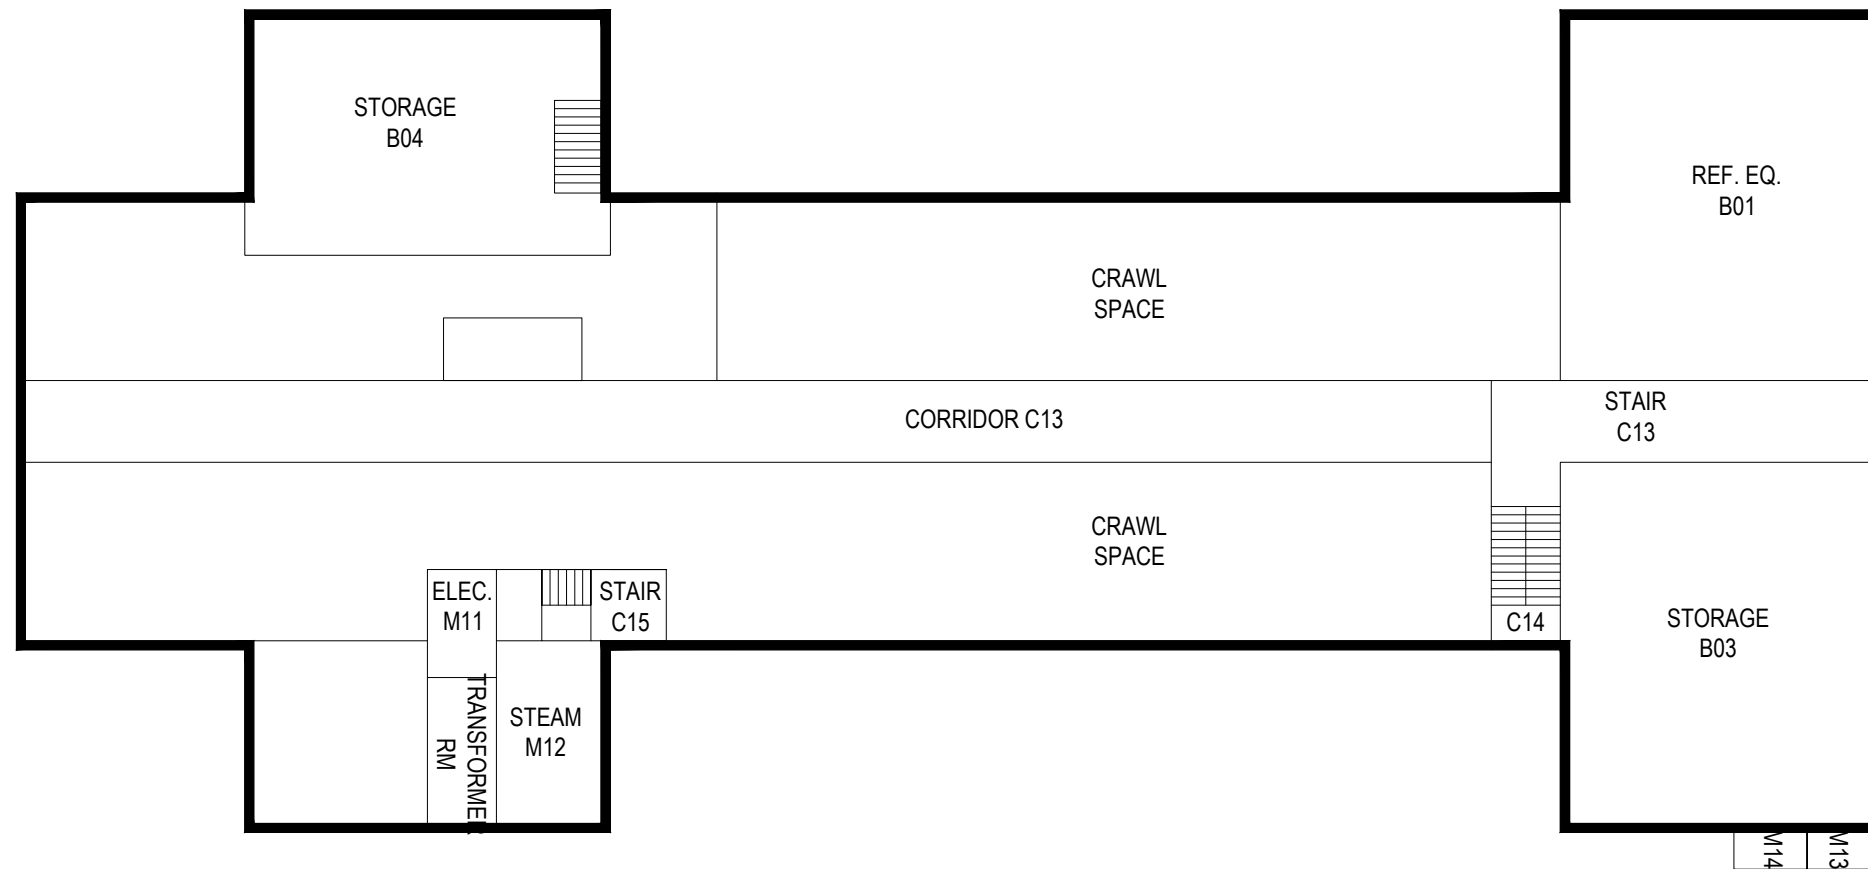

BASEMENT FLOOR PLAN



CLIENT

Farmingdale State College

SCALE:


1"=20'

DATE:

JUNE-2015

Thompson Hall- 041


REF. Drawing
SUFA 15-01

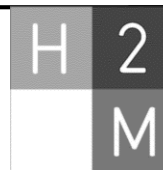

architects + engineers


Melville, NY Albany, NY
New City, NY Parsippany, NJ

43

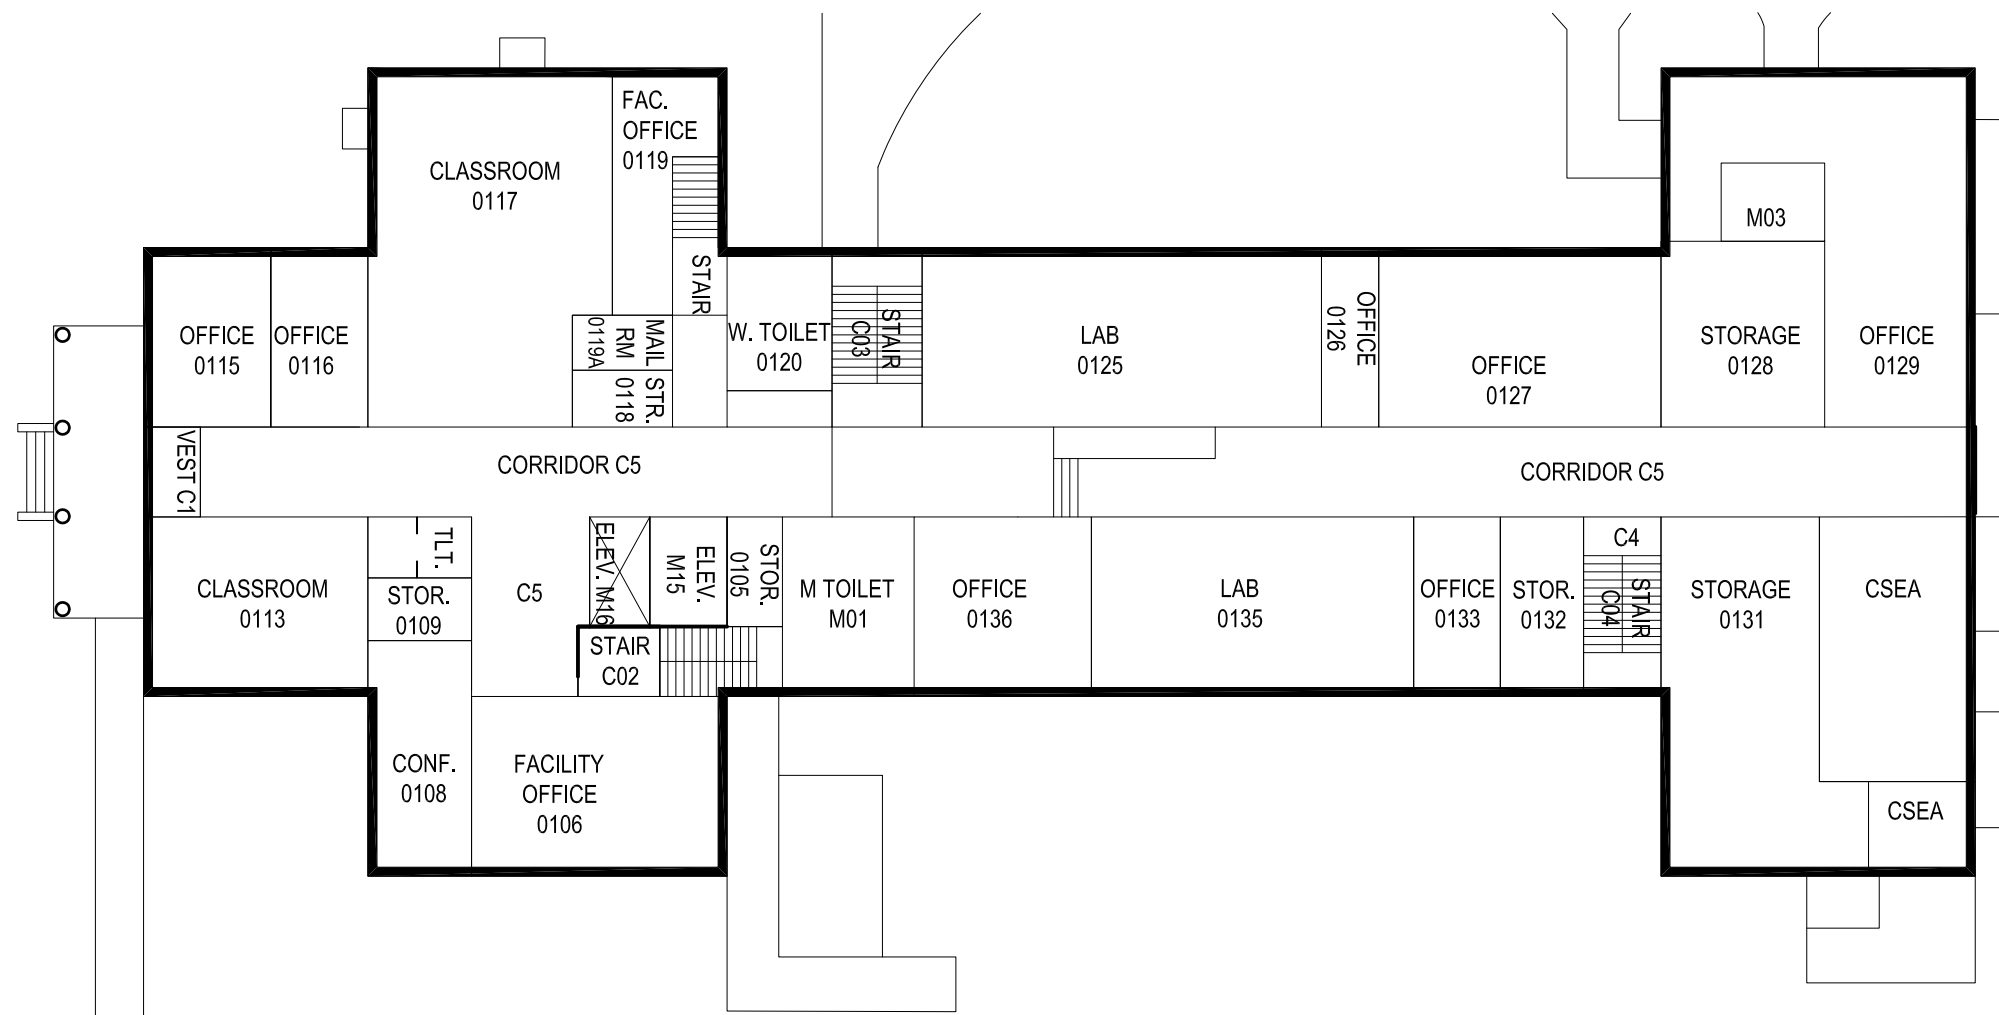

FIRST FLOOR PLAN



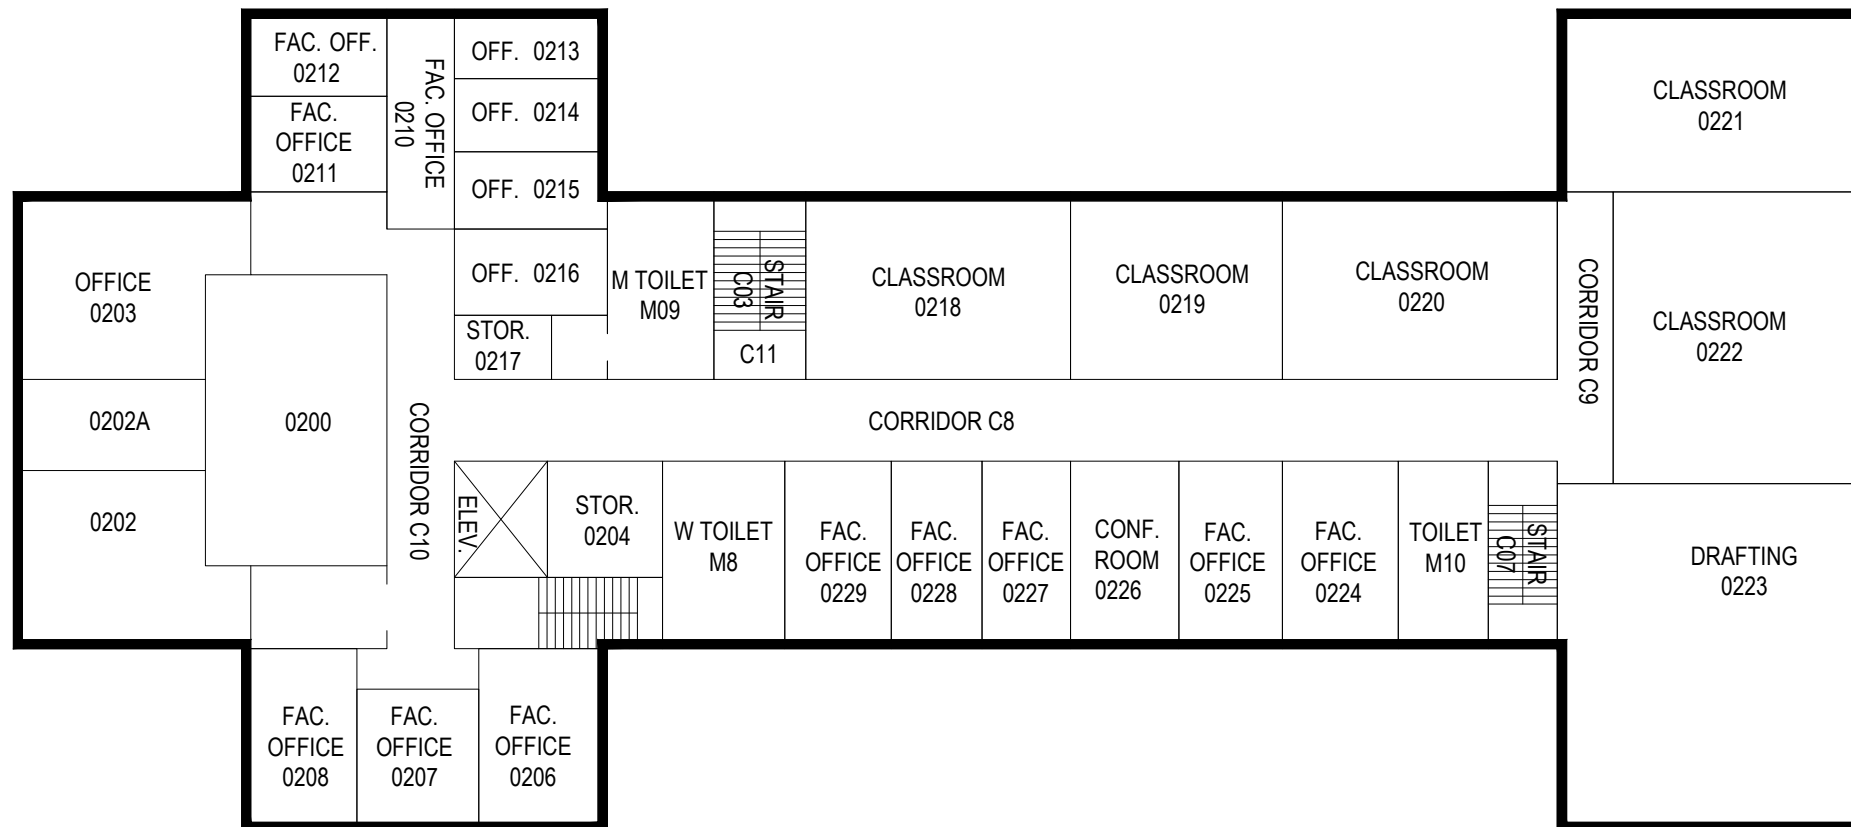

SECOND FLOOR PLAN



CLIENT

Farmingdale State College


SCALE:

1"=20'

DATE:

JUNE-2015

Thompson Hall- 041

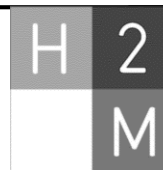

architects + engineers

Melville, NY Albany, NY
New City, NY Parsippany, NJ



BASEMENT FLOOR PLAN



CLIENT

Farmingdale State College

SCALE:

1"=30'

DATE:

JUNE-2015

Whitman Hall- 050

REF. Drawing
SUFA 15-01

H	2	architects + engineers Melville, NY Albany, NY New City, NY Parsippany, NJ
M	M	



FIRST FLOOR PLAN



CLIENT

Farmingdale State College

SCALE:

1"=30'


DATE:

JUNE-2015

Whitman Hall- 050

REF. Drawing
SUFA 15-01

H	2	M	architects + engineers
			Melville, NY Albany, NY New City, NY Parsippany, NJ

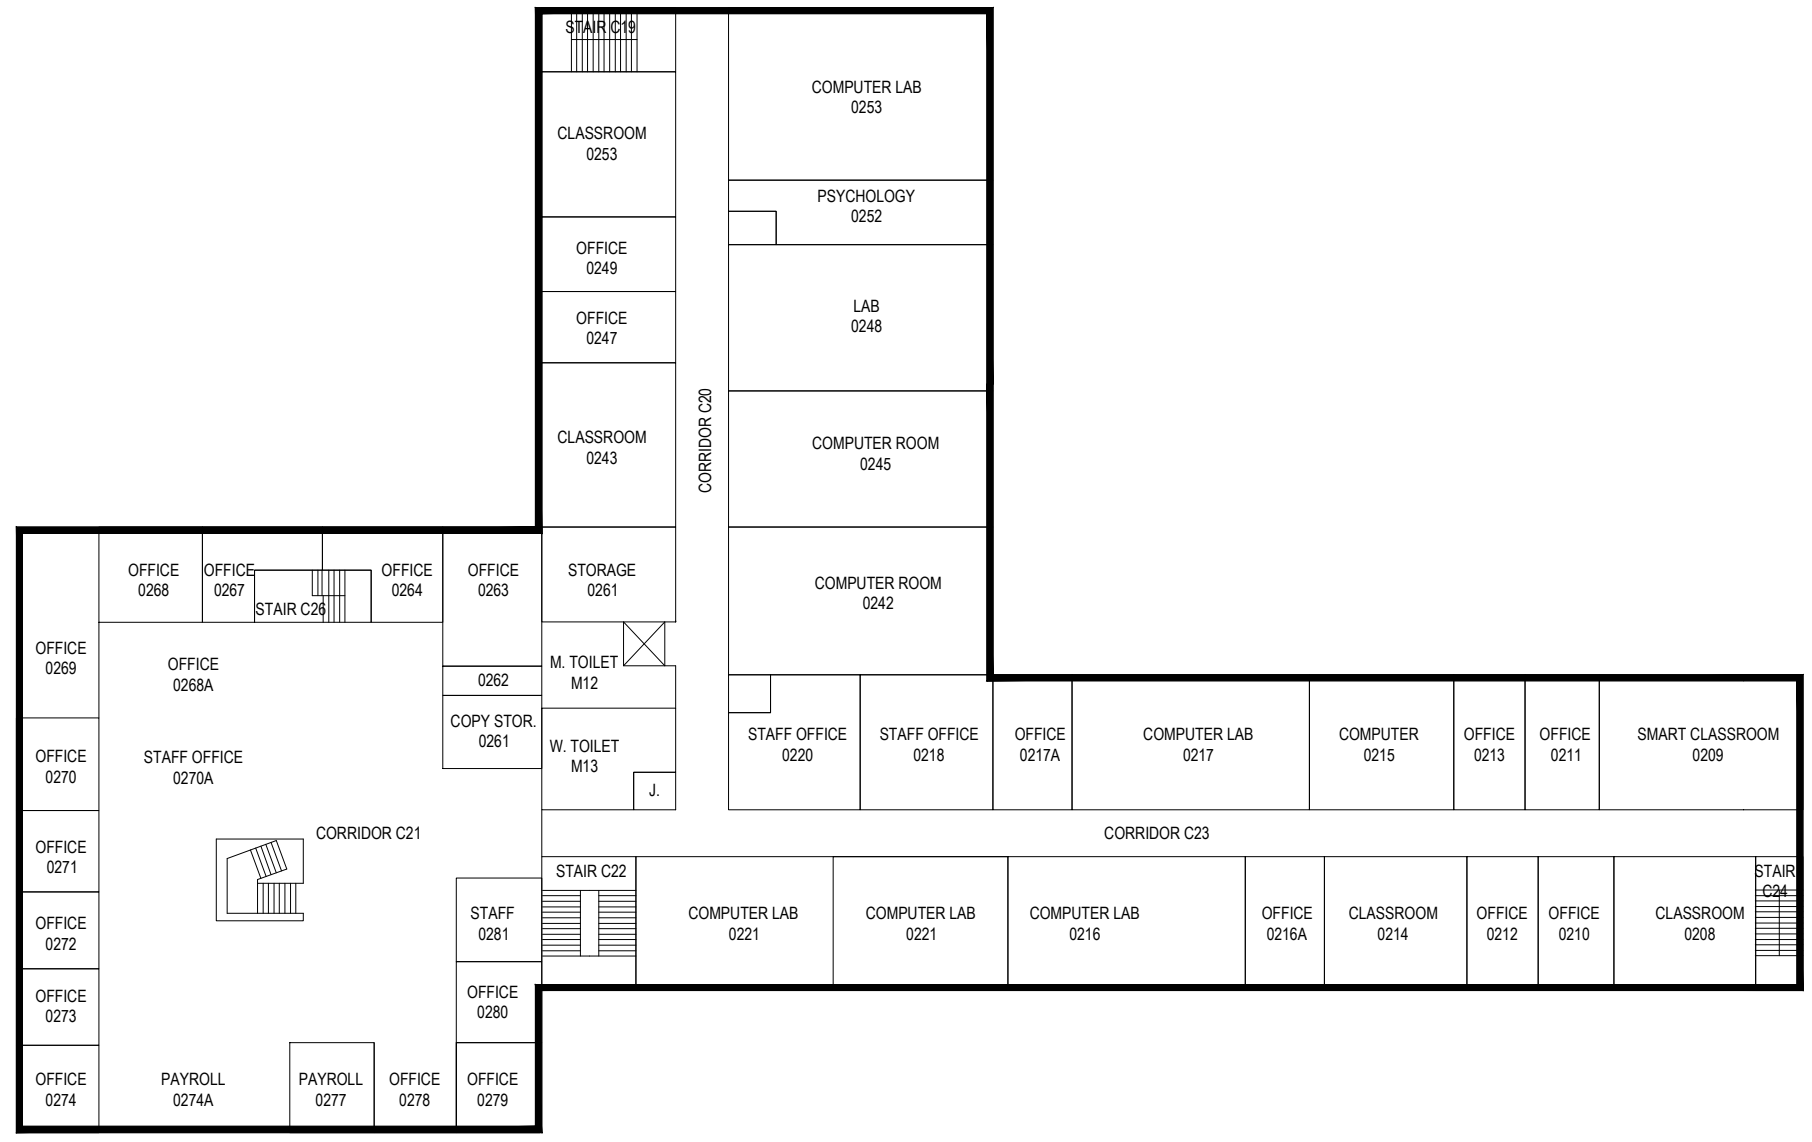

SECOND FLOOR PLAN



CLIENT

Farmingdale State College

SCALE:

1"=20'

DATE:


JUNE-2015

Whitman Hall- 050




architects + engineers

Melville, NY Albany, NY
New City, NY Parsippany, NJ

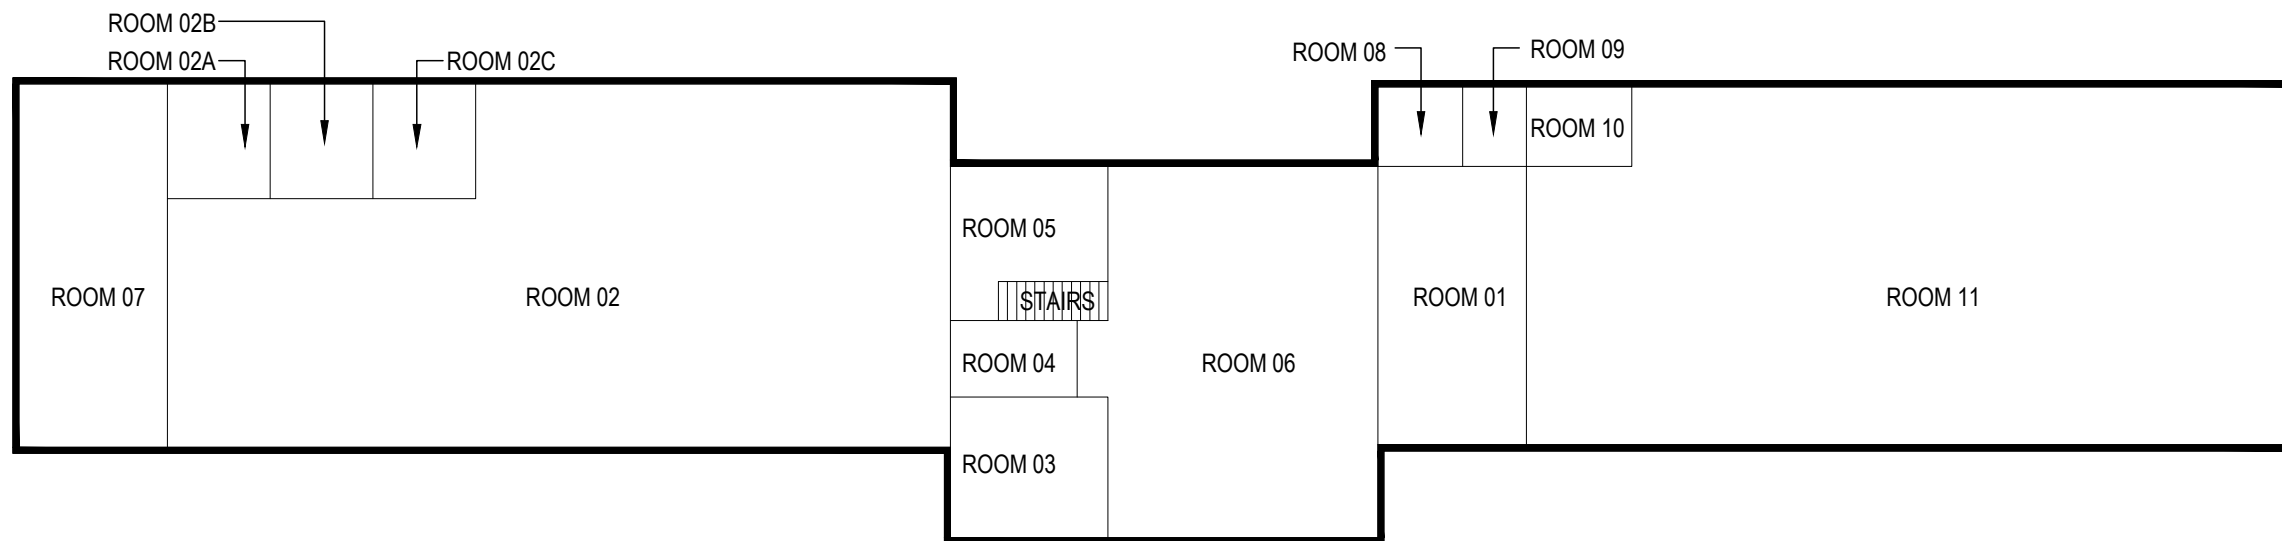

FIRST FLOOR PLAN

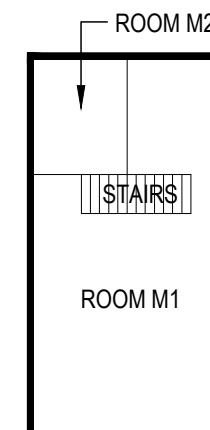

MEZZANINE FLOOR PLAN



CLIENT

Farmingdale State College

SCALE:

1"=20'

DATE:

JUNE-2015


AG Service Building - 075



architects + engineers

Melville, NY Albany, NY
New City, NY Parsippany, NJ

49

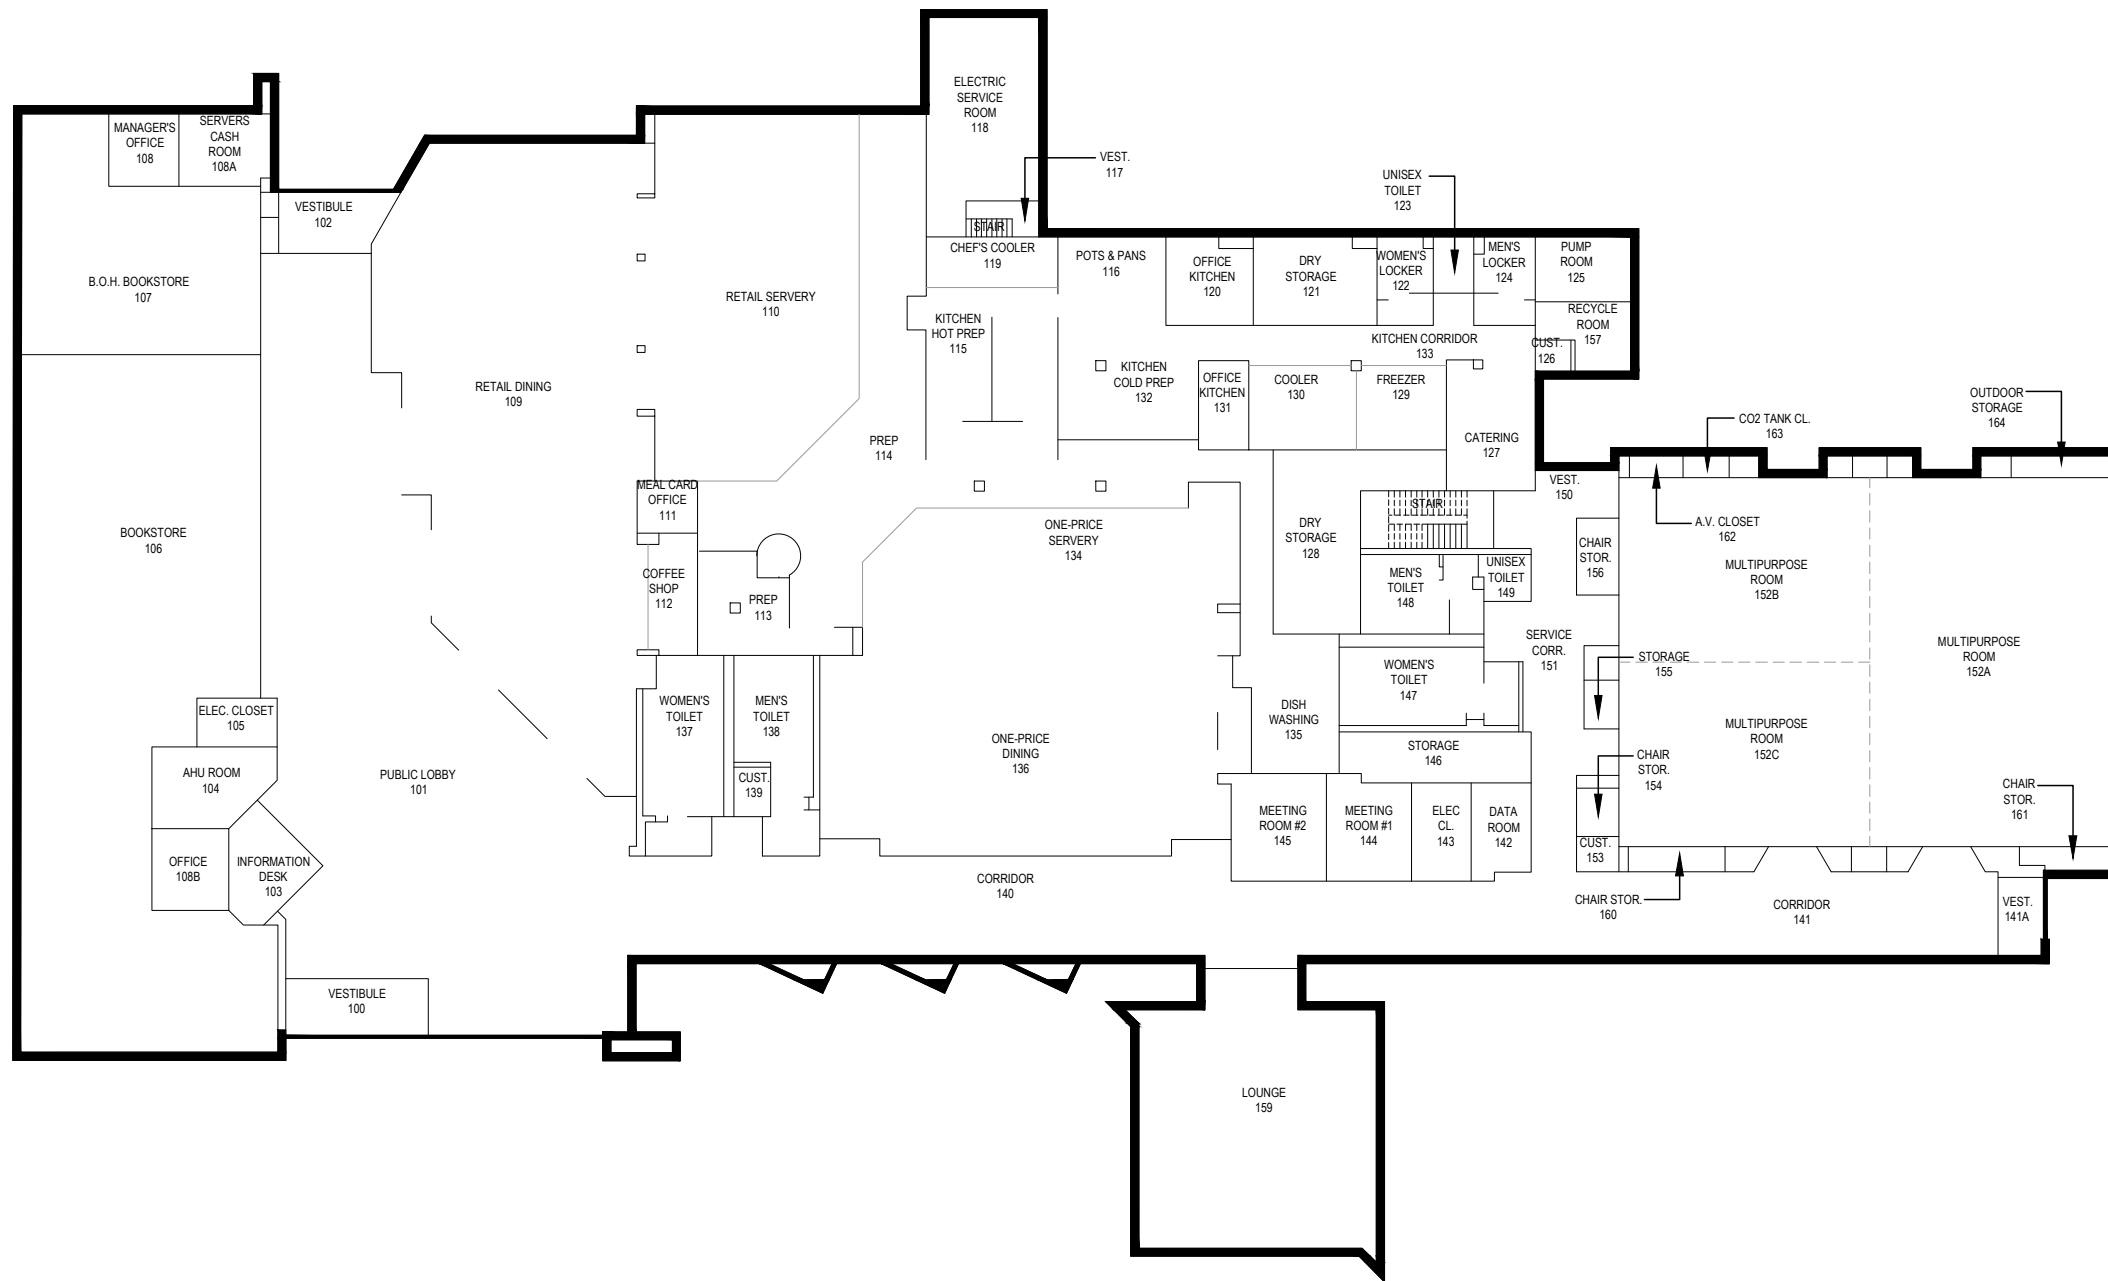

FIRST FLOOR PLAN



CLIENT

Farmingdale State College

SCALE:

1"=20'

DATE:

JUNE-2015


Campus Center - 008



architects + engineers

Melville, NY Albany, NY
New City, NY Parsippany, NJ

50

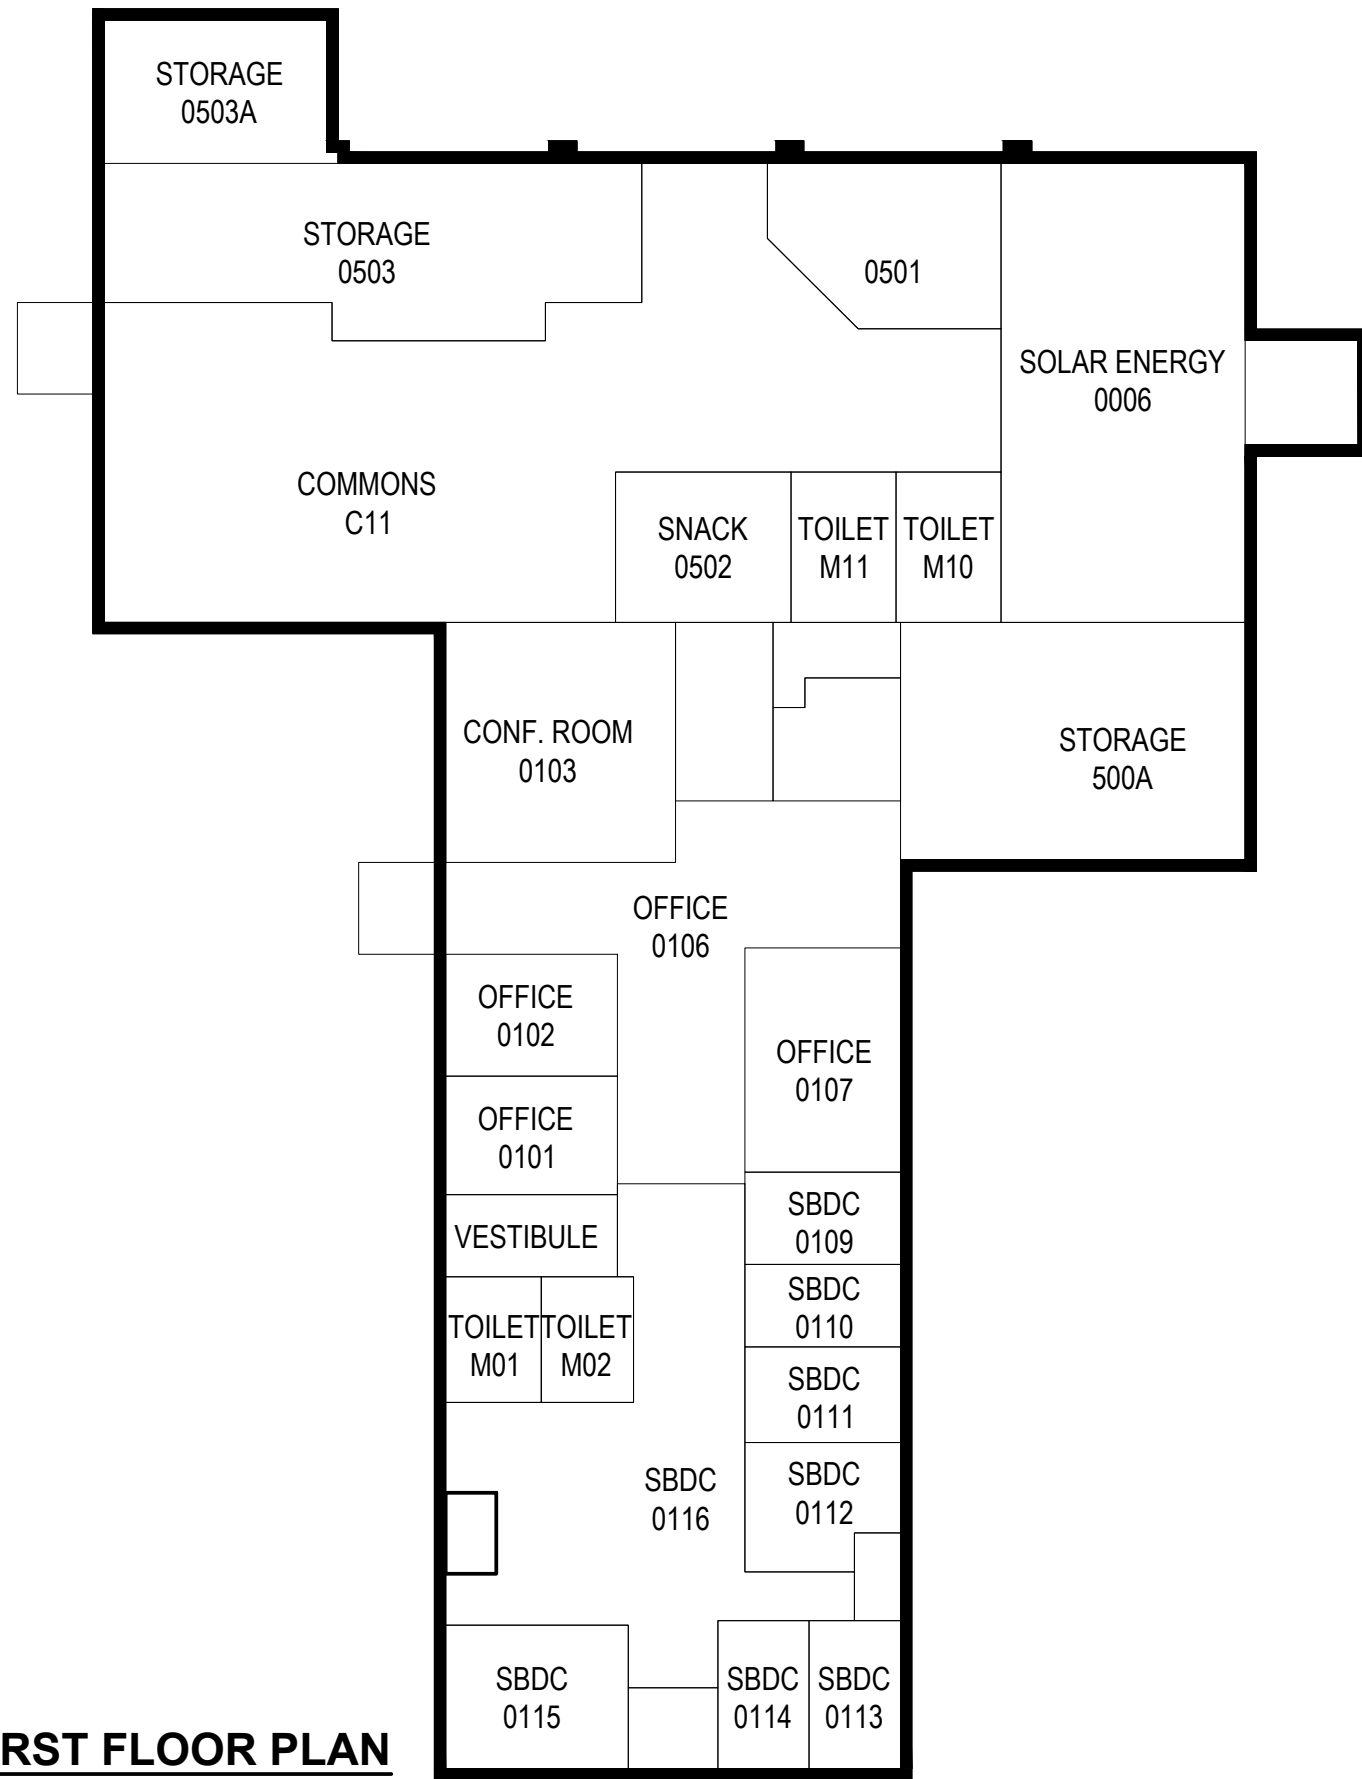

FIRST FLOOR PLAN



CLIENT

Farmingdale State College

SCALE:

1"=30'

DATE:


JUNE-2015

Campus Commons - 06



architects + engineers

Melville, NY Albany, NY
New City, NY Parsippany, NJ

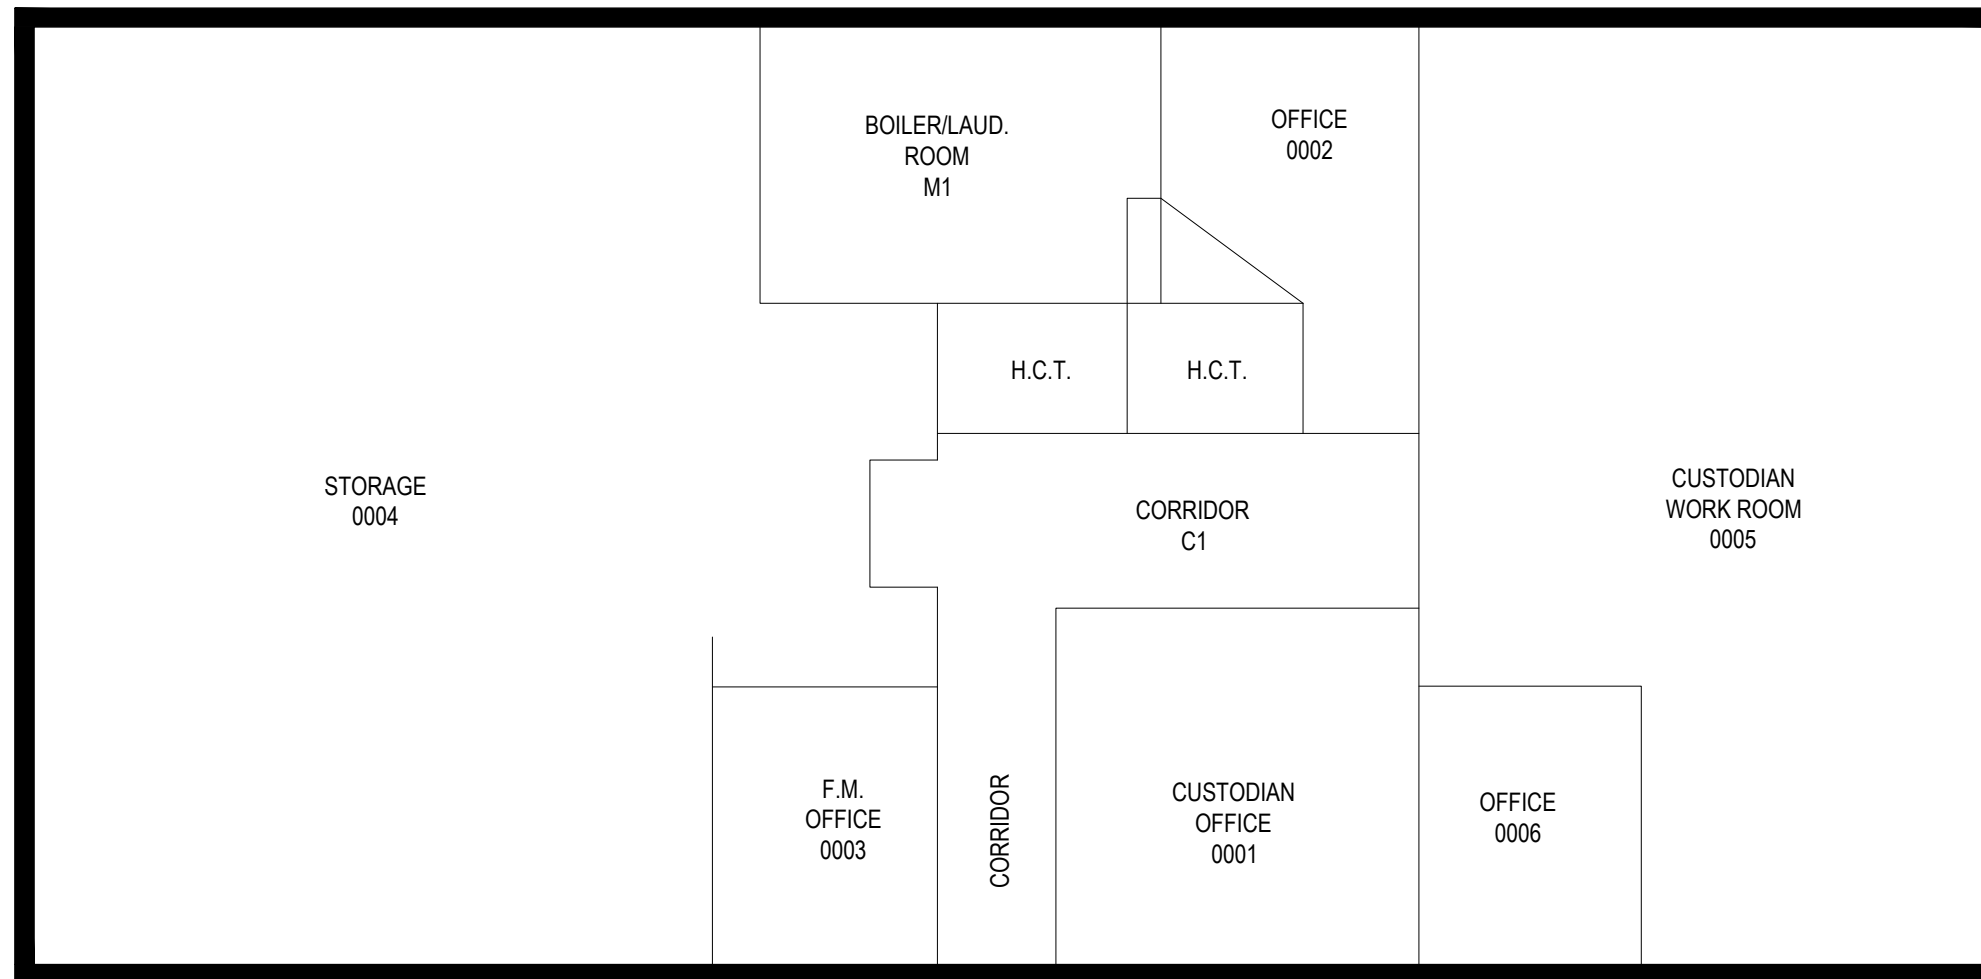

FIRST FLOOR PLAN

CLIENT

Farmingdale State College

SCALE:

1/8"=1'-0"

DATE:


JUNE-2015

CCI Building- 078



architects + engineers

Melville, NY Albany, NY
New City, NY Parsippany, NJ

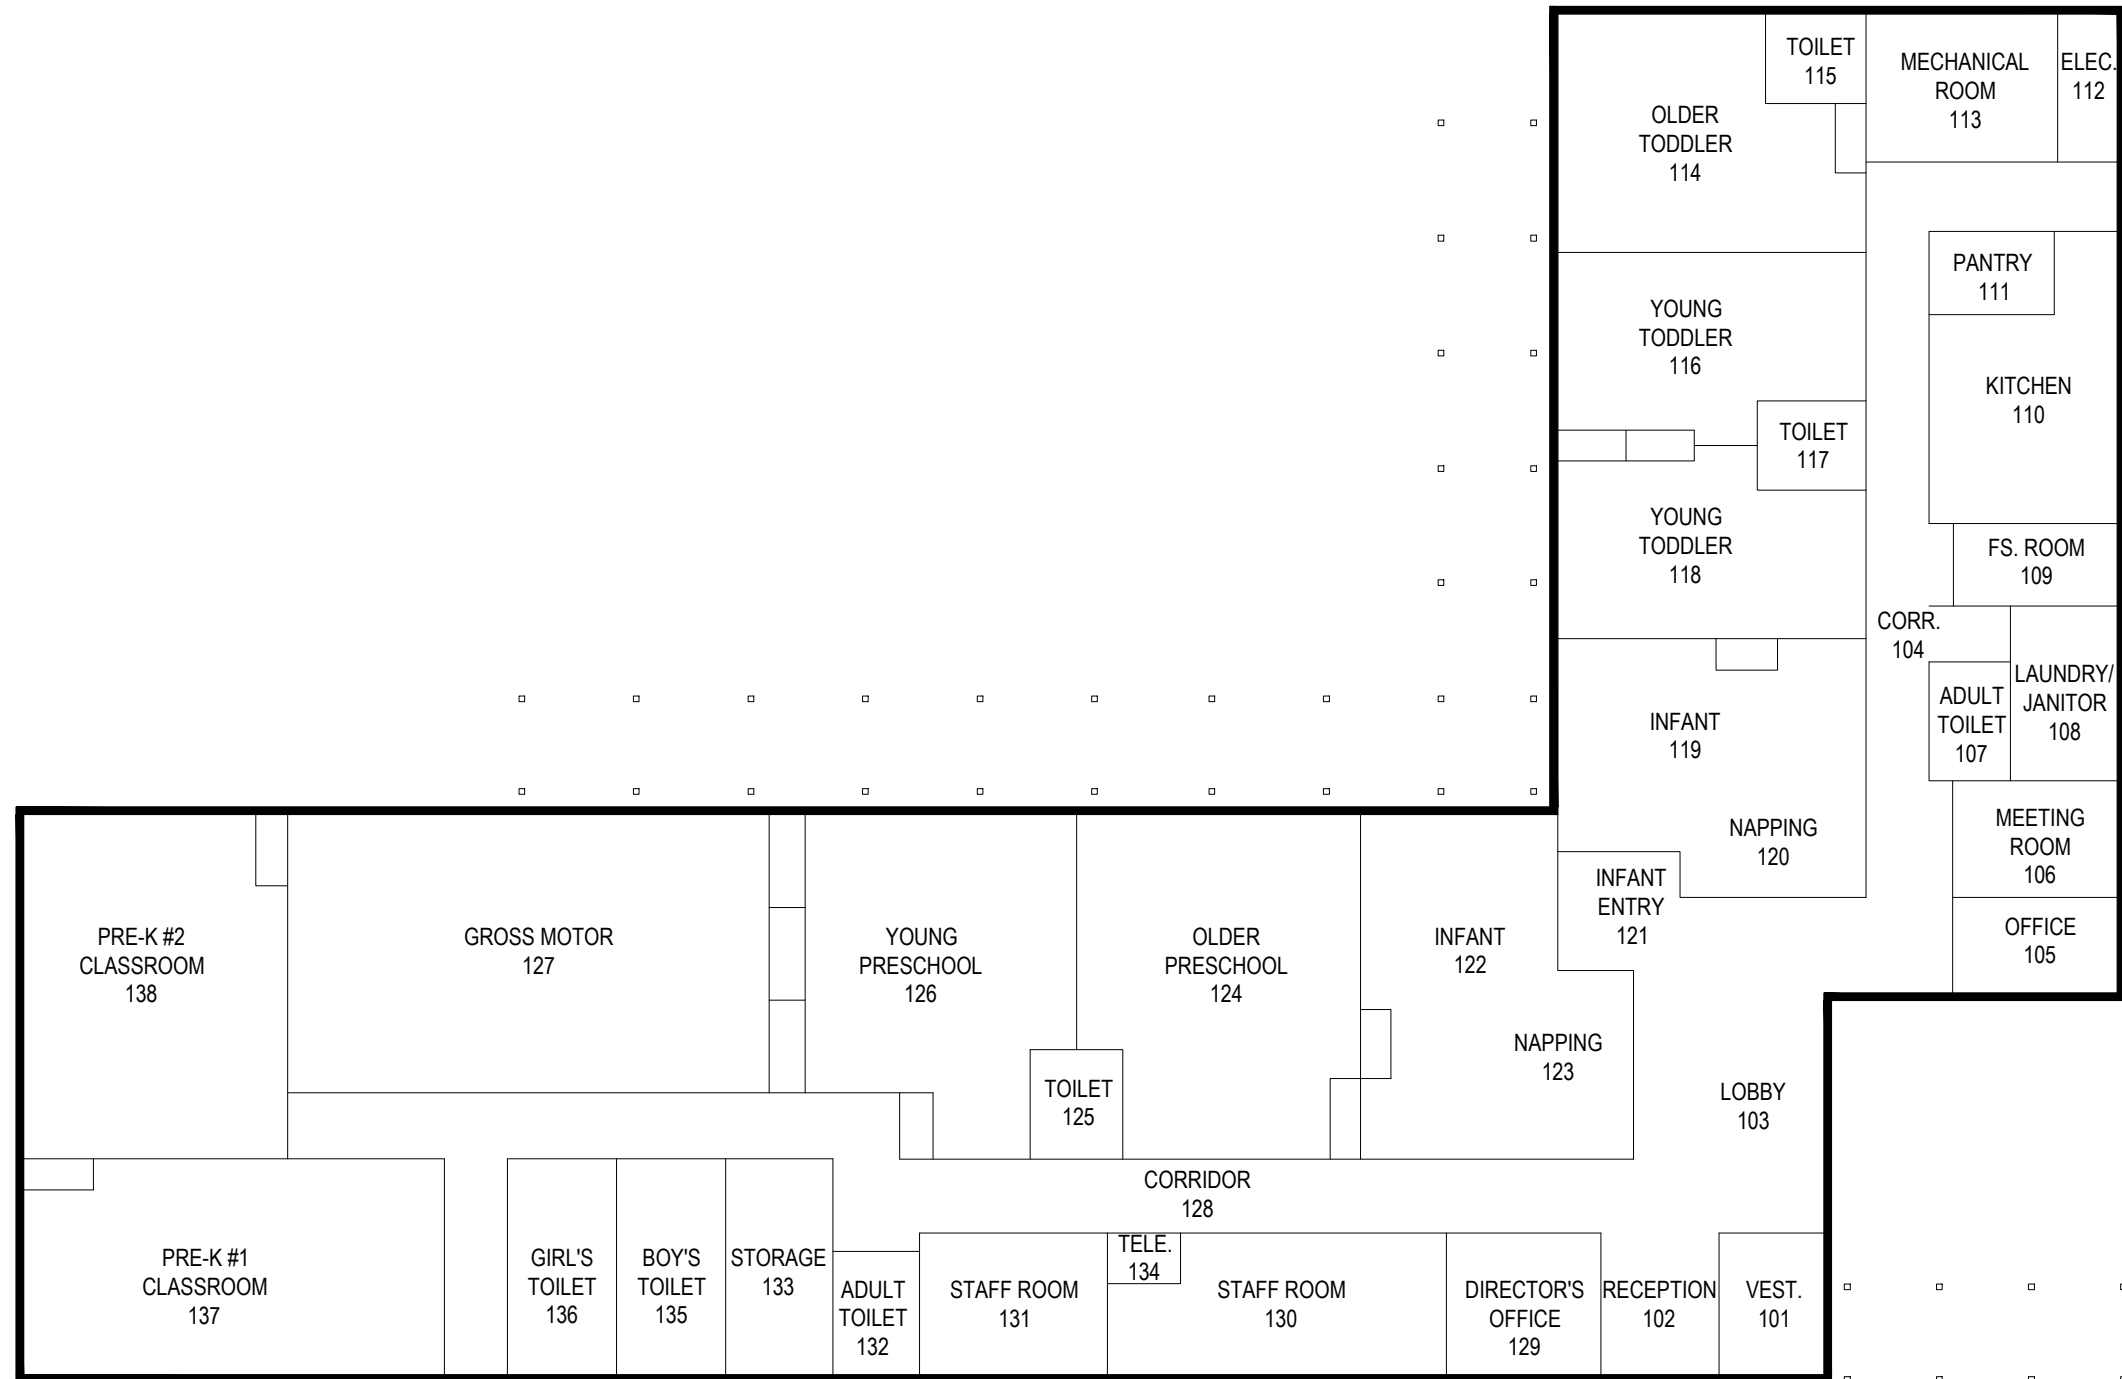

FIRST FLOOR PLAN

 


CLIENT
Farmingdale State College

SCALE:
1/16"=1'-0"
 DATE:
JUNE-2015

Day Care Center - 120

H 2 M
 architects + engineers
 Melville, NY Albany, NY
 New City, NY Parsippany, NJ



ROOM 01

FIRST FLOOR PLAN

CLIENT

Farmingdale State College


SCALE:

1"=20'

DATE:


JUNE-2015

Hay Barn - 079

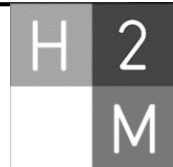

architects + engineers

Melville, NY Albany, NY
New City, NY Parsippany, NJ

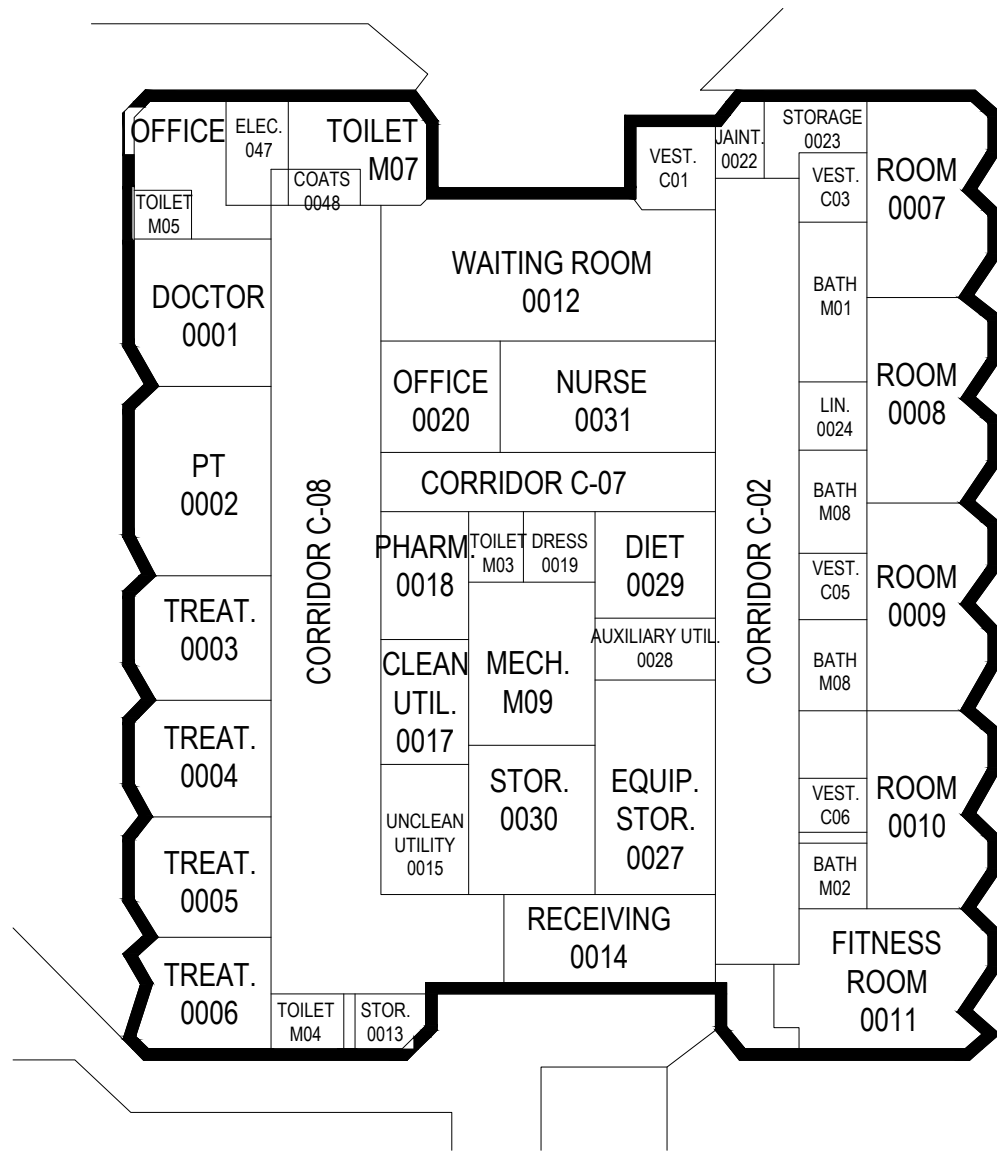

FIRST FLOOR PLAN




CLIENT

Farmingdale State College

SCALE:
1/16"=1'-0"
DATE:
JUNE-2015

Health & Wellness Center - 089

H	2	architects + engineers
M	M	
Melville, NY Albany, NY New City, NY Parsippany, NJ		

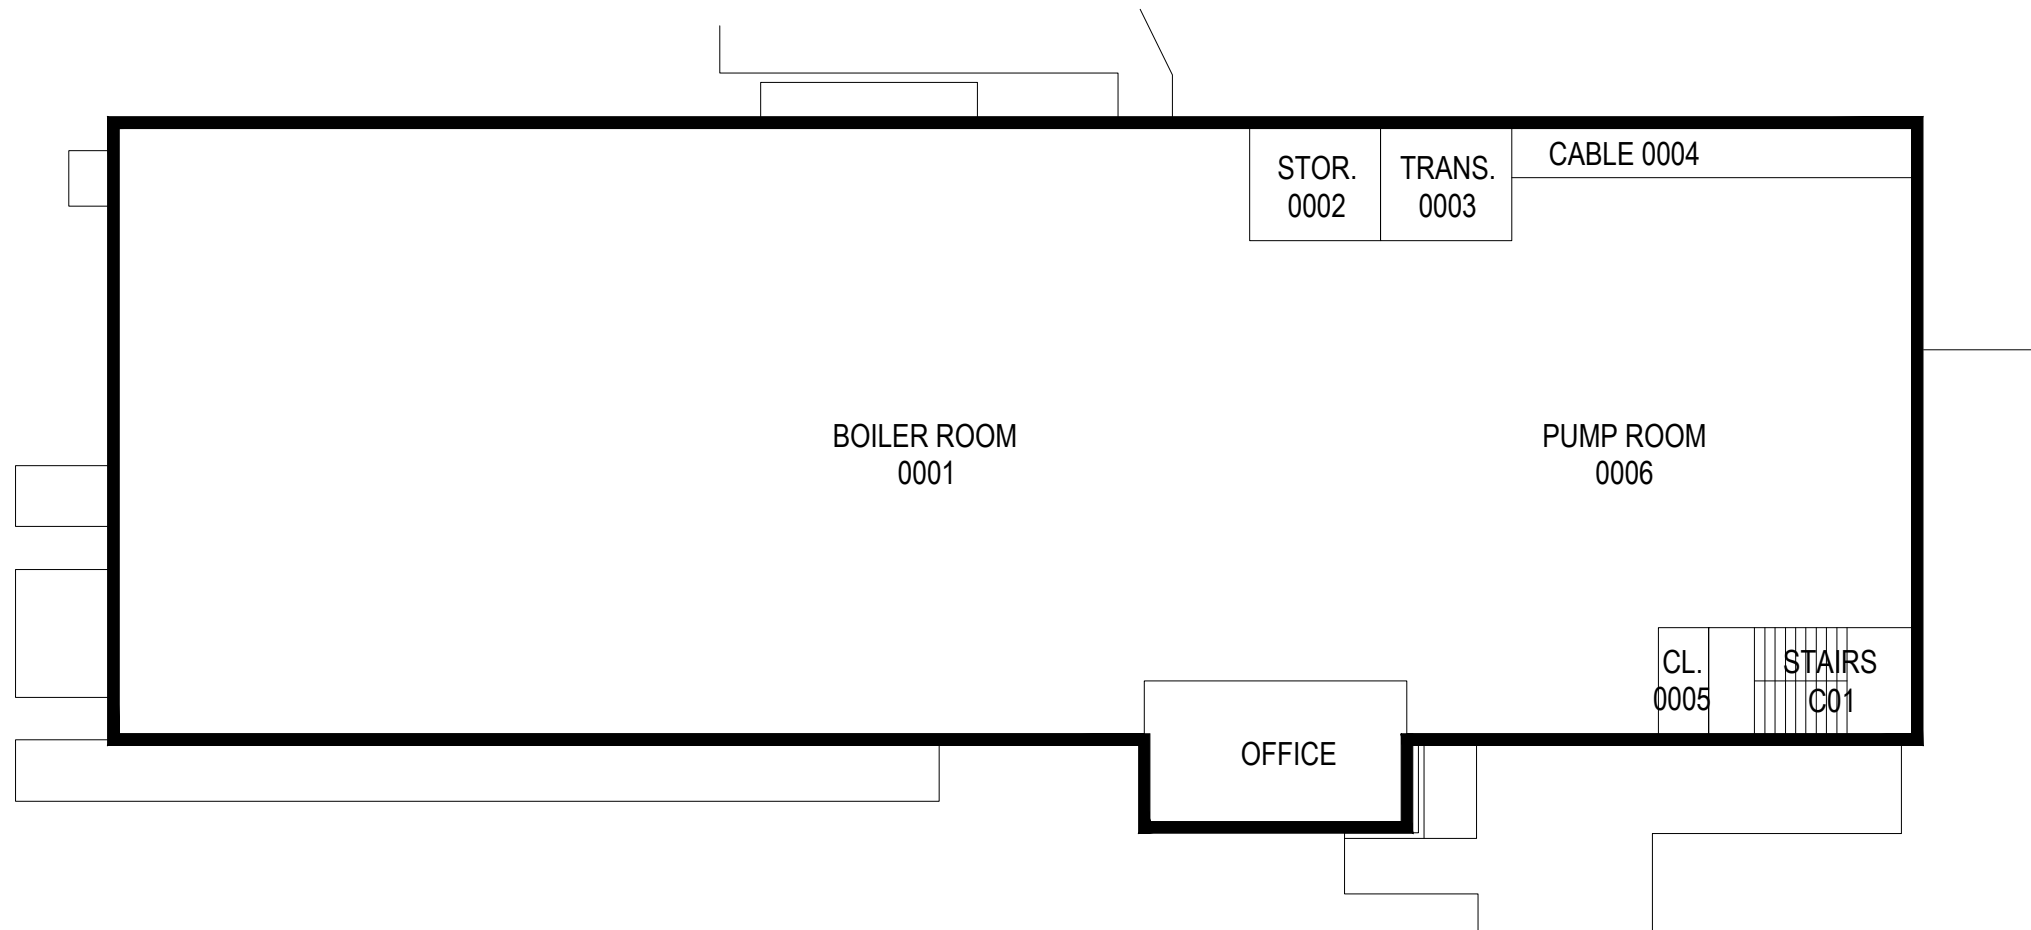

FIRST FLOOR PLAN



CLIENT

Farmingdale State College

SCALE:

1/16"=1'-0"

DATE:

JUNE-2015


Heating Plant - 071




architects + engineers

Melville, NY Albany, NY
New City, NY Parsippany, NJ

56

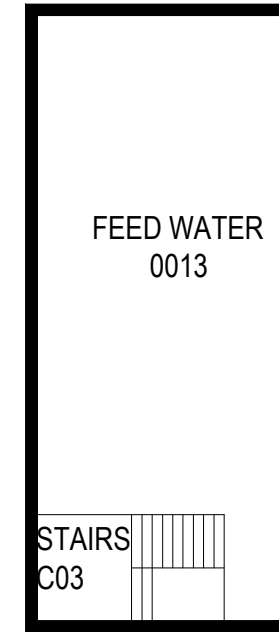

THIRD FLOOR PLAN

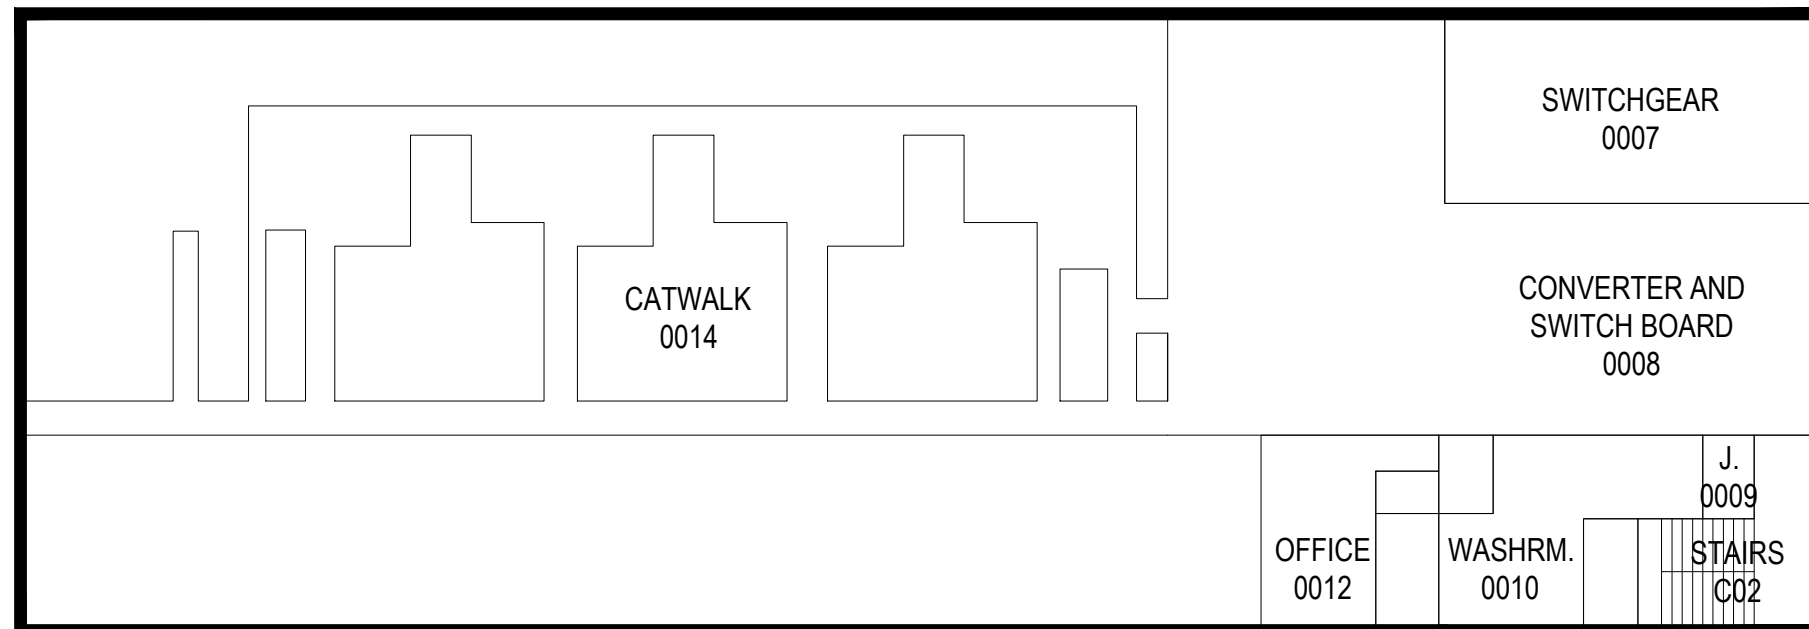

SECOND FLOOR PLAN



CLIENT

Farmingdale State College

SCALE:

1/16"=1'-0"

DATE:


JUNE-2015

Heating Plant - 071



architects + engineers

Melville, NY Albany, NY
New City, NY Parsippany, NJ

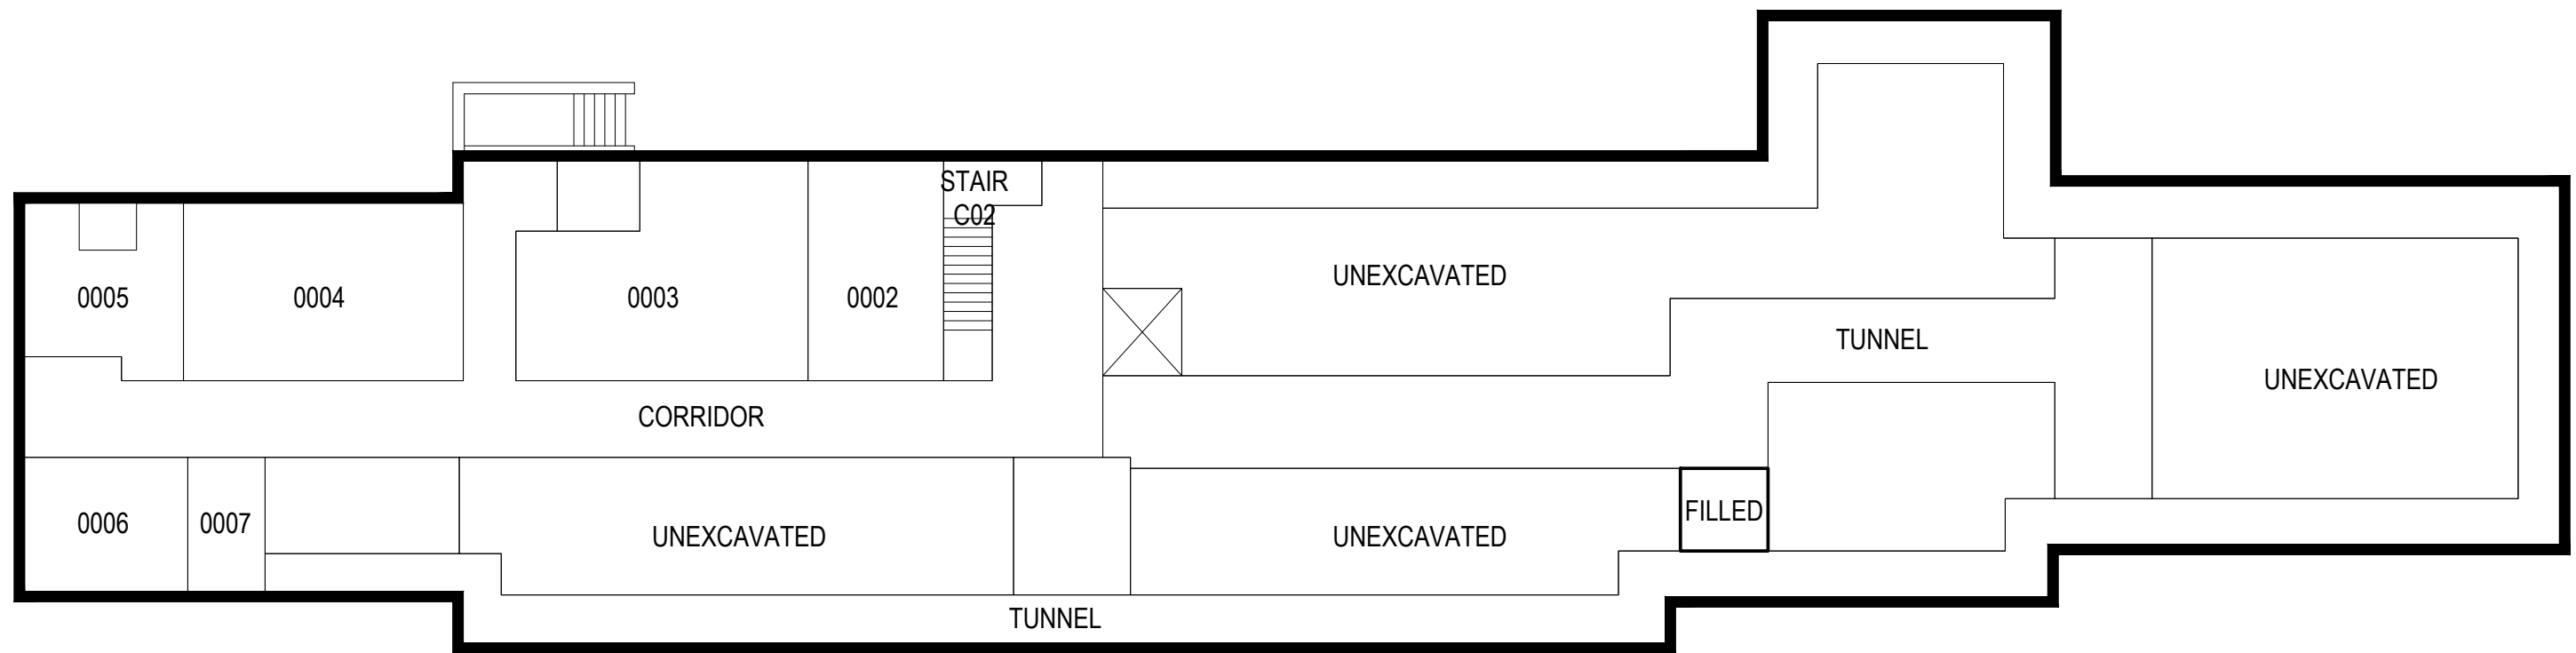

BASEMENT FLOOR PLAN



CLIENT

Farmingdale State College


SCALE:

1/16"=1'-0"

DATE:

JUNE-2015


Horton Hall - 054

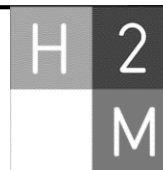

architects + engineers

Melville, NY Albany, NY
New City, NY Parsippany, NJ

58

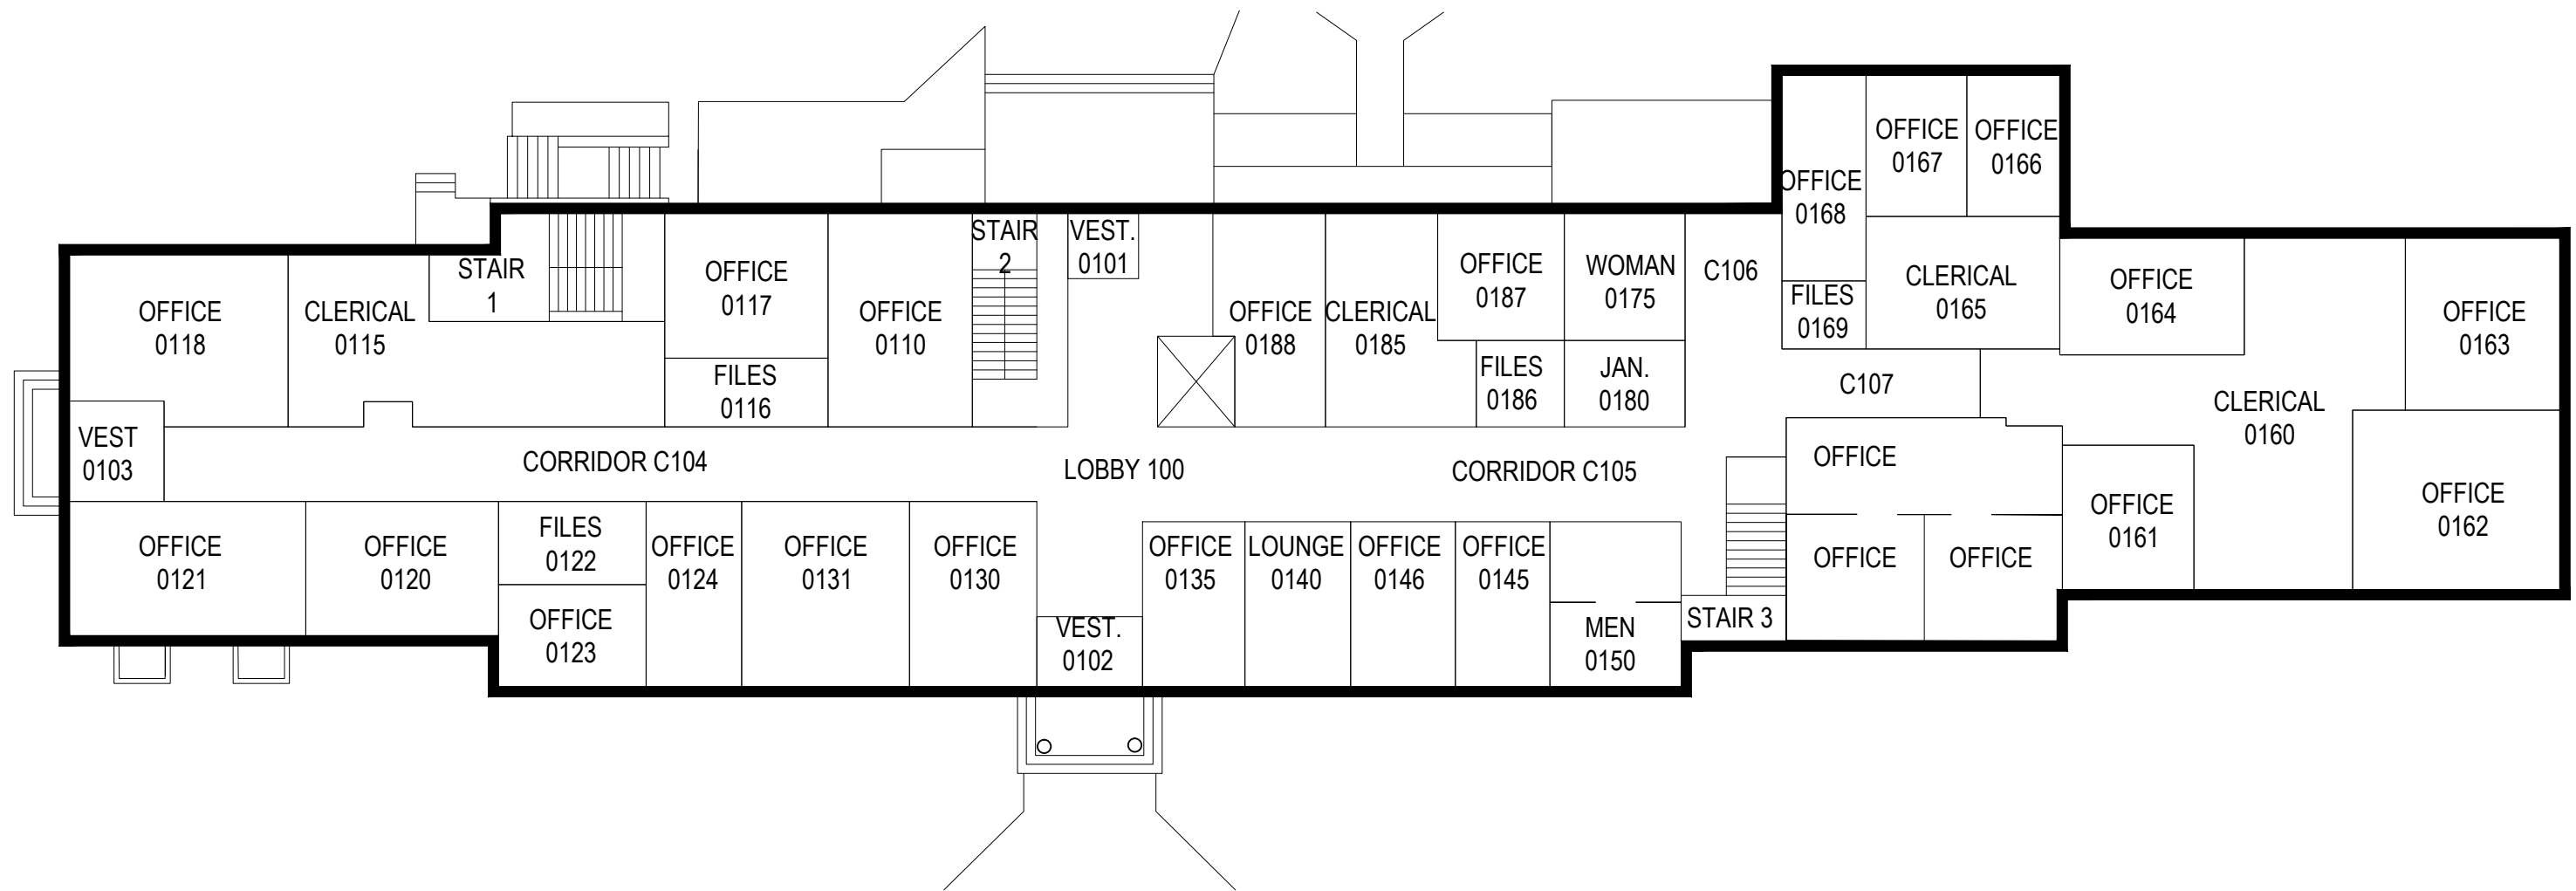

FIRST FLOOR PLAN

CLIENT

Farmingdale State College

SCALE:

1/16"=1'-0"

DATE:

JUNE-2015


Horton Hall - 054



architects + engineers

Melville, NY Albany, NY
New City, NY Parsippany, NJ



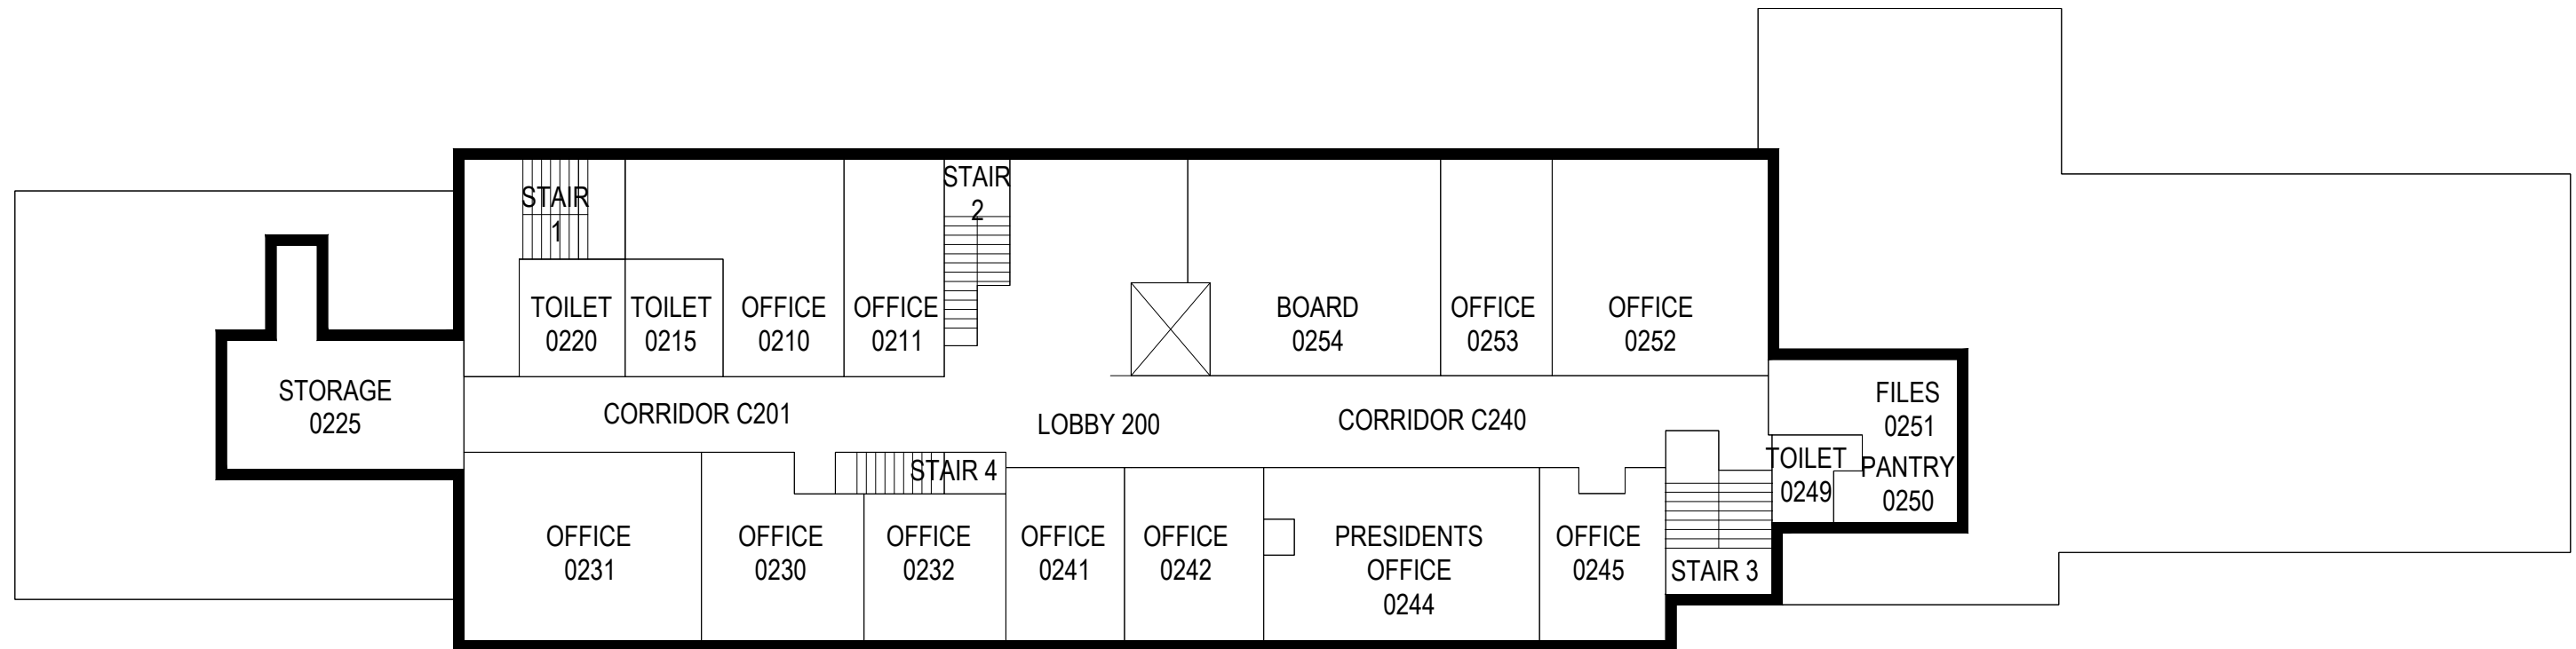

SECOND FLOOR PLAN



CLIENT

Farmingdale State College


SCALE:

1/16"=1'-0"

DATE:

JUNE-2015


Horton Hall - 054

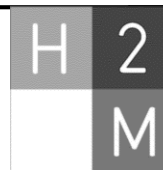

architects + engineers

Melville, NY Albany, NY
New City, NY Parsippany, NJ

60

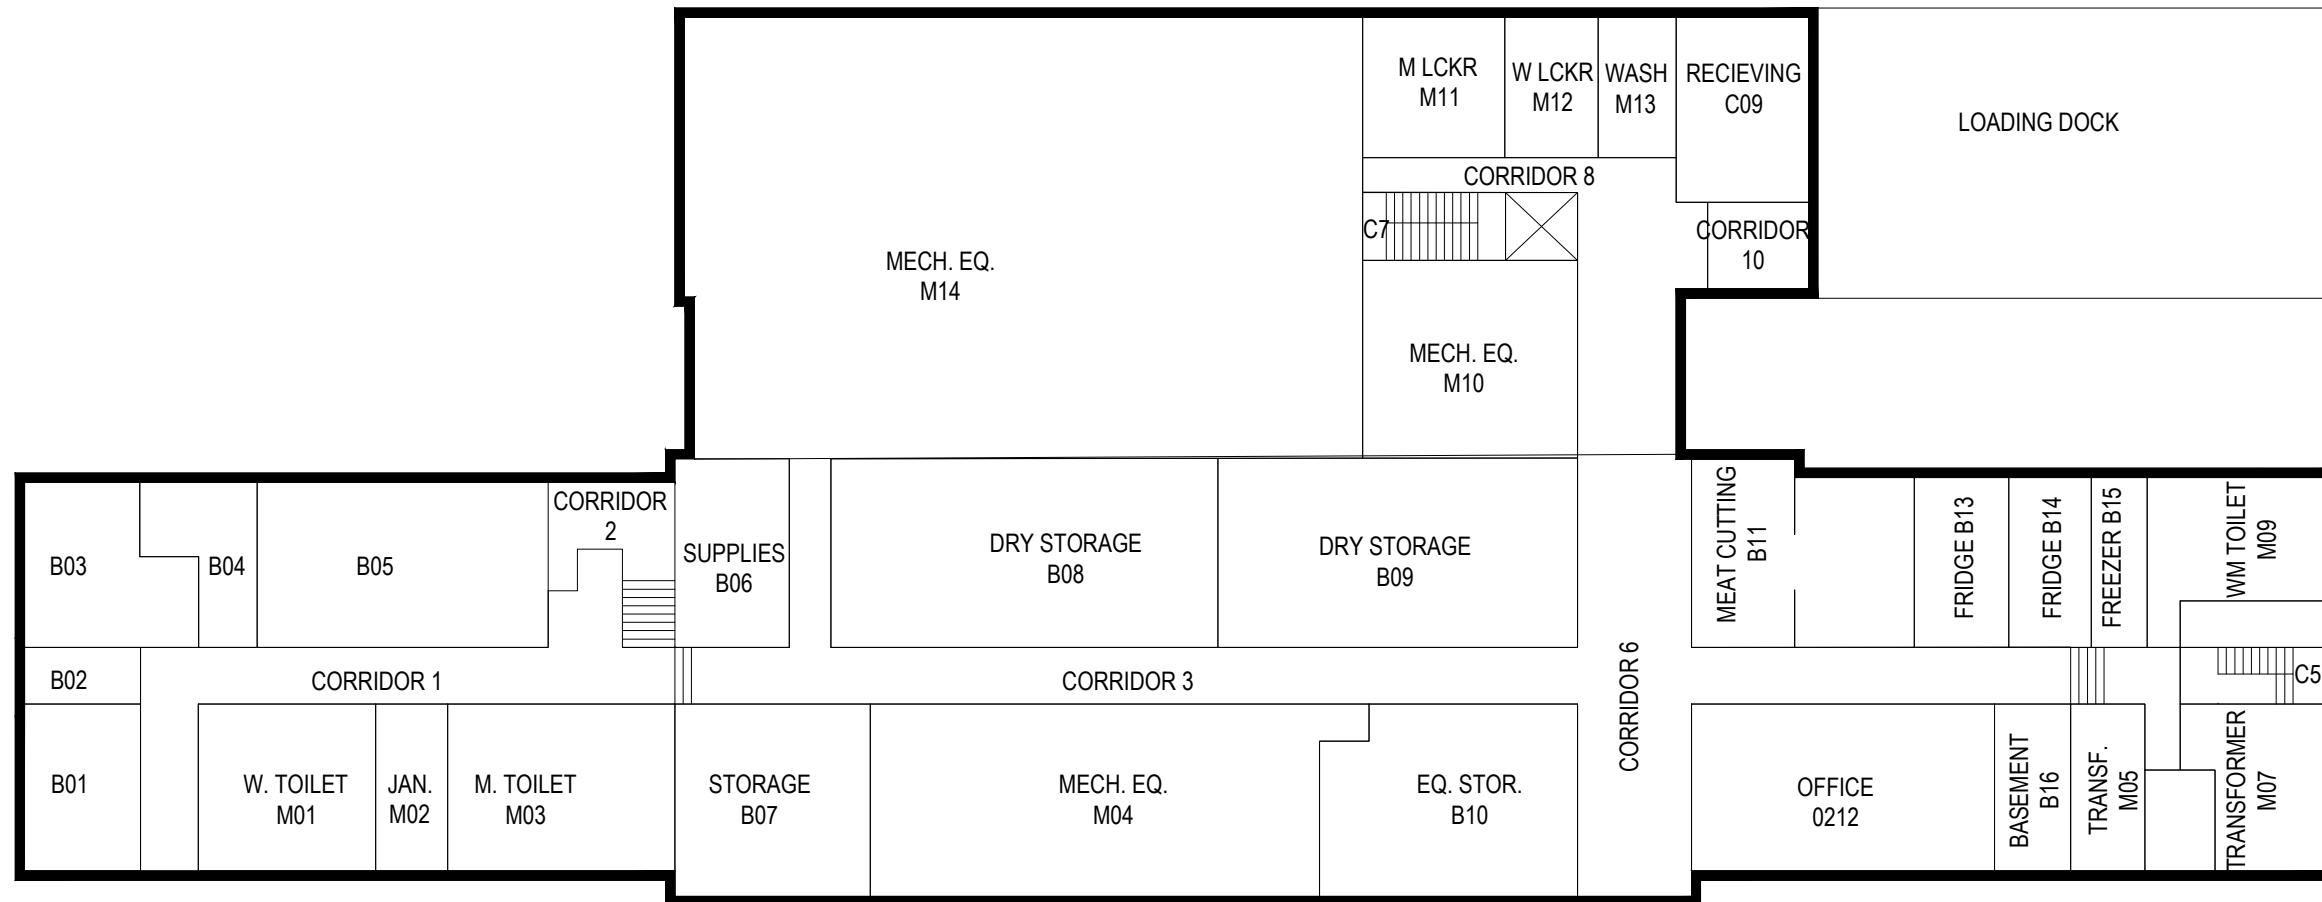

BASEMENT FLOOR PLAN



CLIENT

Farmingdale State College

SCALE:

1/16"=1'-0"

DATE:


JUNE-2015

Knapp Hall - 040



architects + engineers

Melville, NY Albany, NY
New City, NY Parsippany, NJ

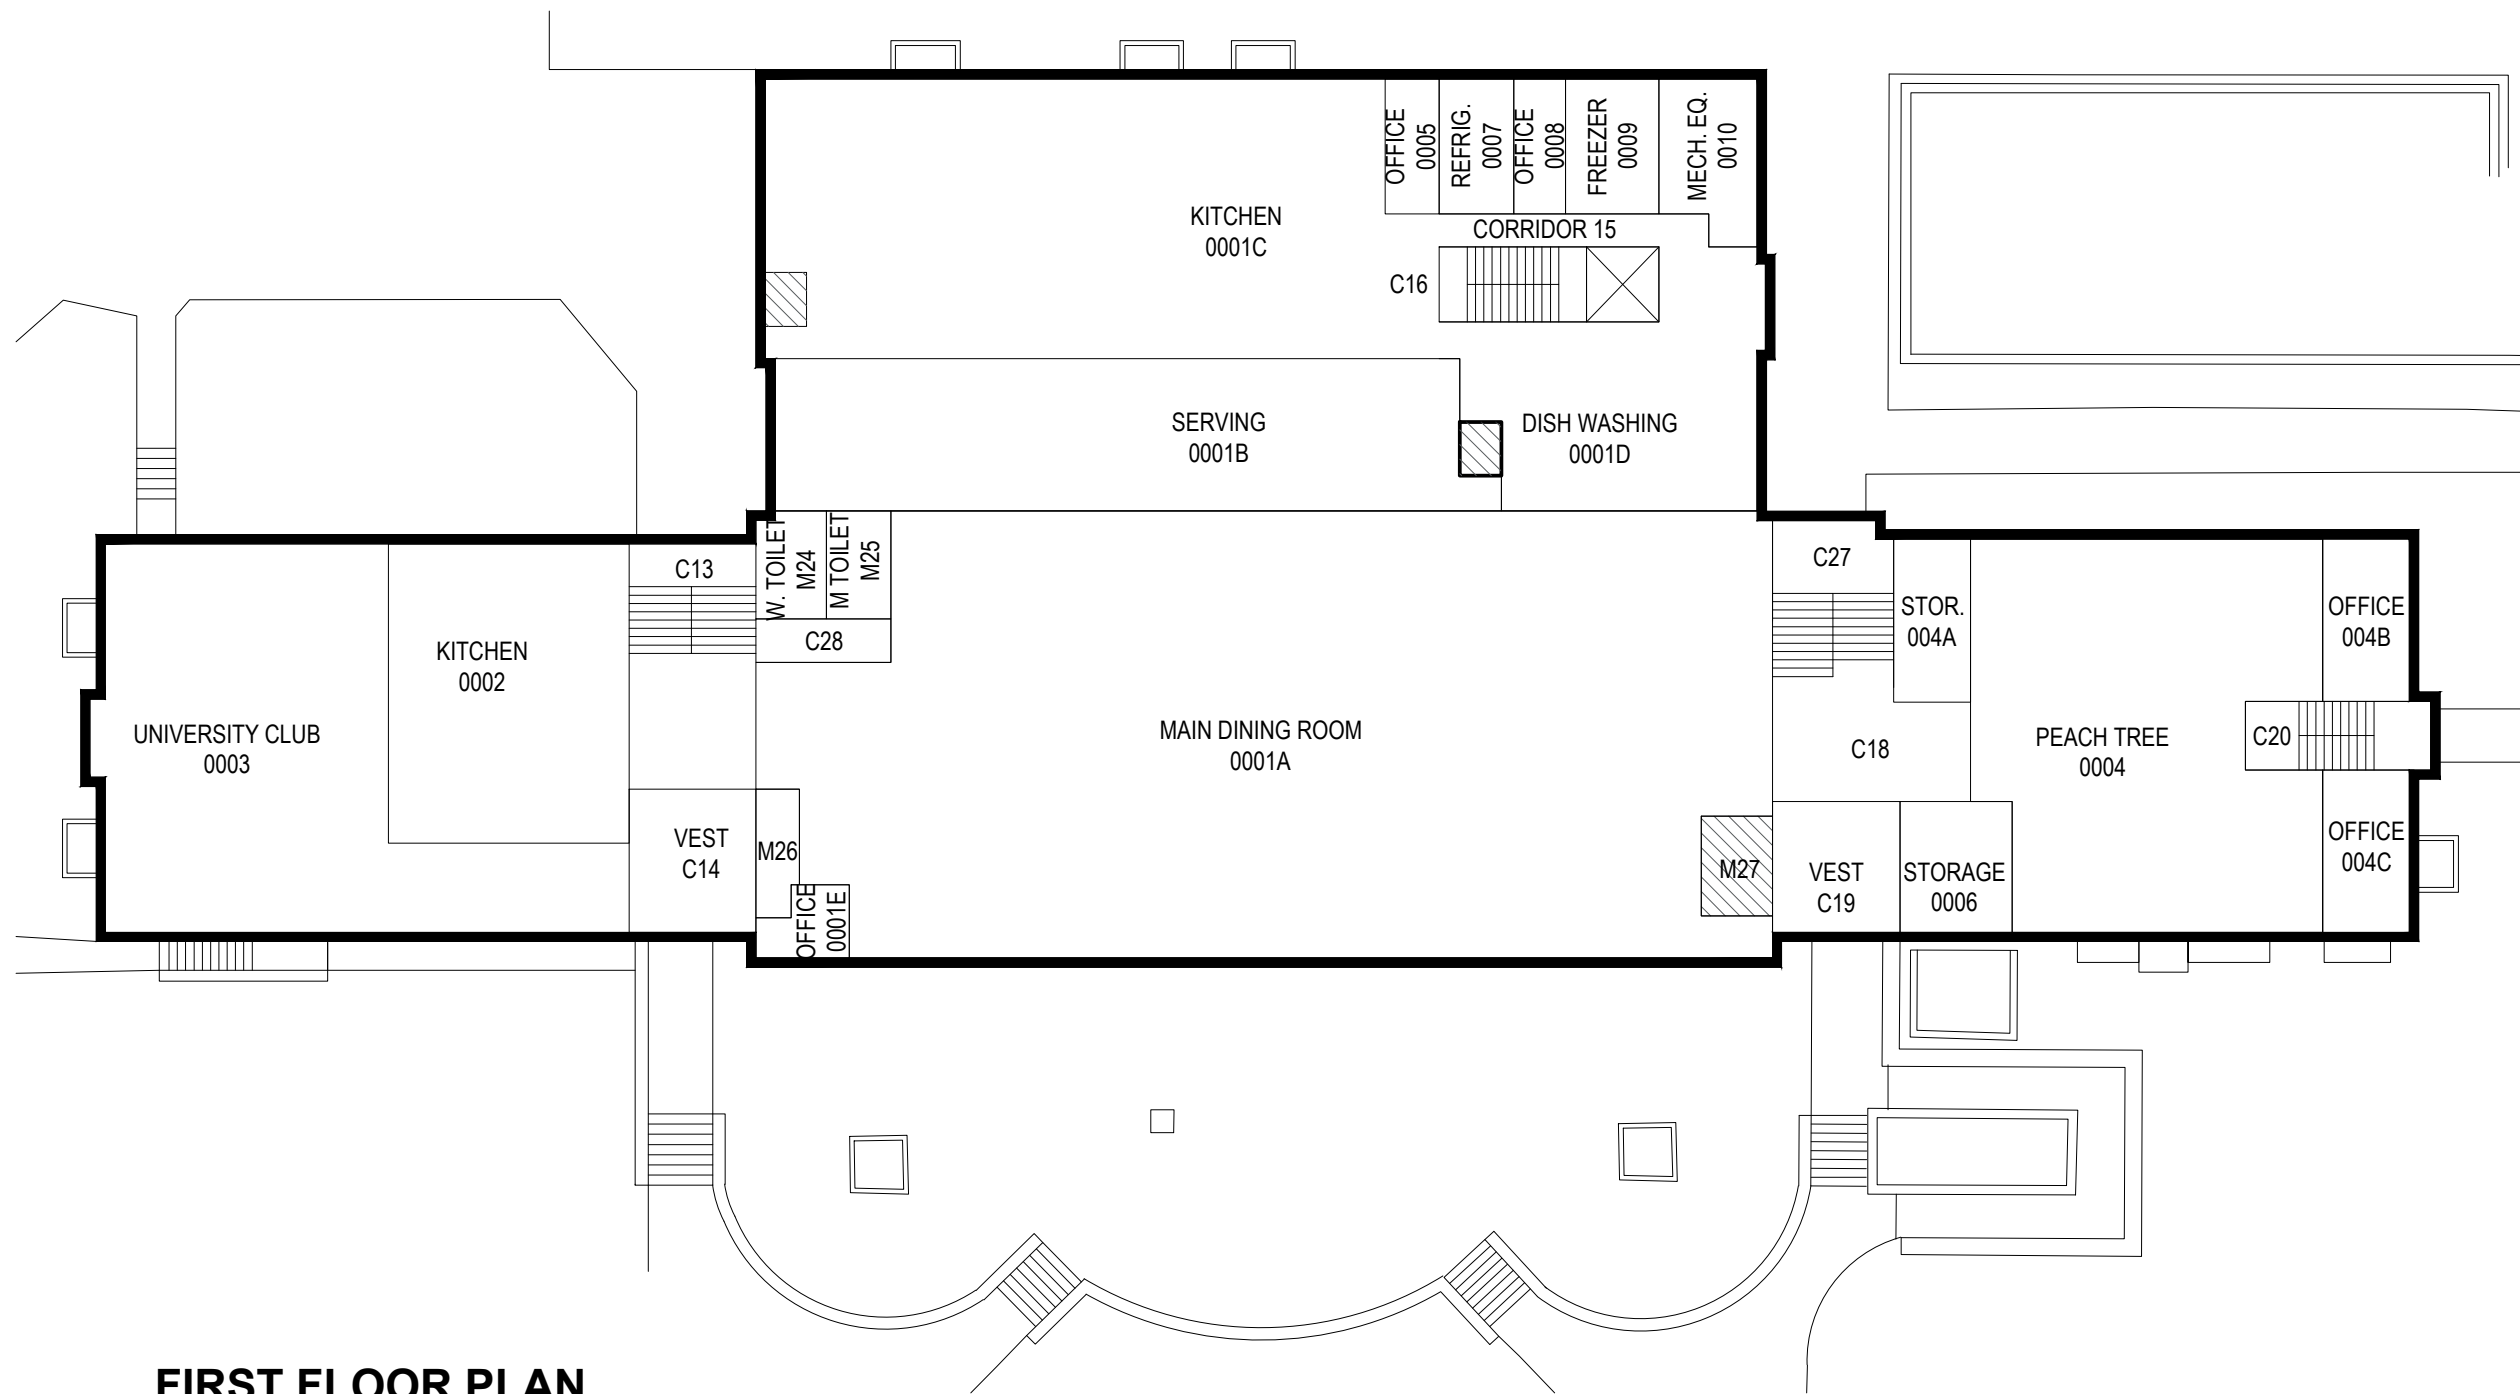

FIRST FLOOR PLAN

CLIENT

Farmingdale State College

SCALE:

1"=20'

DATE:

JUNE-2015


Knapp Hall - 040



architects + engineers

Melville, NY Albany, NY
New City, NY Parsippany, NJ



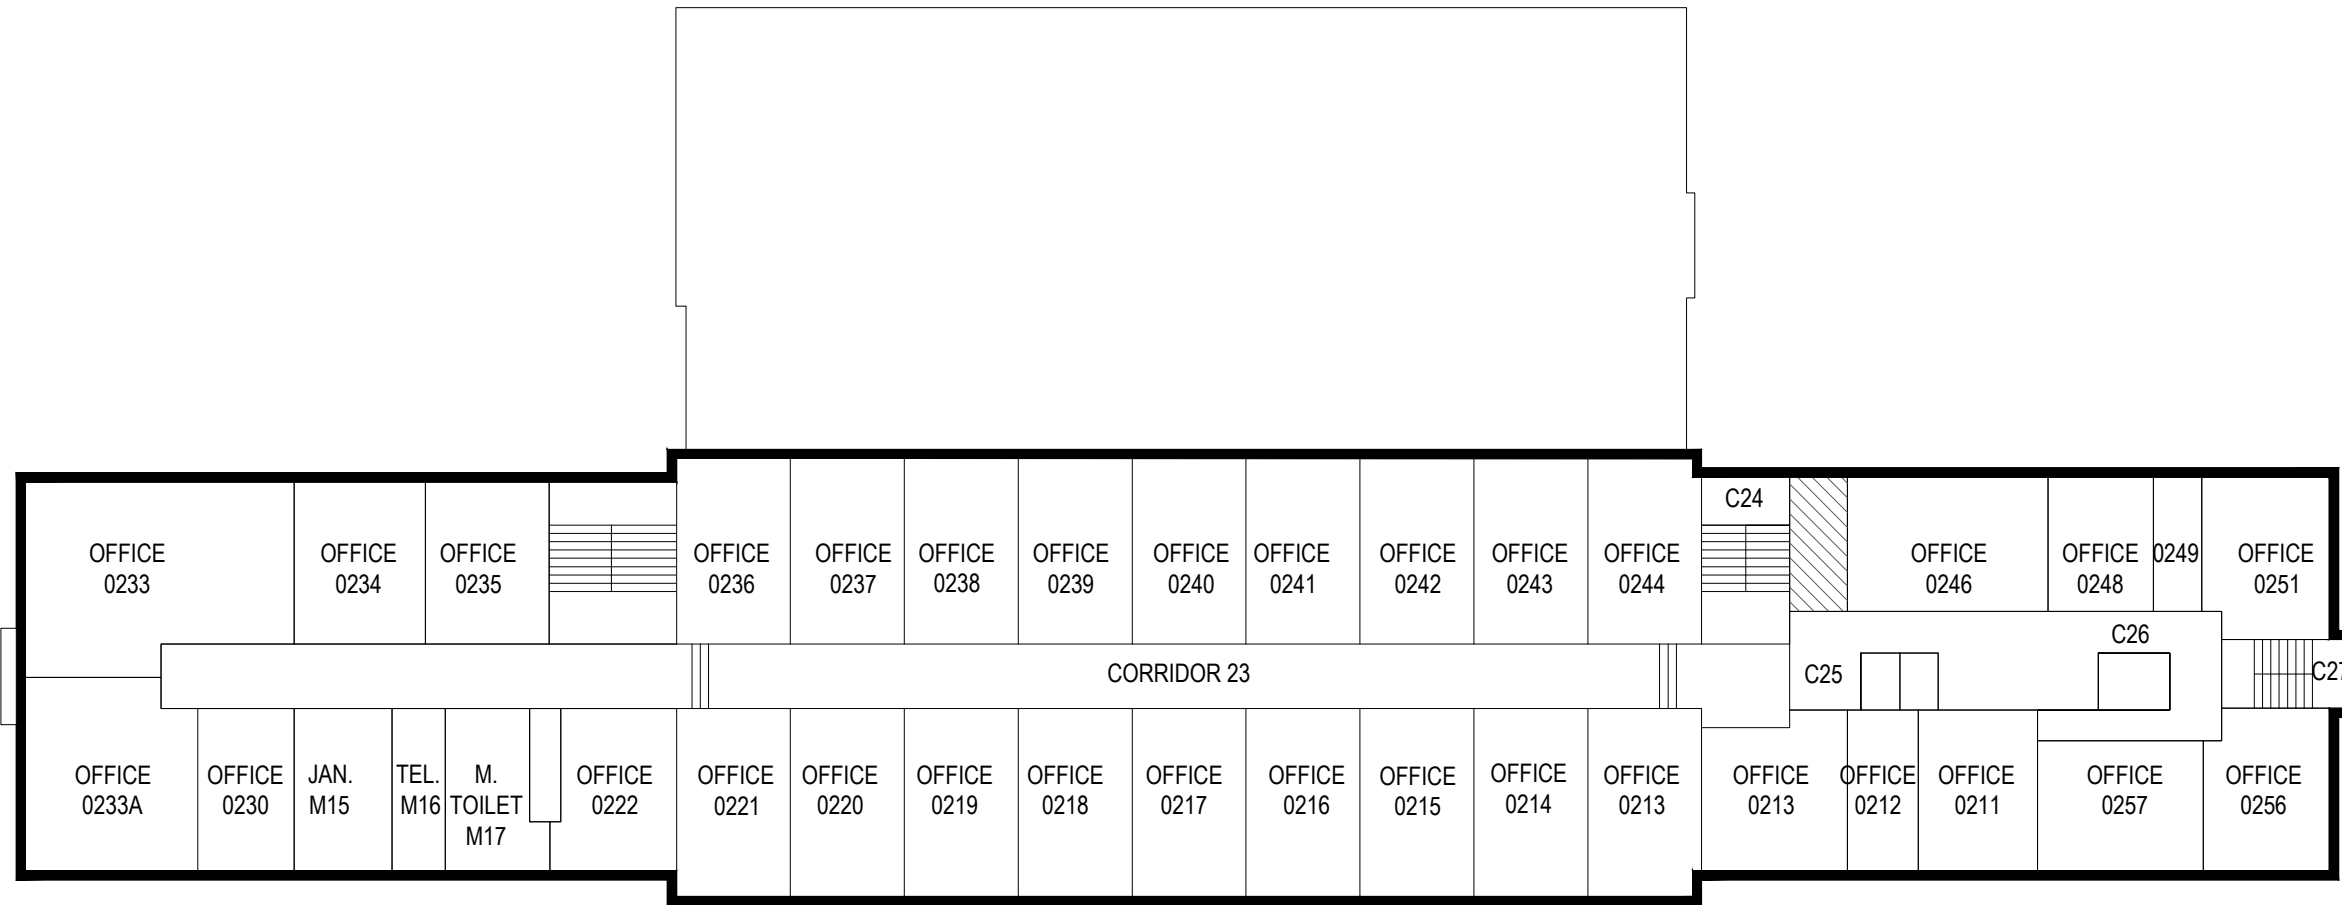

SECOND FLOOR PLAN



CLIENT

Farmingdale State College

SCALE:

1"=20'

DATE:


JUNE-2015

Knapp Hall - 040



architects + engineers

Melville, NY Albany, NY
New City, NY Parsippany, NJ

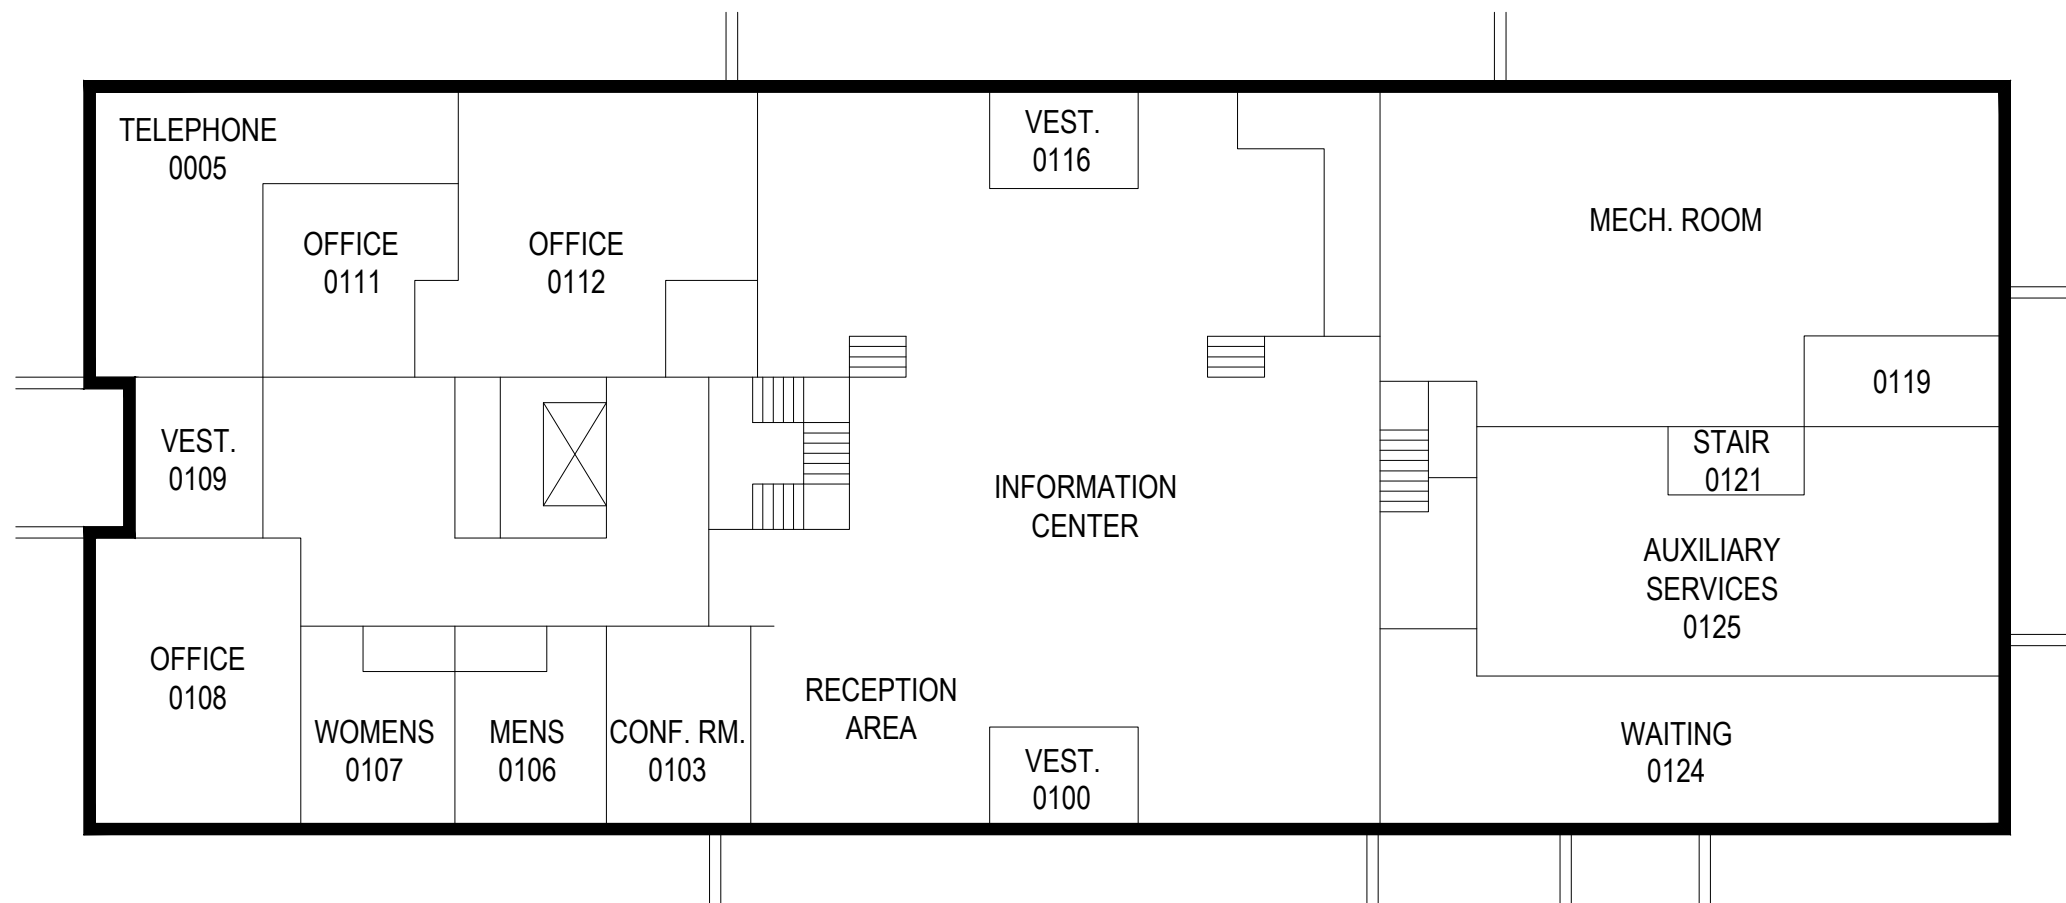

FIRST FLOOR PLAN



CLIENT

Farmingdale State College

SCALE:


1/16"=1'-0"

DATE:

JUNE-2015

Laffin Hall - 002

H	2	architects + engineers Melville, NY Albany, NY New City, NY Parsippany, NJ
M	M	

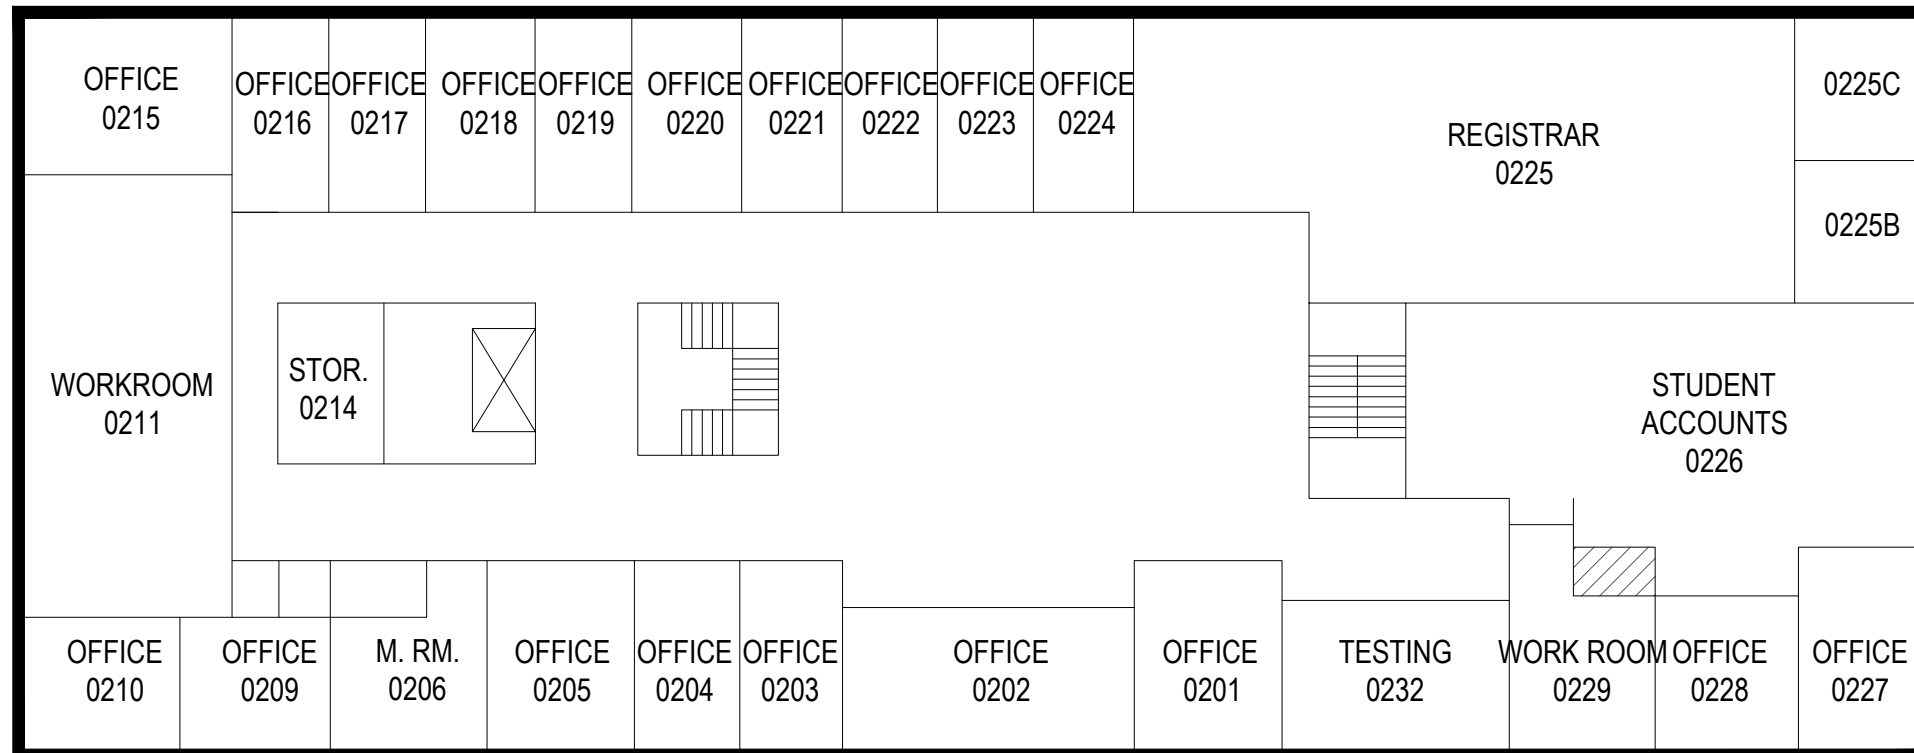

SECOND FLOOR PLAN



CLIENT

Farmingdale State College

SCALE:

1/16"=1'-0"

DATE:

JUNE-2015


Laffin Hall - 002



architects + engineers

Melville, NY Albany, NY
New City, NY Parsippany, NJ

65

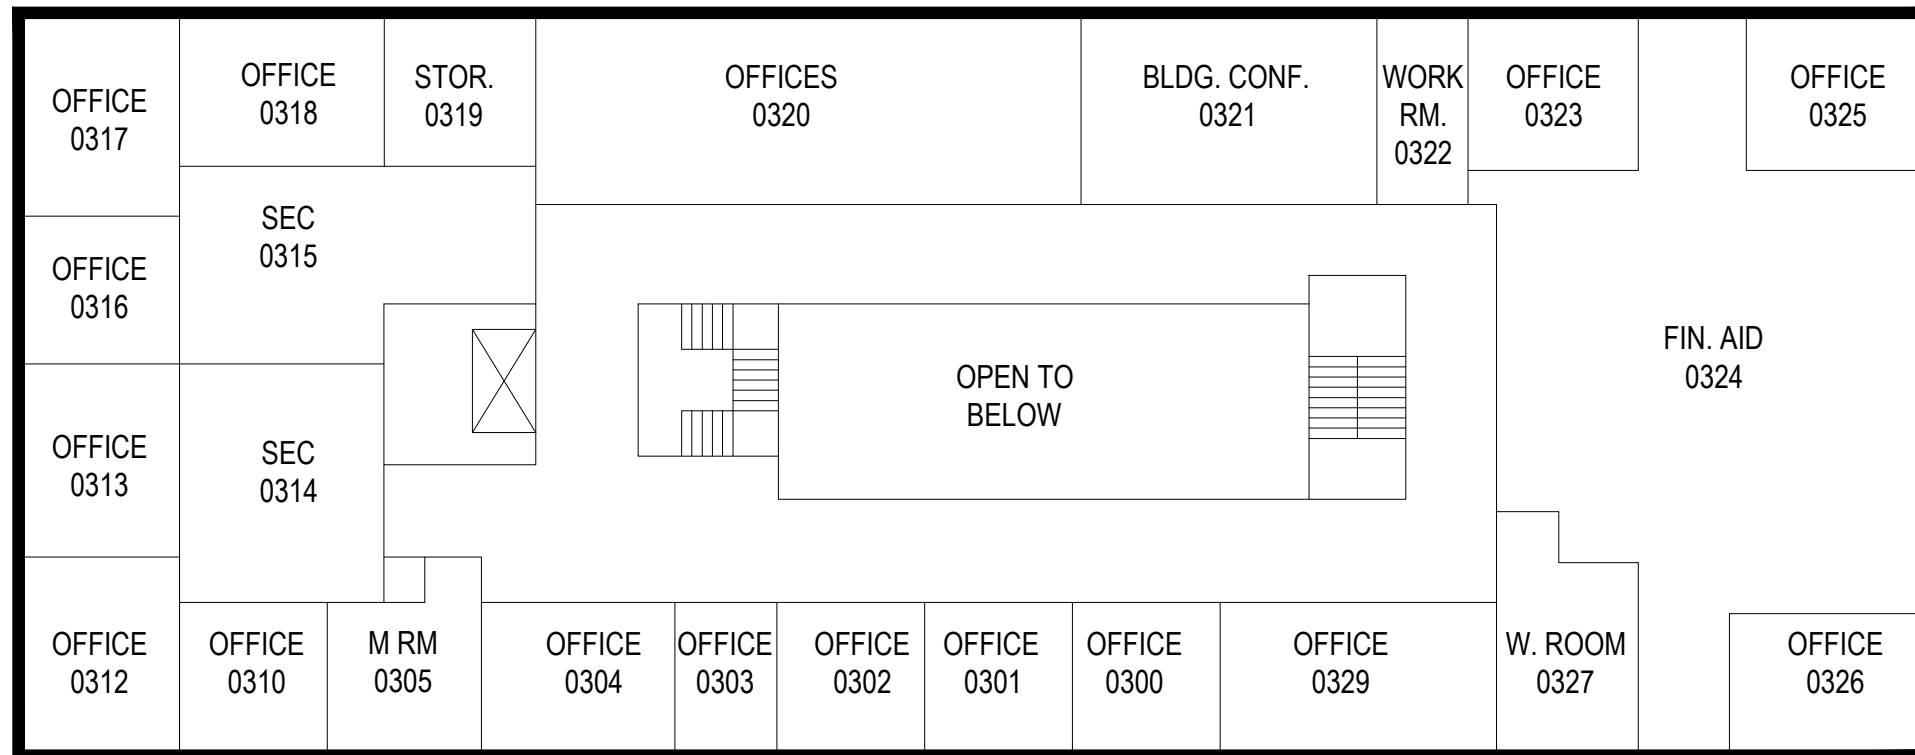

THIRD FLOOR PLAN



CLIENT

Farmingdale State College

SCALE:

1/16"=1'-0"

DATE:


JUNE-2015

Laffin Hall - 002



architects + engineers

Melville, NY Albany, NY
New City, NY Parsippany, NJ

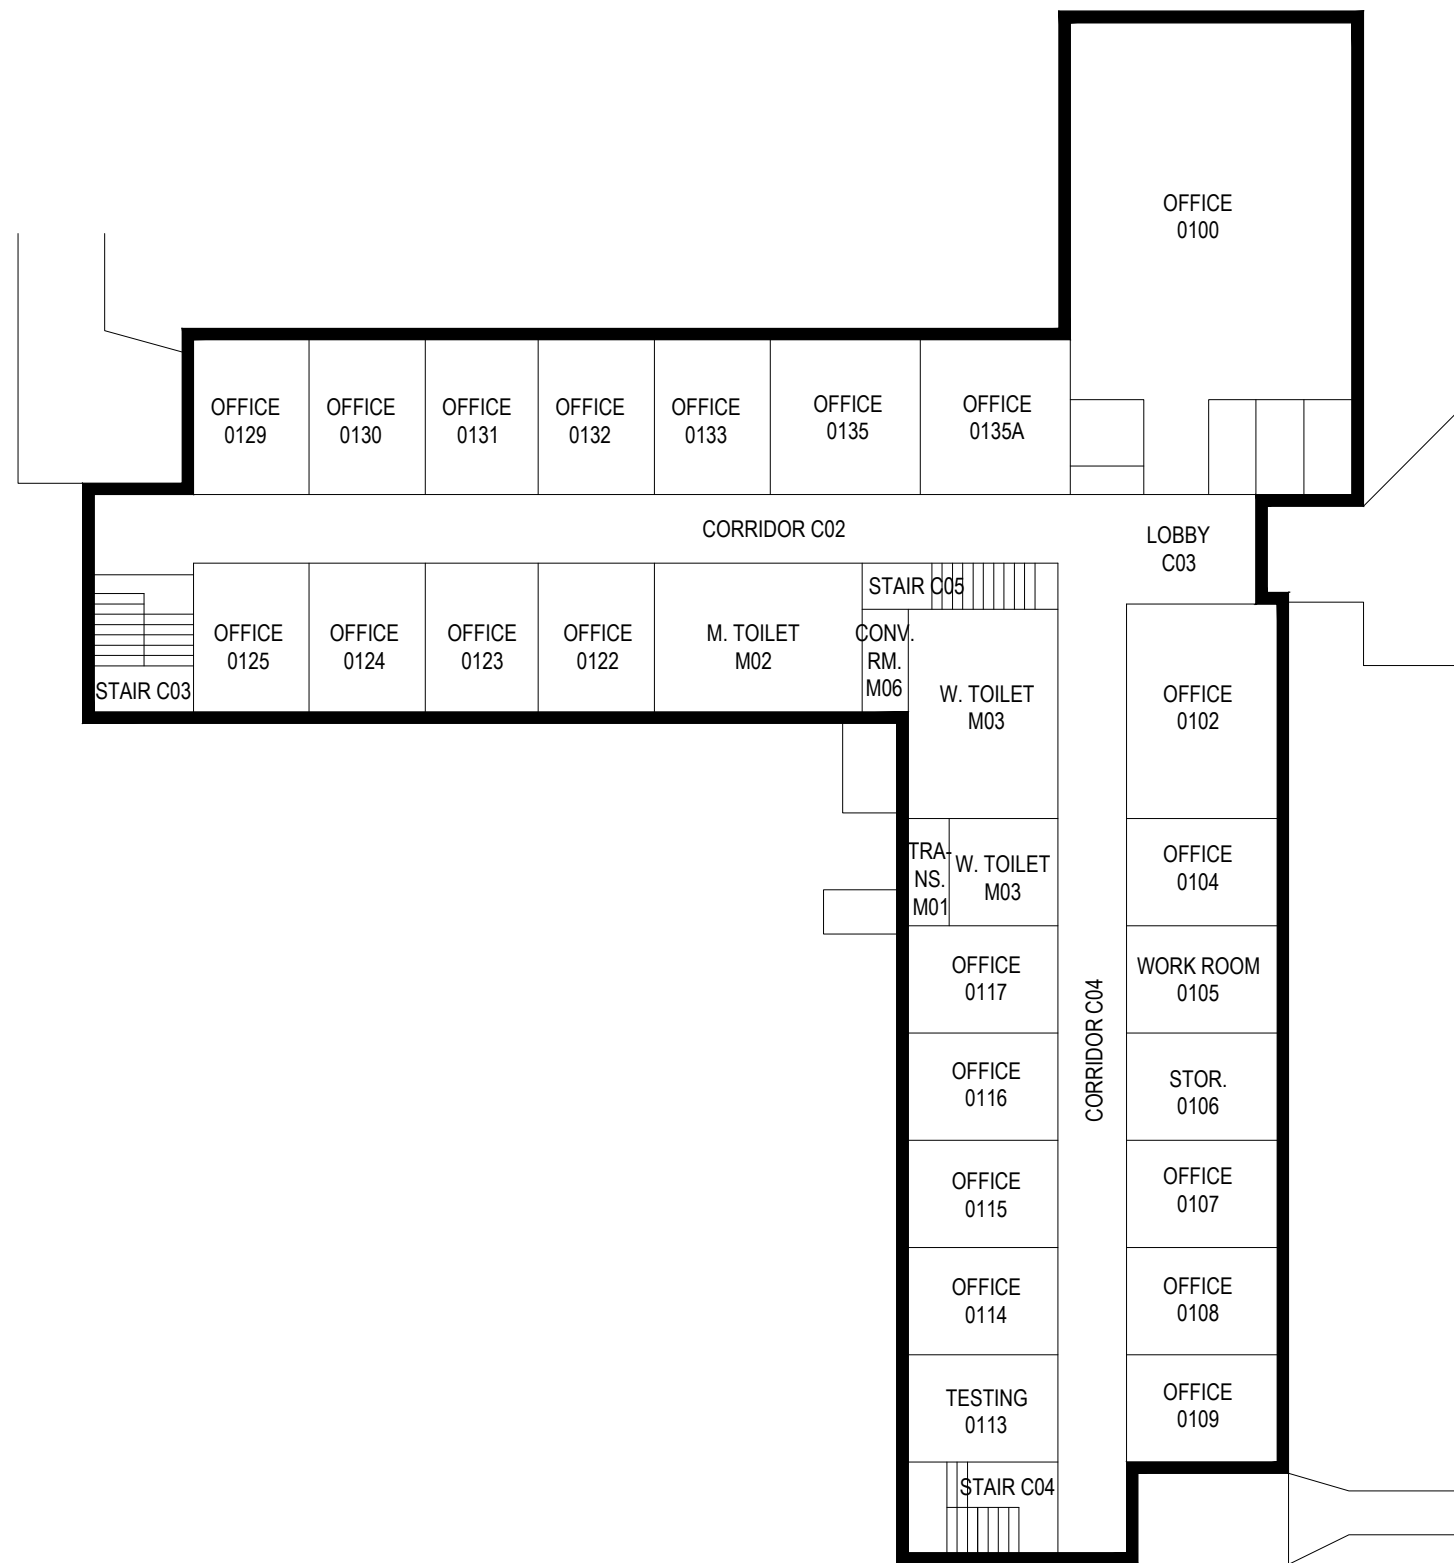

FIRST FLOOR PLAN



CLIENT

Farmingdale State College

SCALE:

1/16"=1'-0"

DATE:


JUNE-2015

Memorial Hall - 066




architects + engineers

Melville, NY Albany, NY
New City, NY Parsippany, NJ

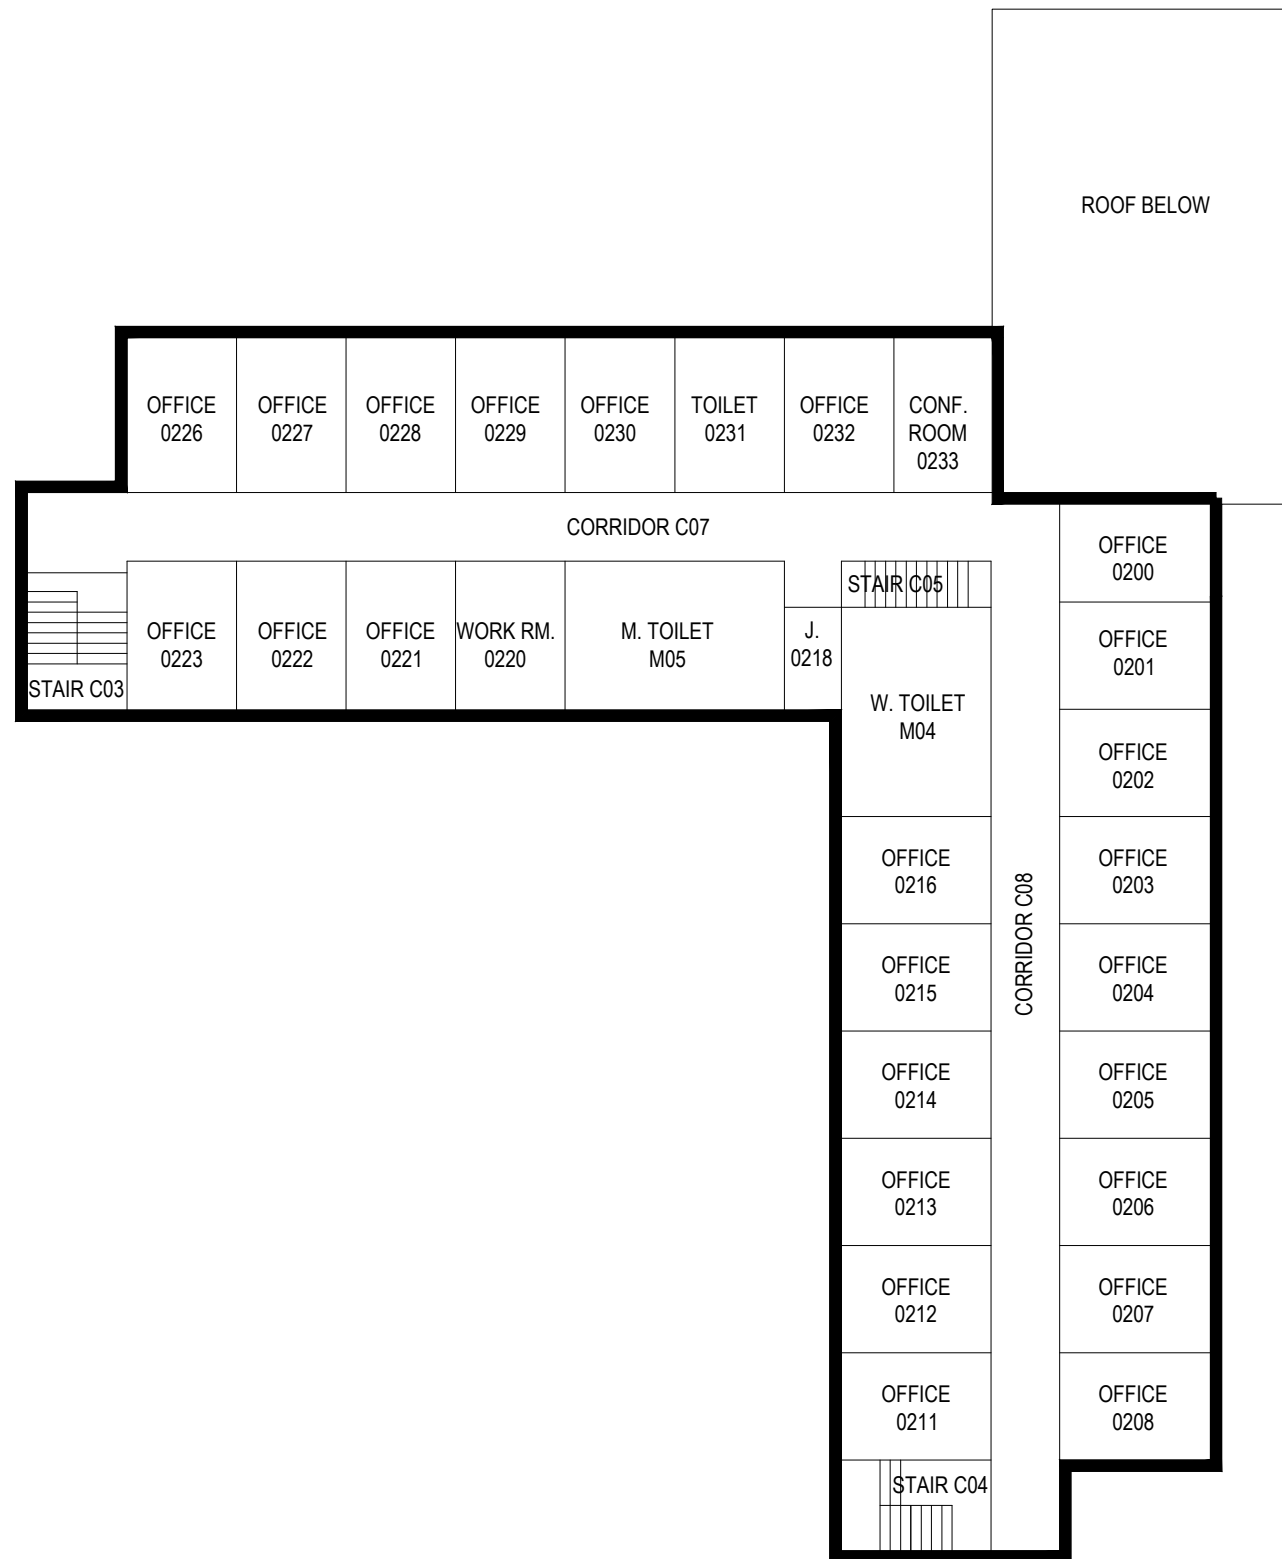

SECOND FLOOR PLAN

 

CLIENT

Farmingdale State College


SCALE:

1/16"=1'-0"

DATE:


JUNE-2015

Memorial Hall - 066

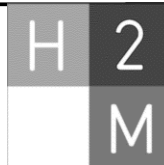

architects + engineers

Melville, NY Albany, NY
New City, NY Parsippany, NJ

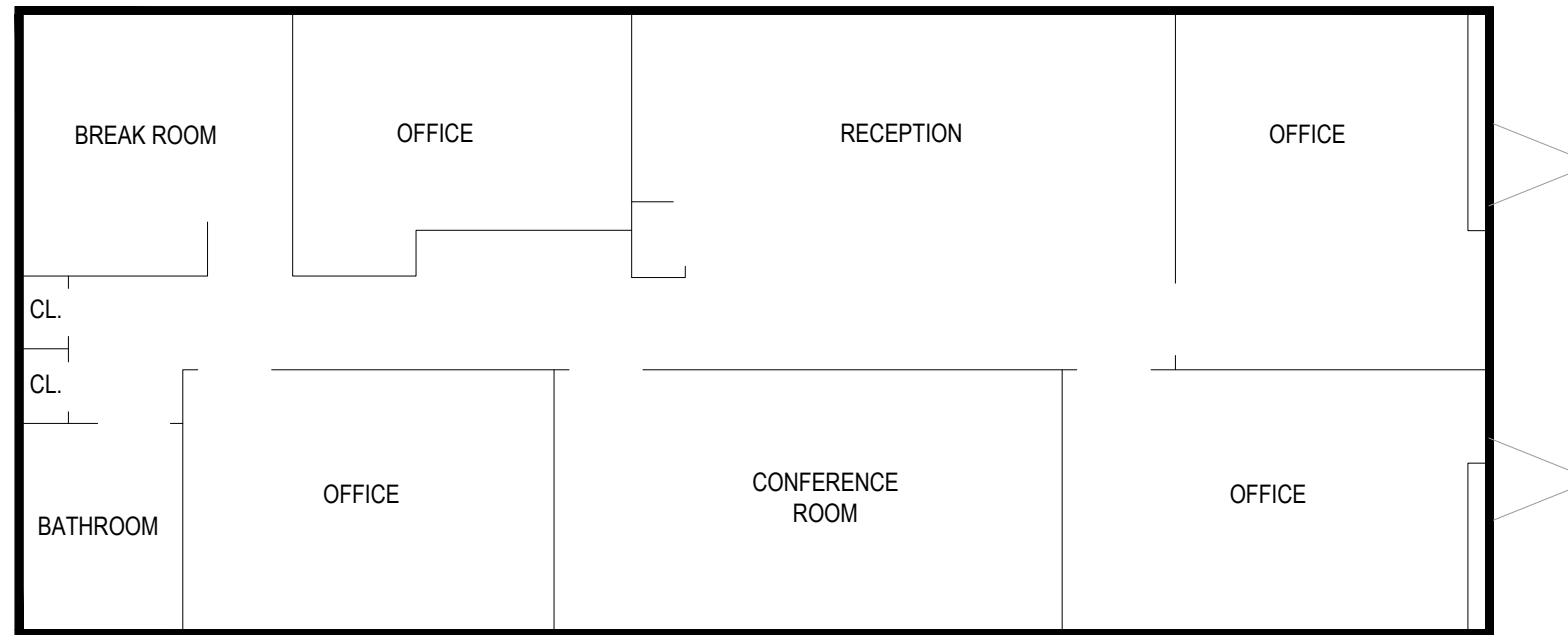

FIRST FLOOR PLAN



CLIENT

Farmingdale State College


SCALE:

1/8"=1'-0"

DATE:


JUNE-2015

Module Trailer 19

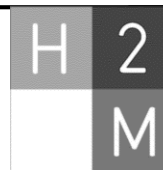

architects + engineers

Melville, NY Albany, NY
New City, NY Parsippany, NJ

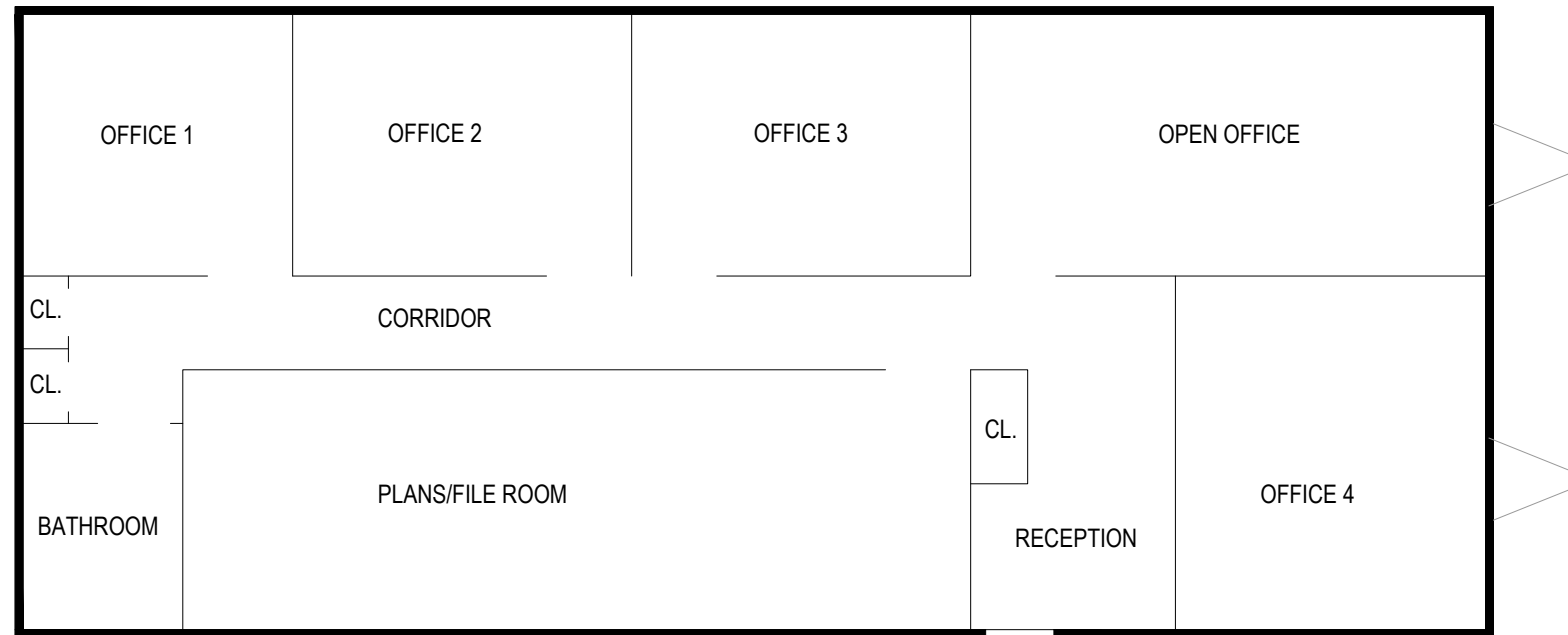

FIRST FLOOR PLAN

CLIENT

Farmingdale State College


SCALE:

1/8"=1'-0"

DATE:


JUNE-2015

Module Trailer #2 - CM Trailer

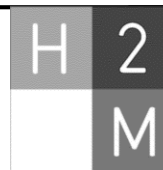

architects + engineers

Melville, NY Albany, NY
New City, NY Parsippany, NJ

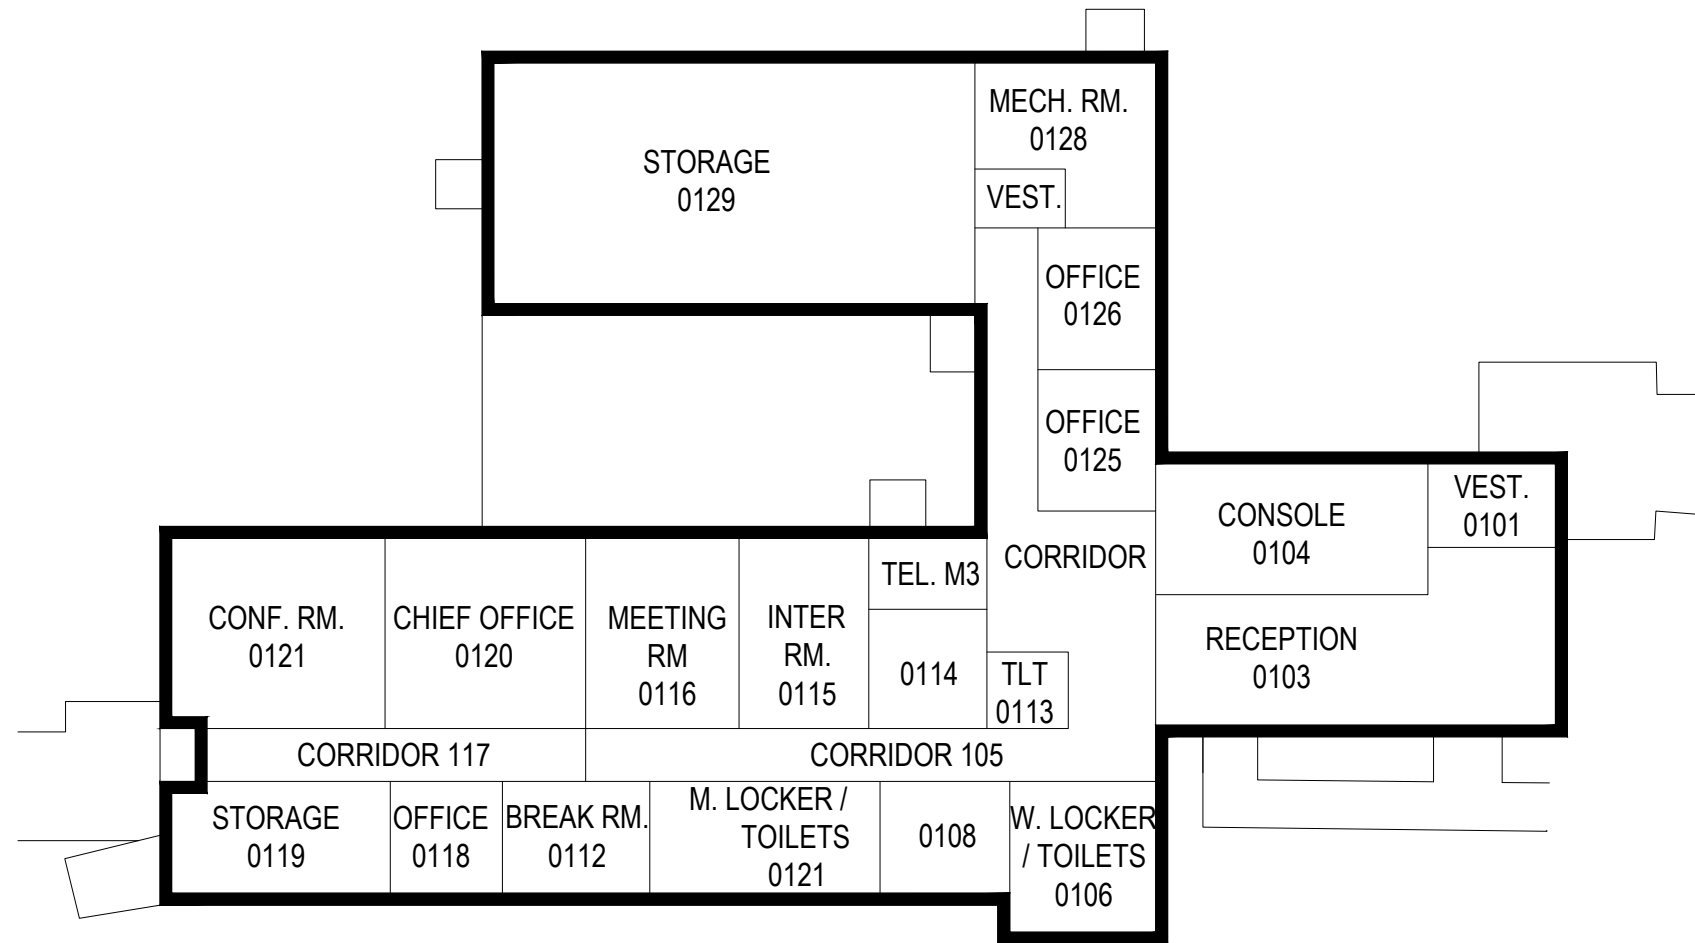

FIRST FLOOR PLAN



CLIENT

Farmingdale State College

SCALE:

1/16"=1'-0"

DATE:


JUNE-2015

Police Headquarters- 046



architects + engineers

Melville, NY Albany, NY
New City, NY Parsippany, NJ

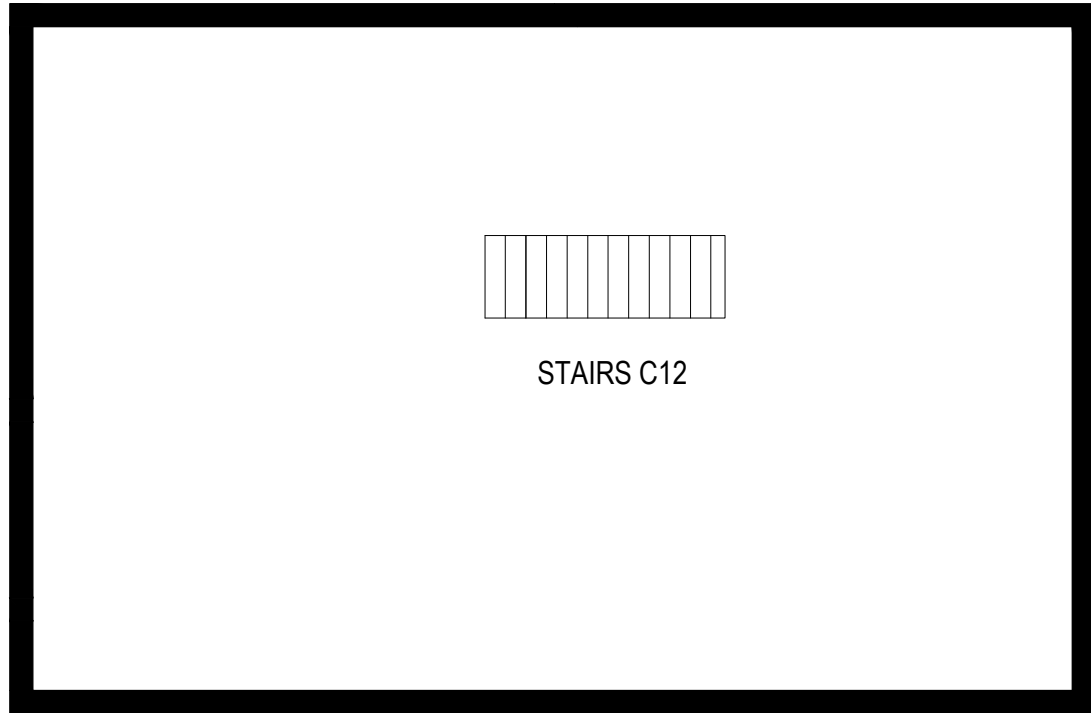

BASEMENT FLOOR PLAN



CLIENT

Farmingdale State College

SCALE:

1/16"=1'-0"

DATE:

JUNE-2015


The Cottage - 001

REF. Drawing
SUFA 15-01



architects + engineers

Melville, NY Albany, NY
New City, NY Parsippany, NJ

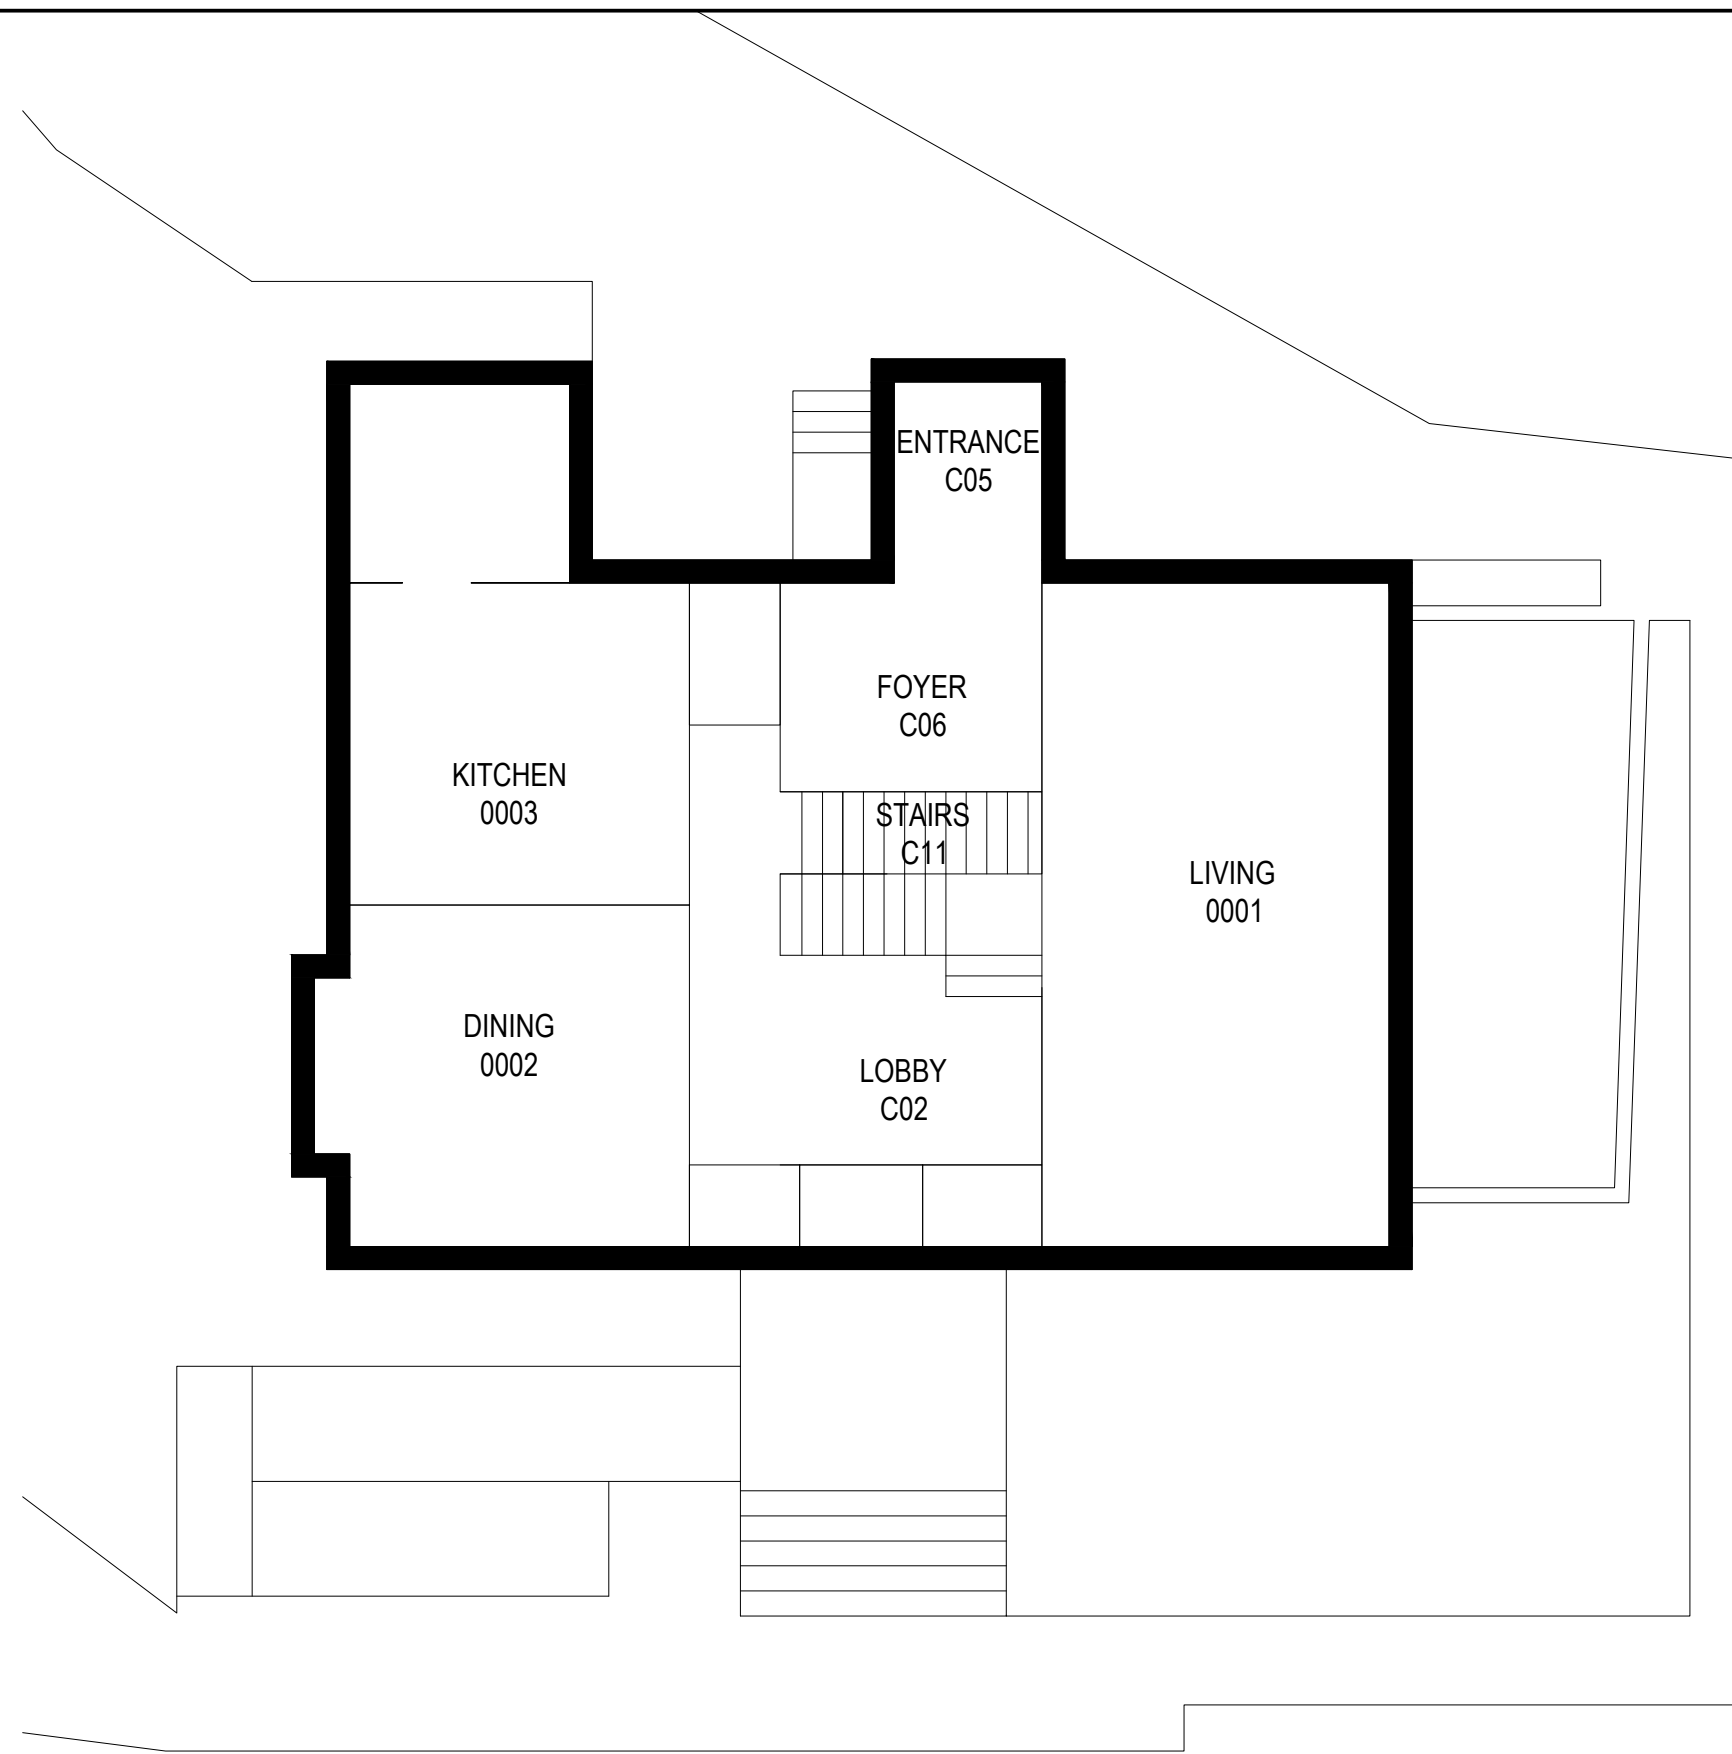

FIRST FLOOR PLAN



CLIENT

Farmingdale State College

SCALE:


1/16"=1'-0"

DATE:

JUNE-2015


The Cottage - 001

REF. Drawing
SUFA 15-01

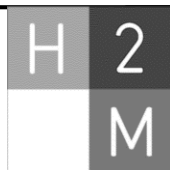

architects + engineers

Melville, NY Albany, NY
New City, NY Parsippany, NJ

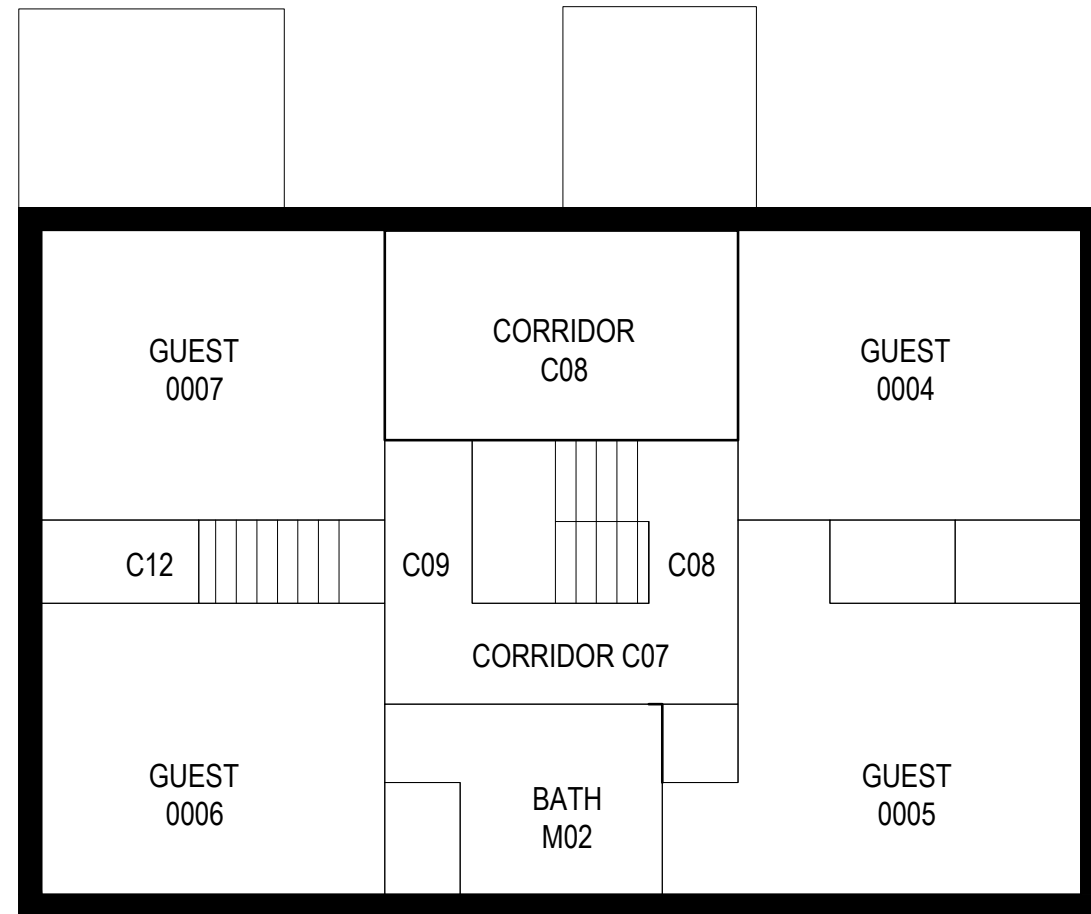

SECOND FLOOR PLAN



CLIENT

Farmingdale State College


SCALE:

1/16"=1'-0"

DATE:


JUNE-2015

The Cottage - 001

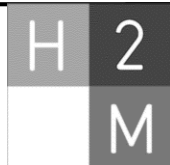

architects + engineers

Melville, NY Albany, NY
New City, NY Parsippany, NJ

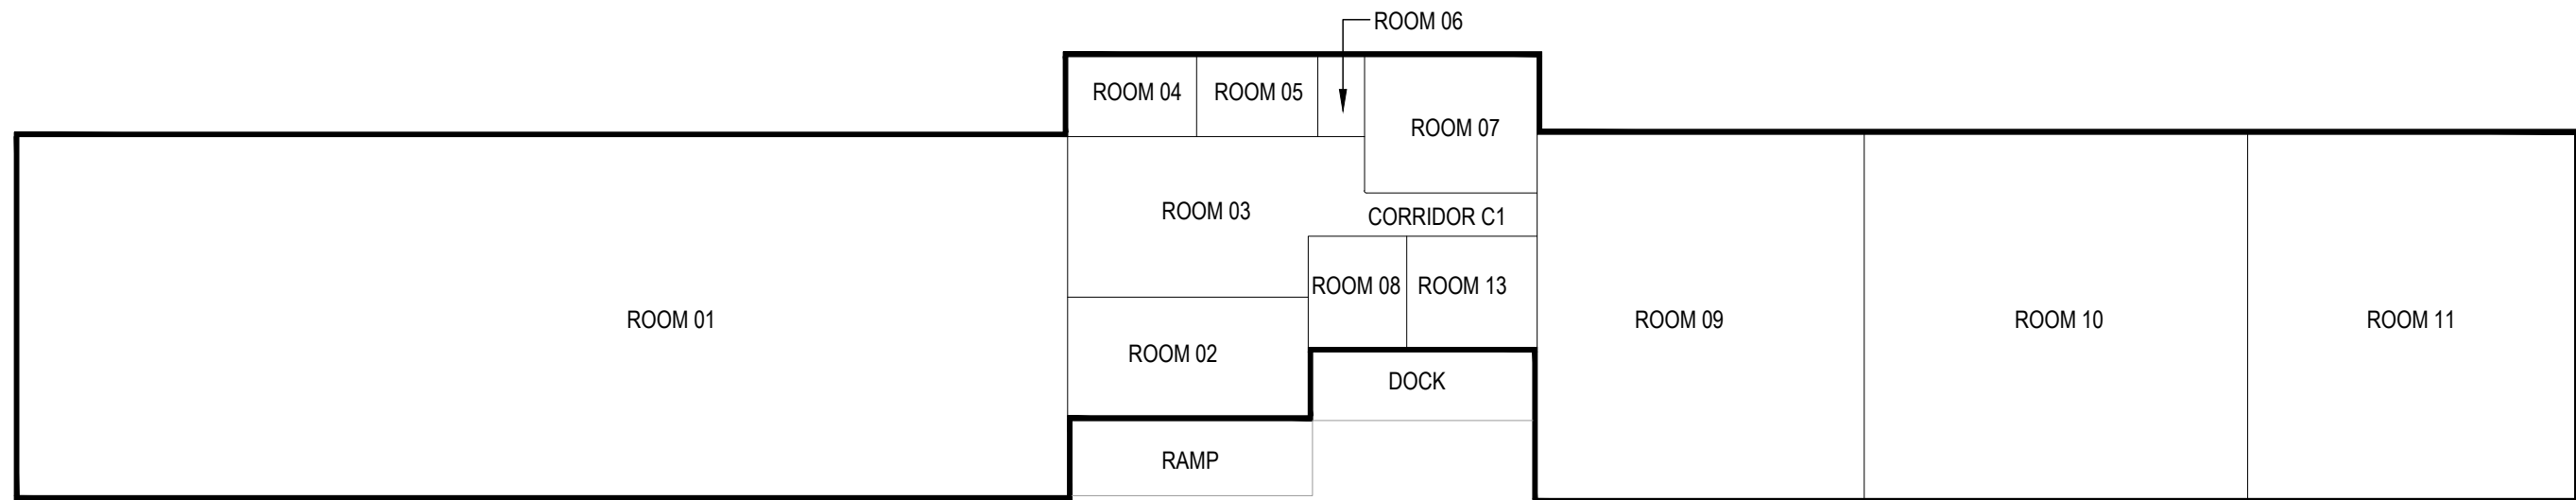

FIRST FLOOR PLAN



CLIENT

Farmingdale State College


SCALE:

1"=20'

DATE:

JUNE-2015


Poultry Building- 077

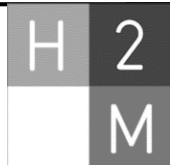

architects + engineers

Melville, NY Albany, NY
New City, NY Parsippany, NJ

75

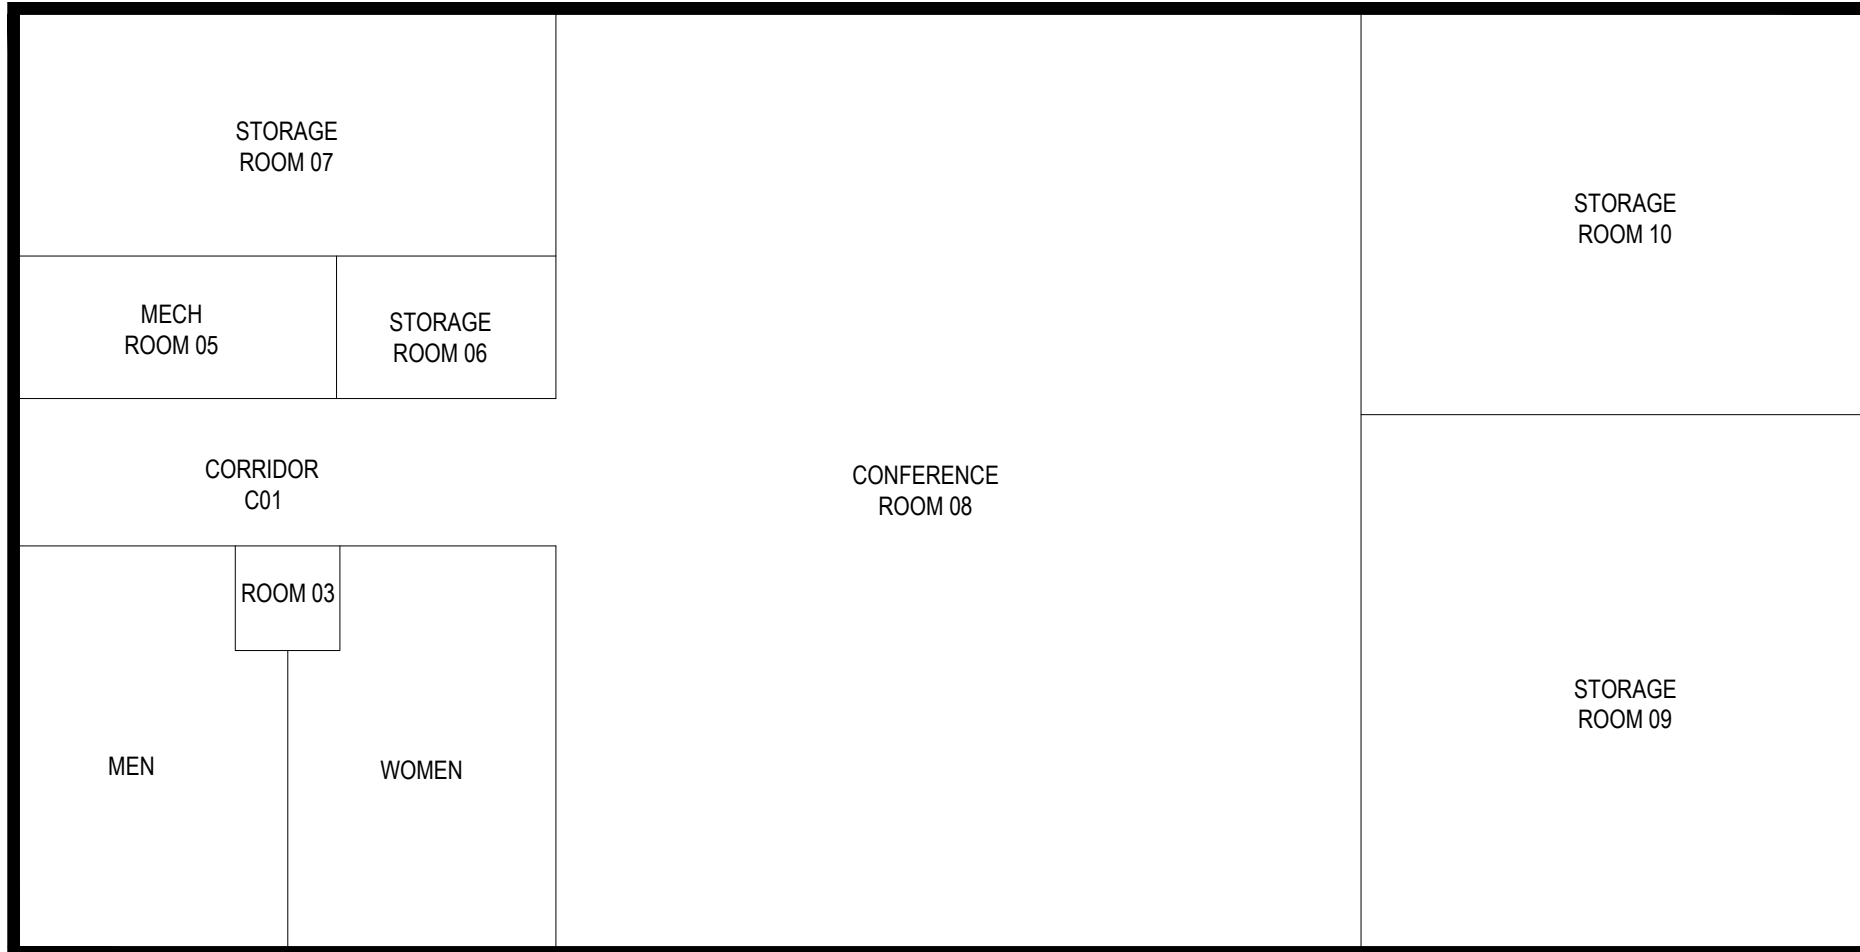

FIRST FLOOR PLAN



CLIENT

Farmingdale State College


SCALE:

1/8"=1'-0"

DATE:

JUNE-2015


SBDC Building - 076

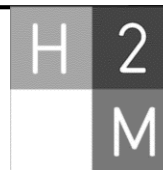


architects + engineers

Melville, NY Albany, NY
New City, NY Parsippany, NJ

76

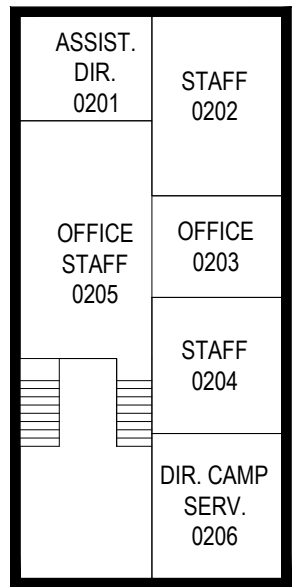

MEZZANINE FLOOR PLAN

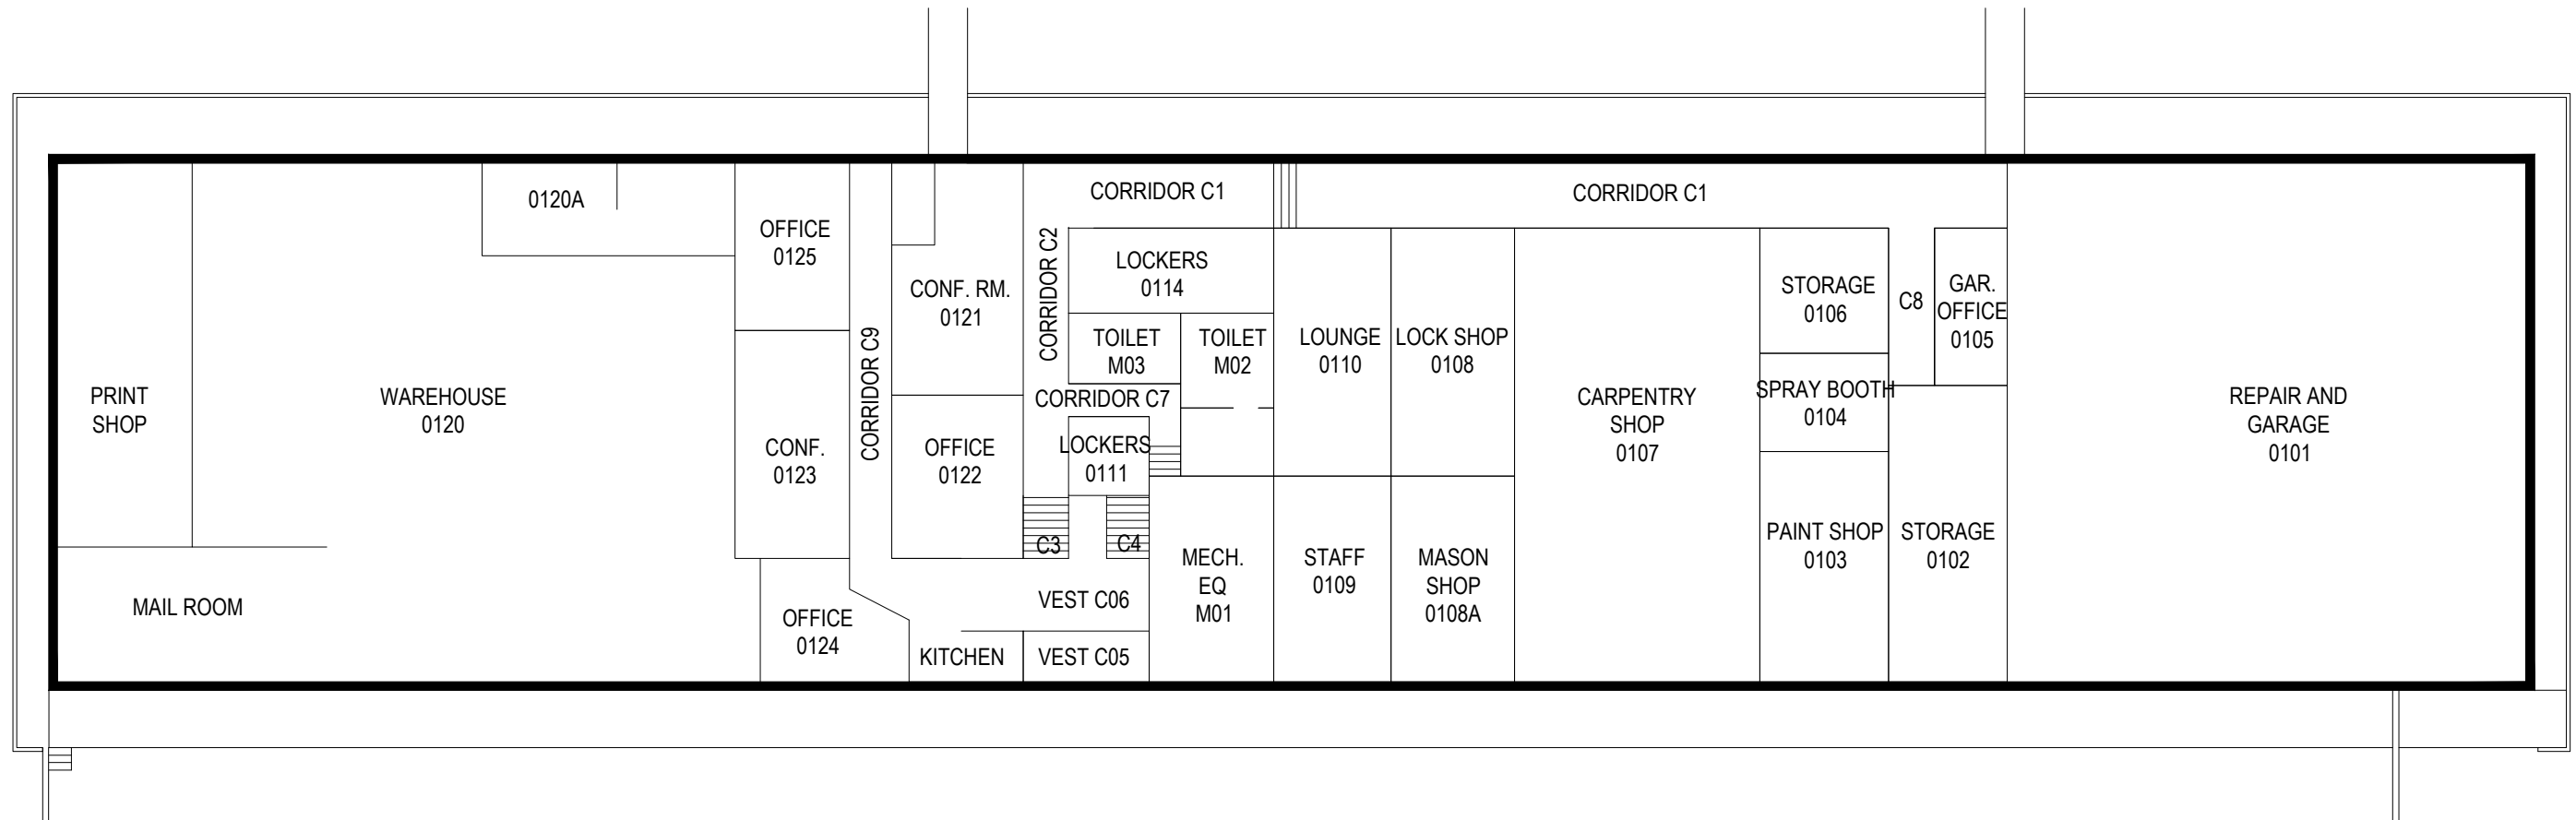

FIRST FLOOR PLAN




CLIENT
Farmingdale State College

SCALE:
1"=20'
DATE:
JUNE-2015

Service Building- 070

H 2 M
architects + engineers
Melville, NY Albany, NY
New City, NY Parsippany, NJ

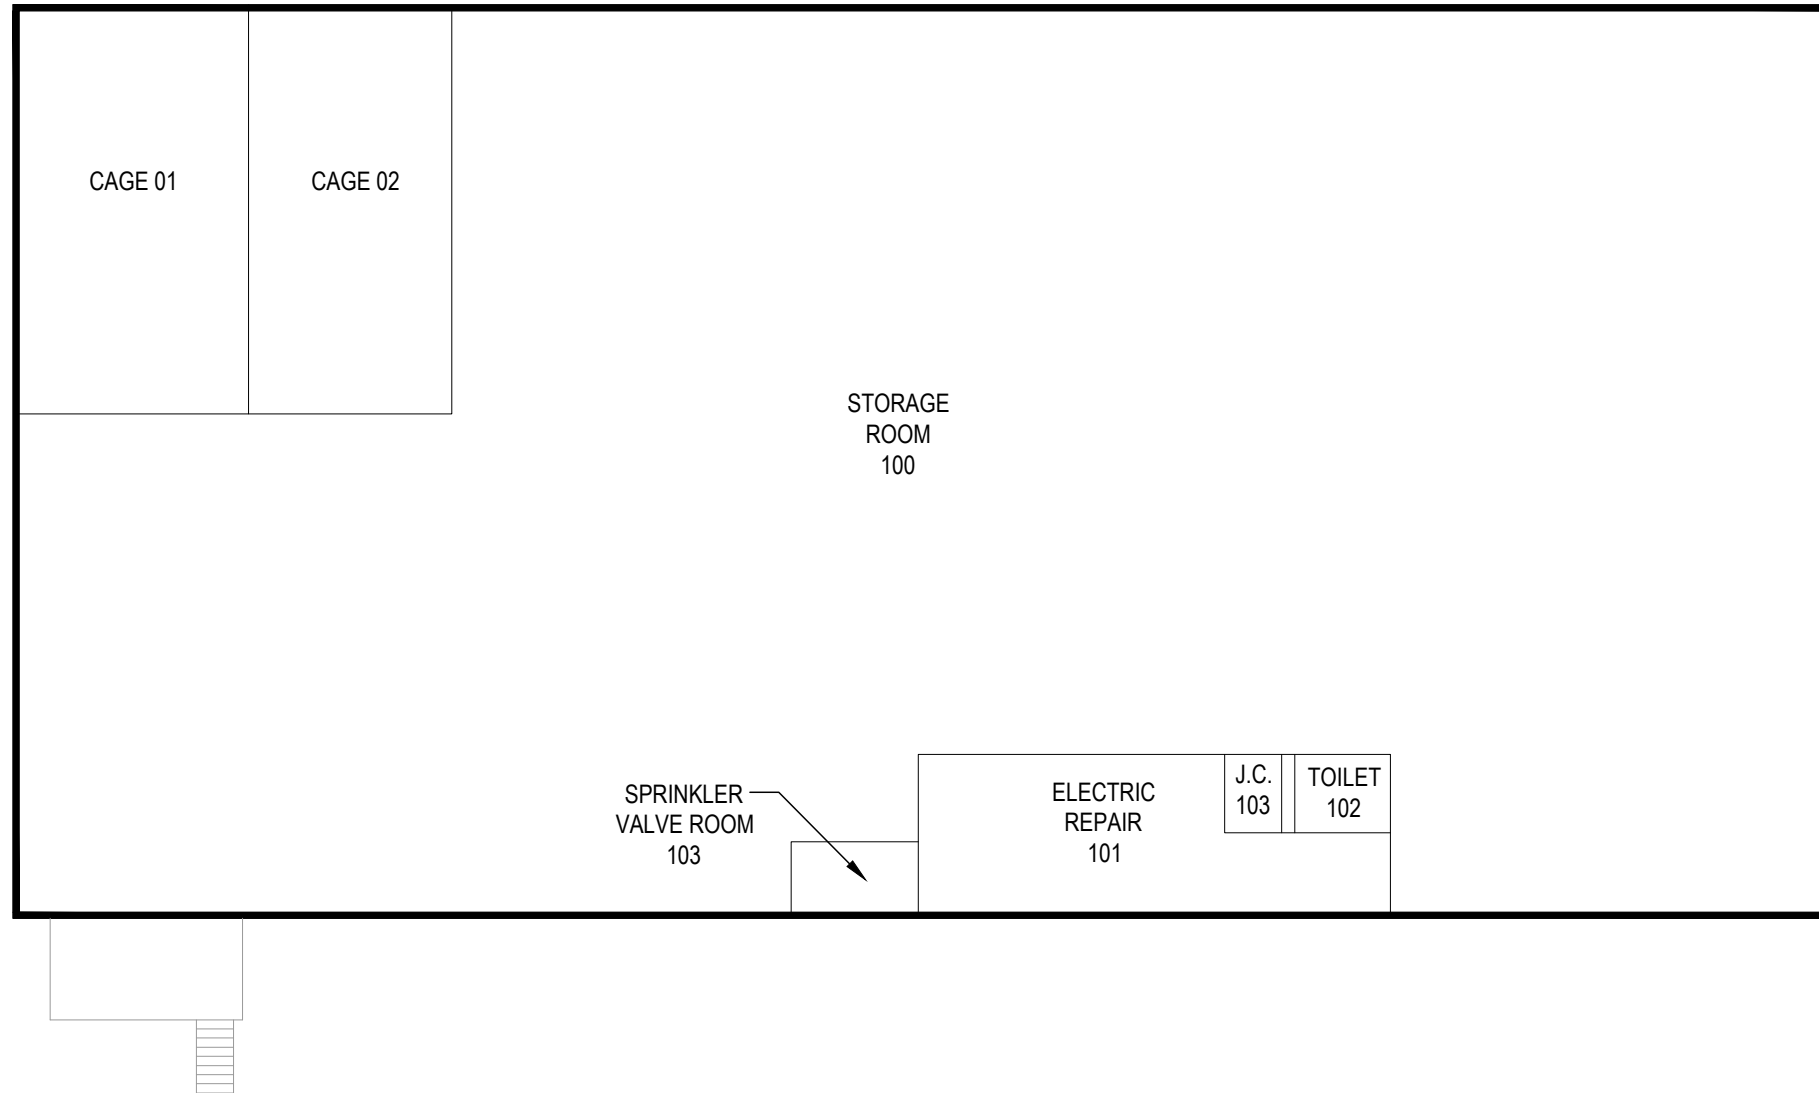

FIRST FLOOR PLAN



CLIENT

Farmingdale State College

SCALE:

1"=20'

DATE:

JUNE-2015

Storage Building - 029



architects + engineers

Melville, NY Albany, NY
New City, NY Parsippany, NJ

78



BASEMENT FLOOR PLAN



CLIENT

Farmingdale State College


SCALE:

1/8"=1'-0"

DATE:


JUNE-2015

Ward Hall- 011

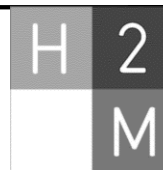

architects + engineers

Melville, NY Albany, NY
New City, NY Parsippany, NJ

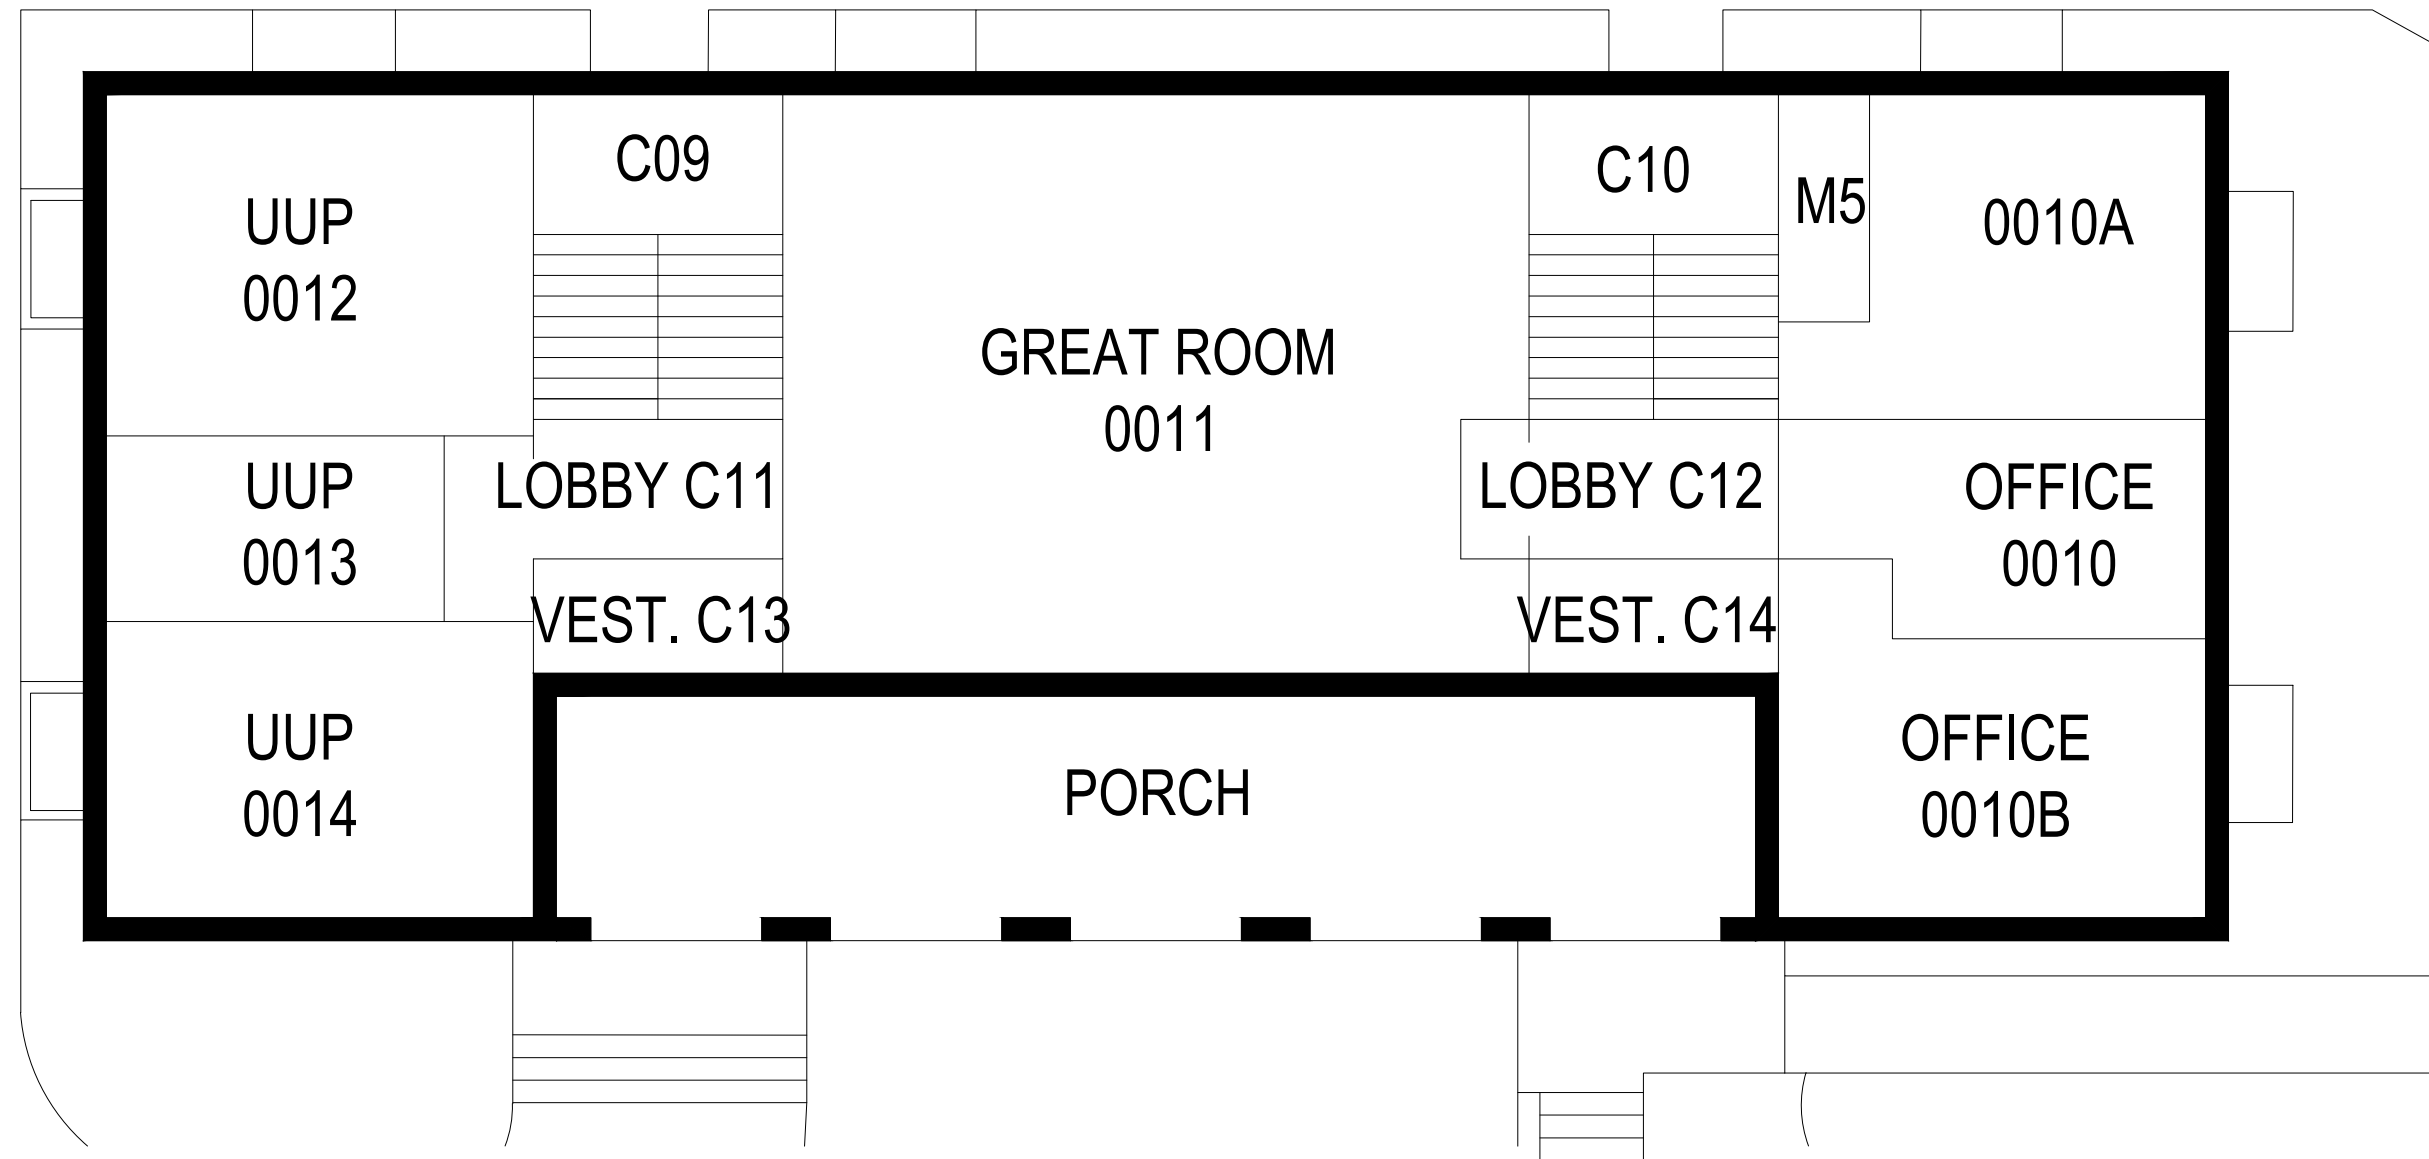

FIRST FLOOR PLAN



CLIENT

Farmingdale State College

SCALE:

1/8"=1'-0"

DATE:

JUNE-2015


Ward Hall- 011

REF. Drawing
SUFA 15-01



architects + engineers

Melville, NY Albany, NY
New City, NY Parsippany, NJ

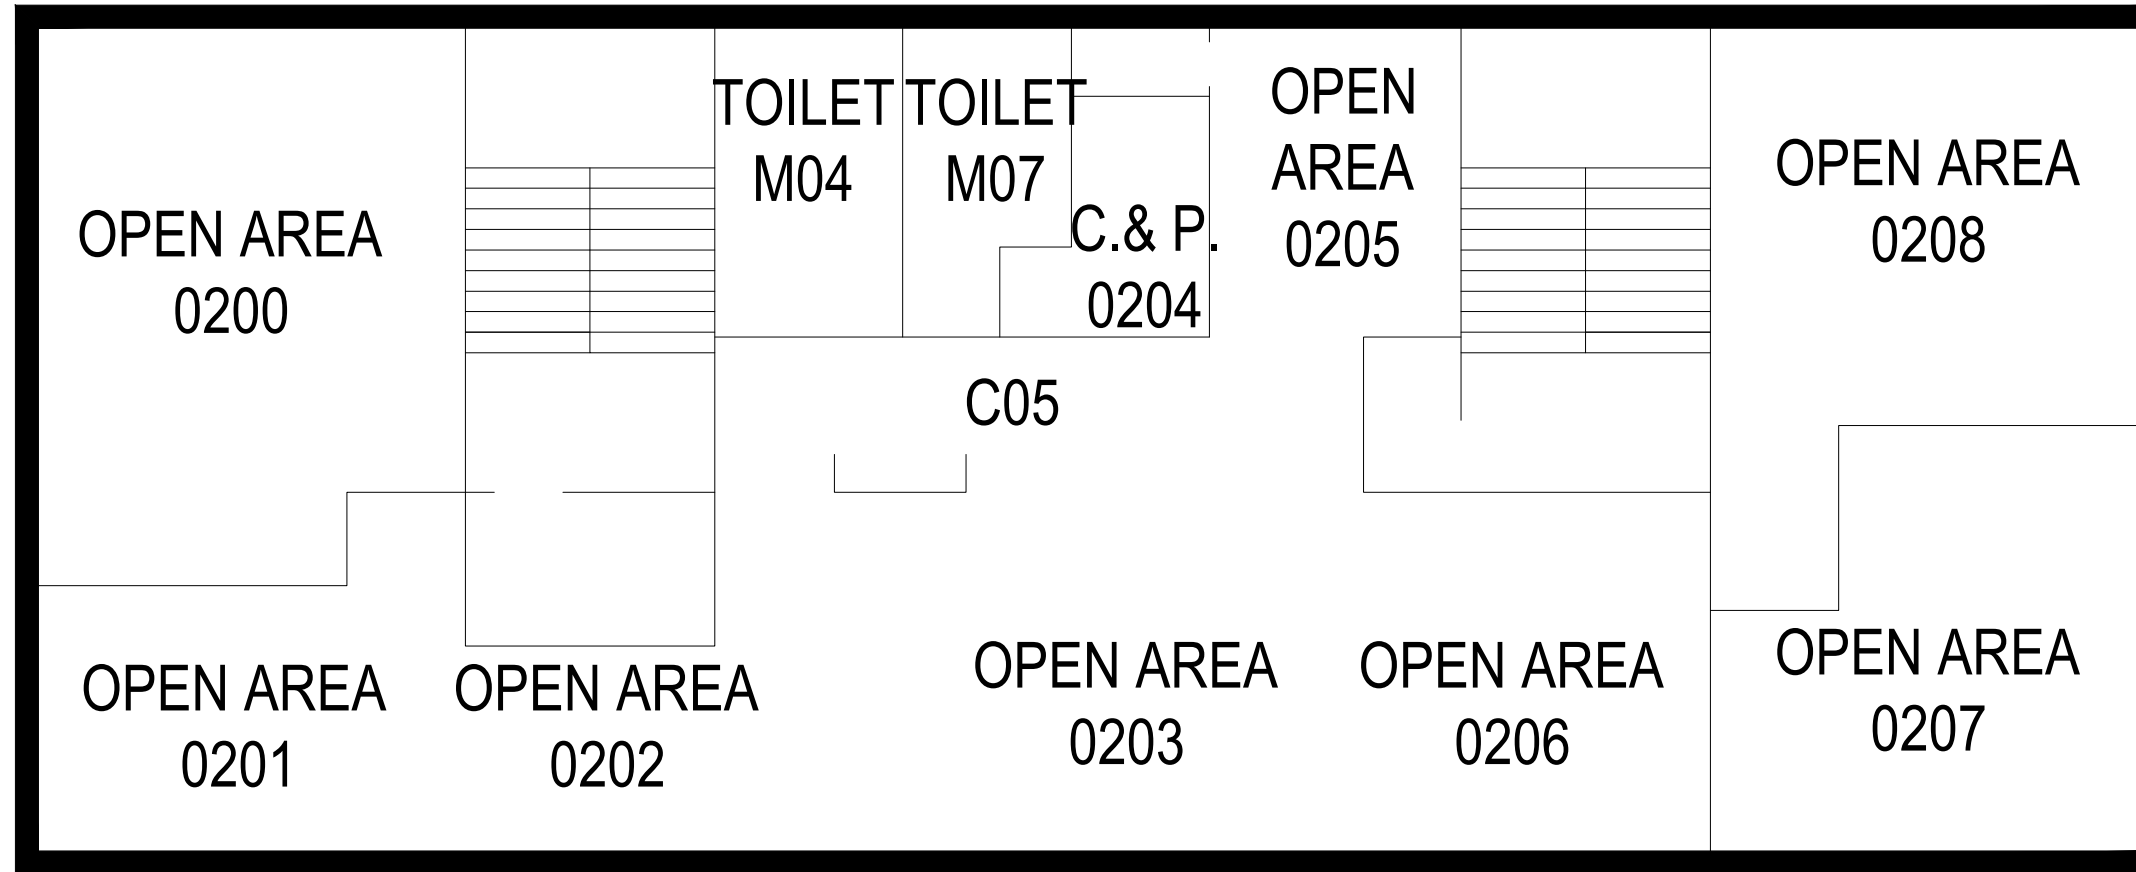

SECOND FLOOR PLAN



CLIENT

Farmingdale State College

SCALE:

1/8"=1'-0"

DATE:

JUNE-2015


Ward Hall- 011

REF. Drawing
SUFA 15-01



architects + engineers

Melville, NY Albany, NY
New City, NY Parsippany, NJ

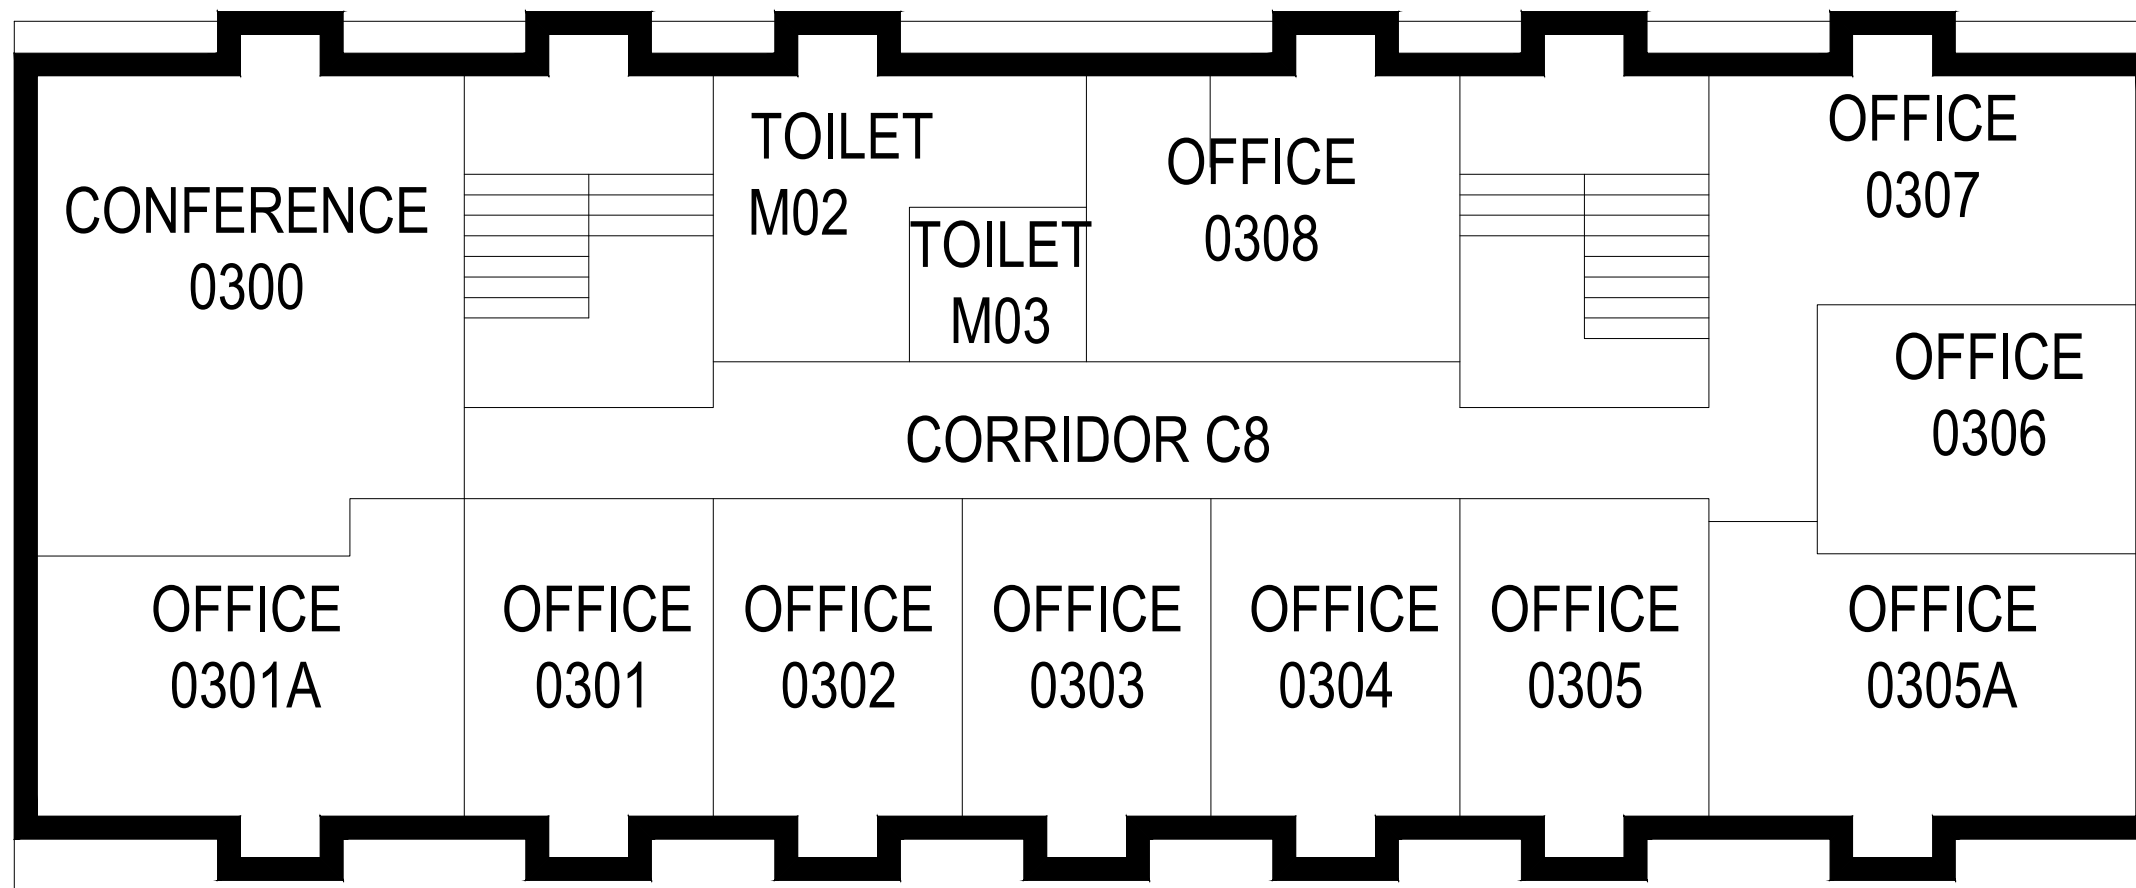

THIRD FLOOR PLAN



CLIENT

Farmingdale State College

SCALE:

1/8"=1'-0"

DATE:

JUNE-2015


Ward Hall- 011

REF. Drawing
SUFA 15-01



architects + engineers

Melville, NY Albany, NY
New City, NY Parsippany, NJ

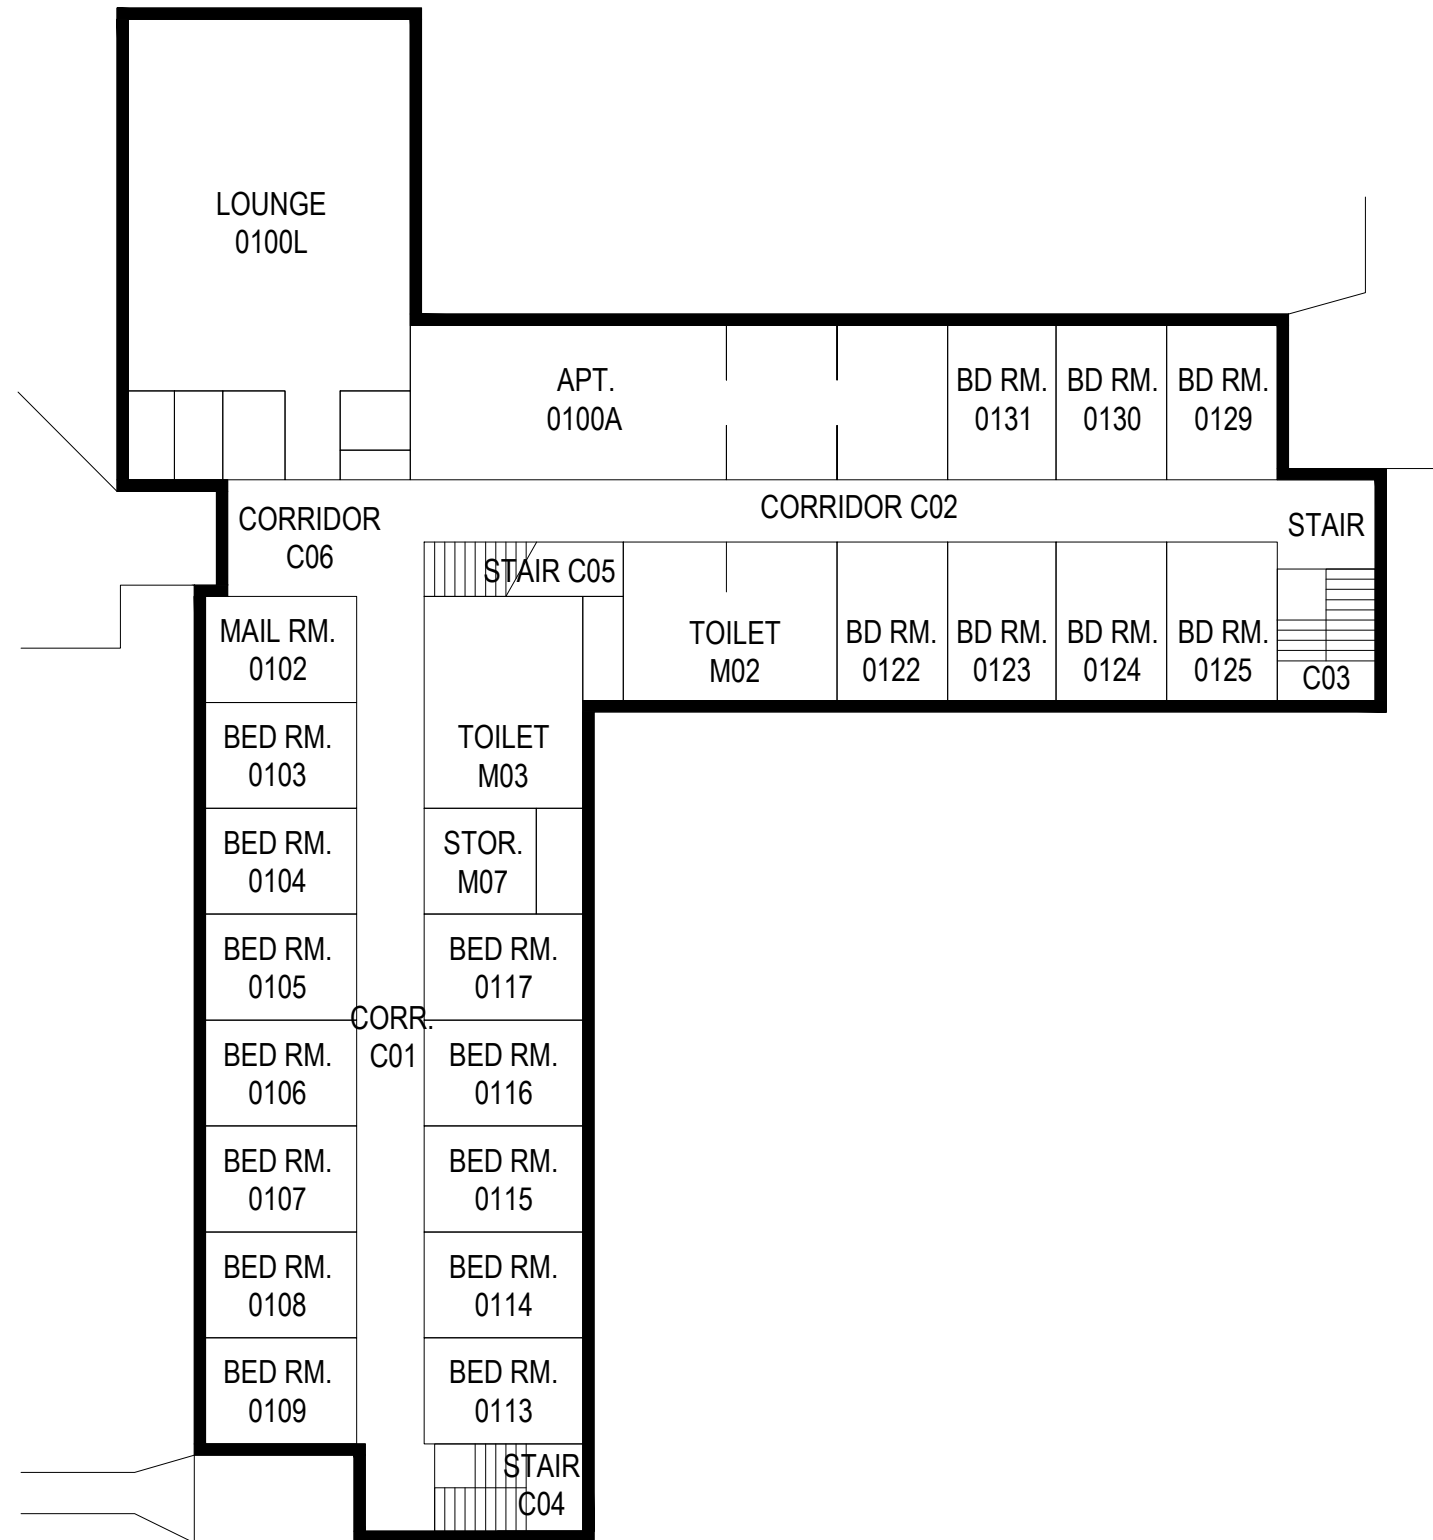

FIRST FLOOR PLAN



CLIENT

Farmingdale State College

SCALE:

1/16"=1'-0"

DATE:


JUNE-2015

Alumni Hall - 065



architects + engineers

Melville, NY Albany, NY
New City, NY Parsippany, NJ

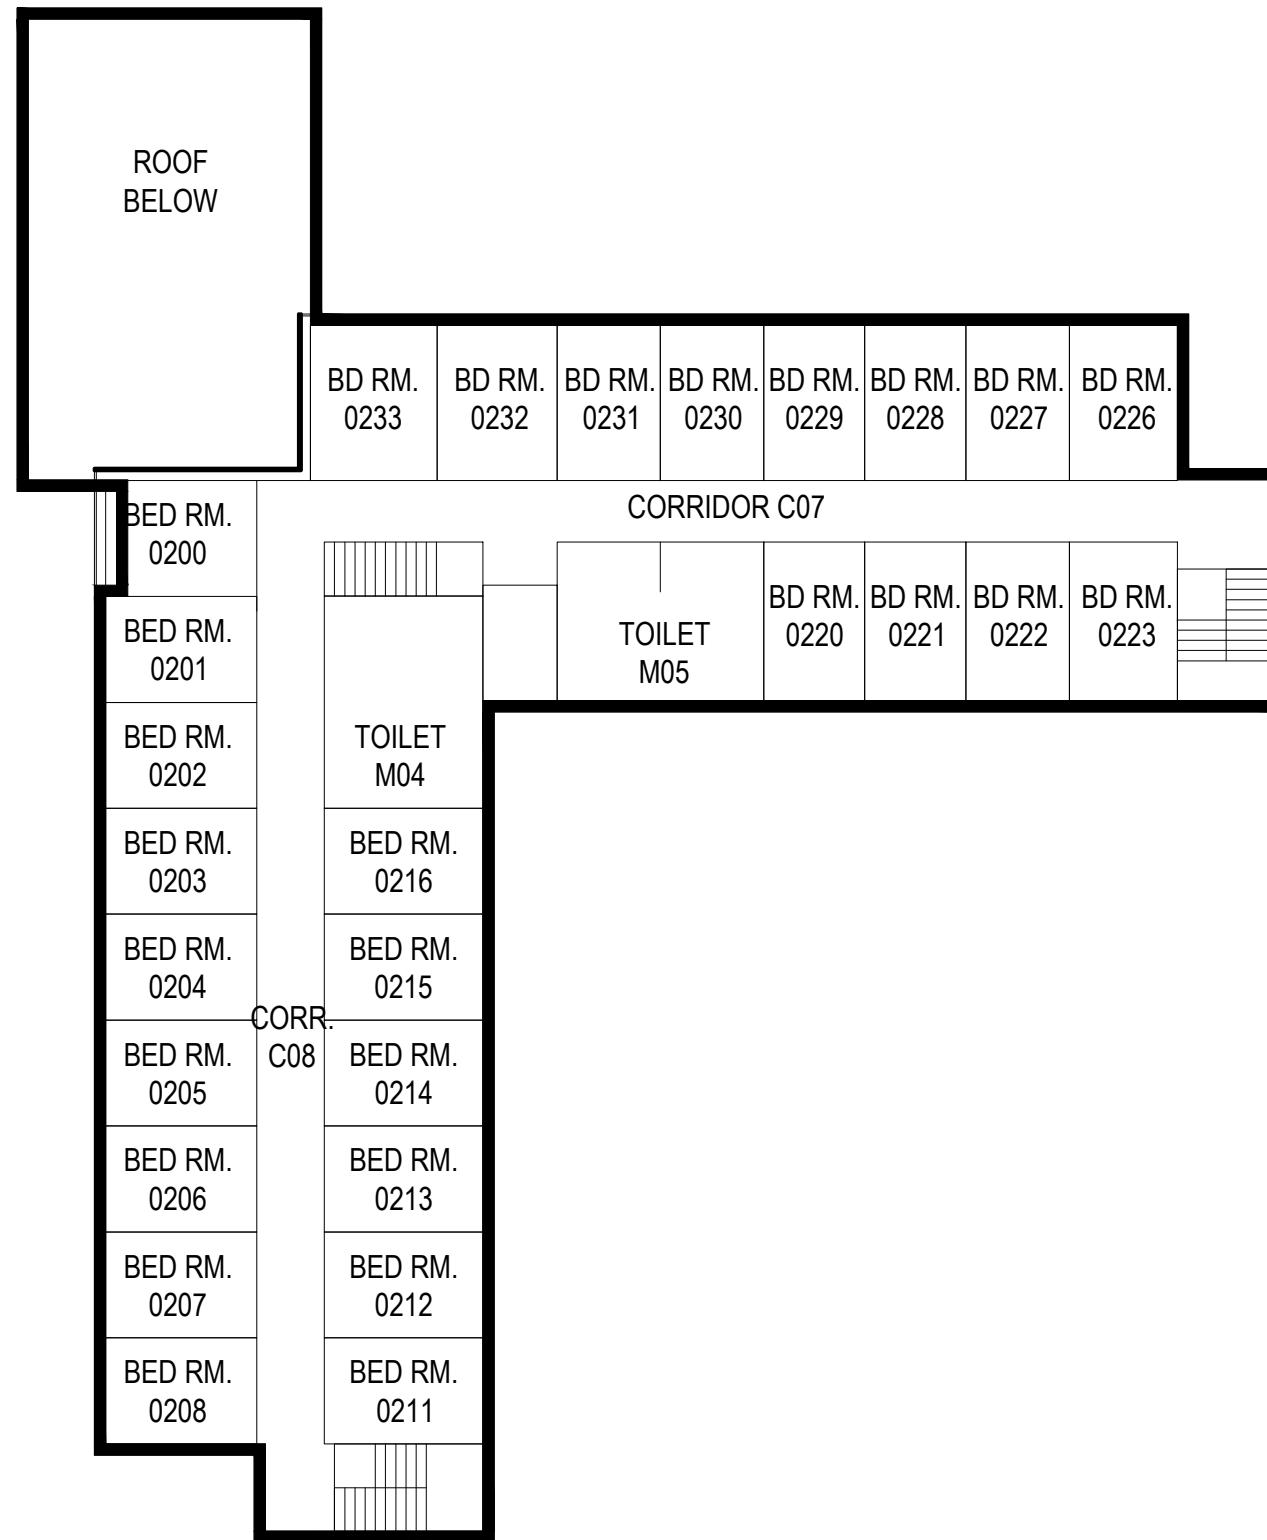

SECOND FLOOR PLAN



CLIENT

Farmingdale State College


SCALE:

1/16"=1'-0"

DATE:


JUNE-2015

Alumni Hall - 065

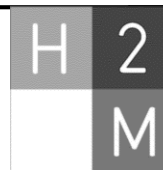

architects + engineers

Melville, NY Albany, NY
New City, NY Parsippany, NJ

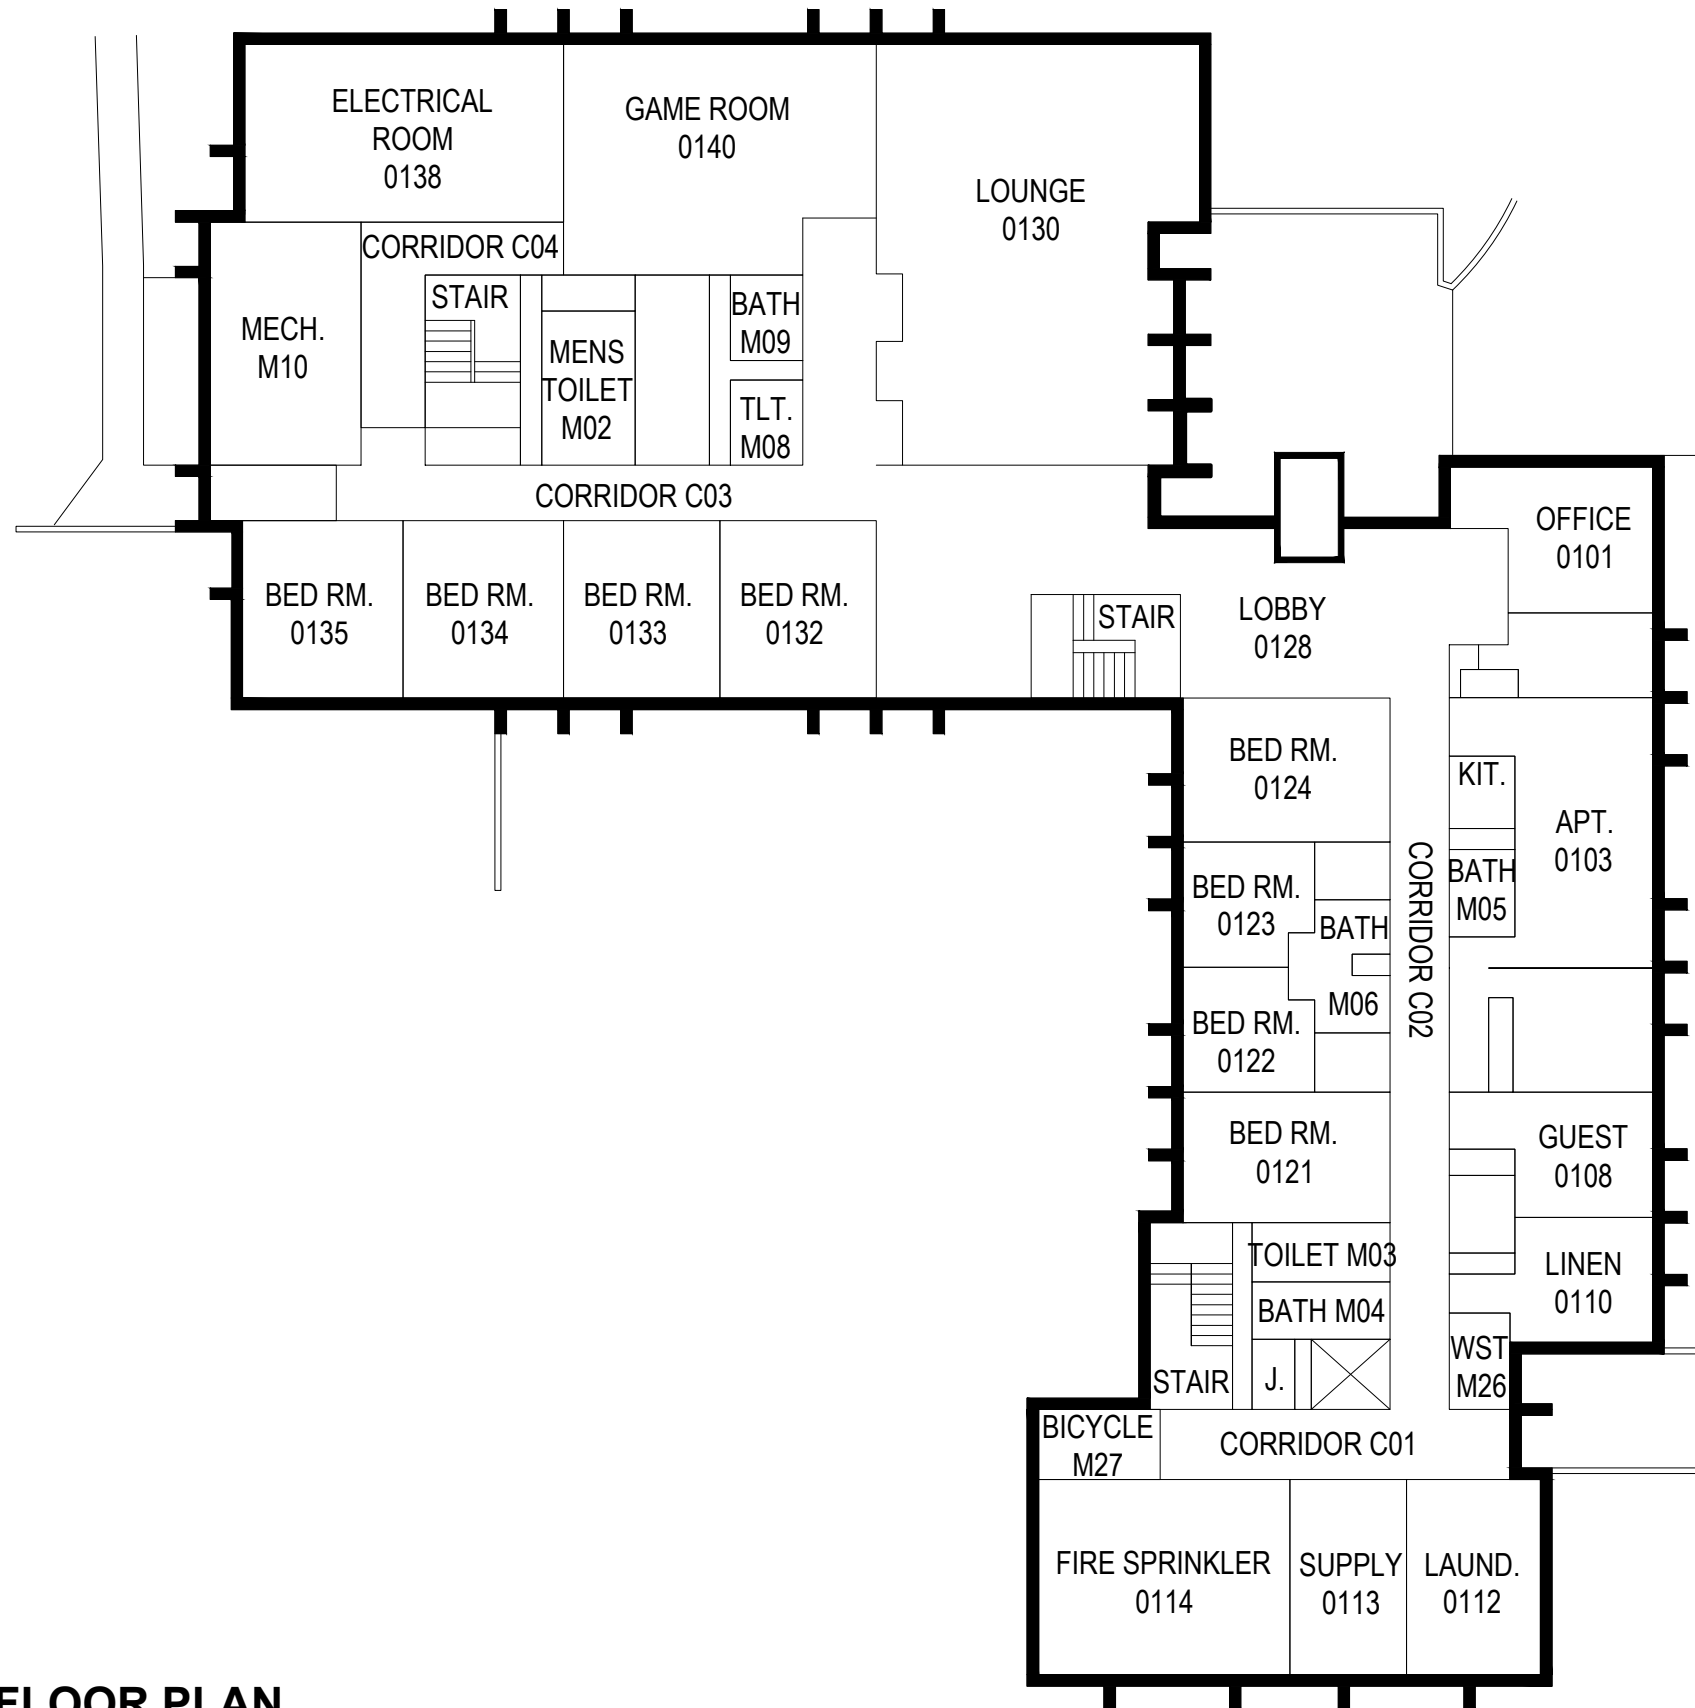

FIRST FLOOR PLAN



CLIENT

Farmingdale State College


SCALE:

1/16"=1'

DATE:


JUNE-2015

Dewey Hall- 091

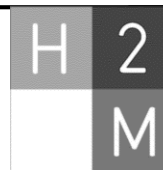

architects + engineers

Melville, NY Albany, NY
New City, NY Parsippany, NJ

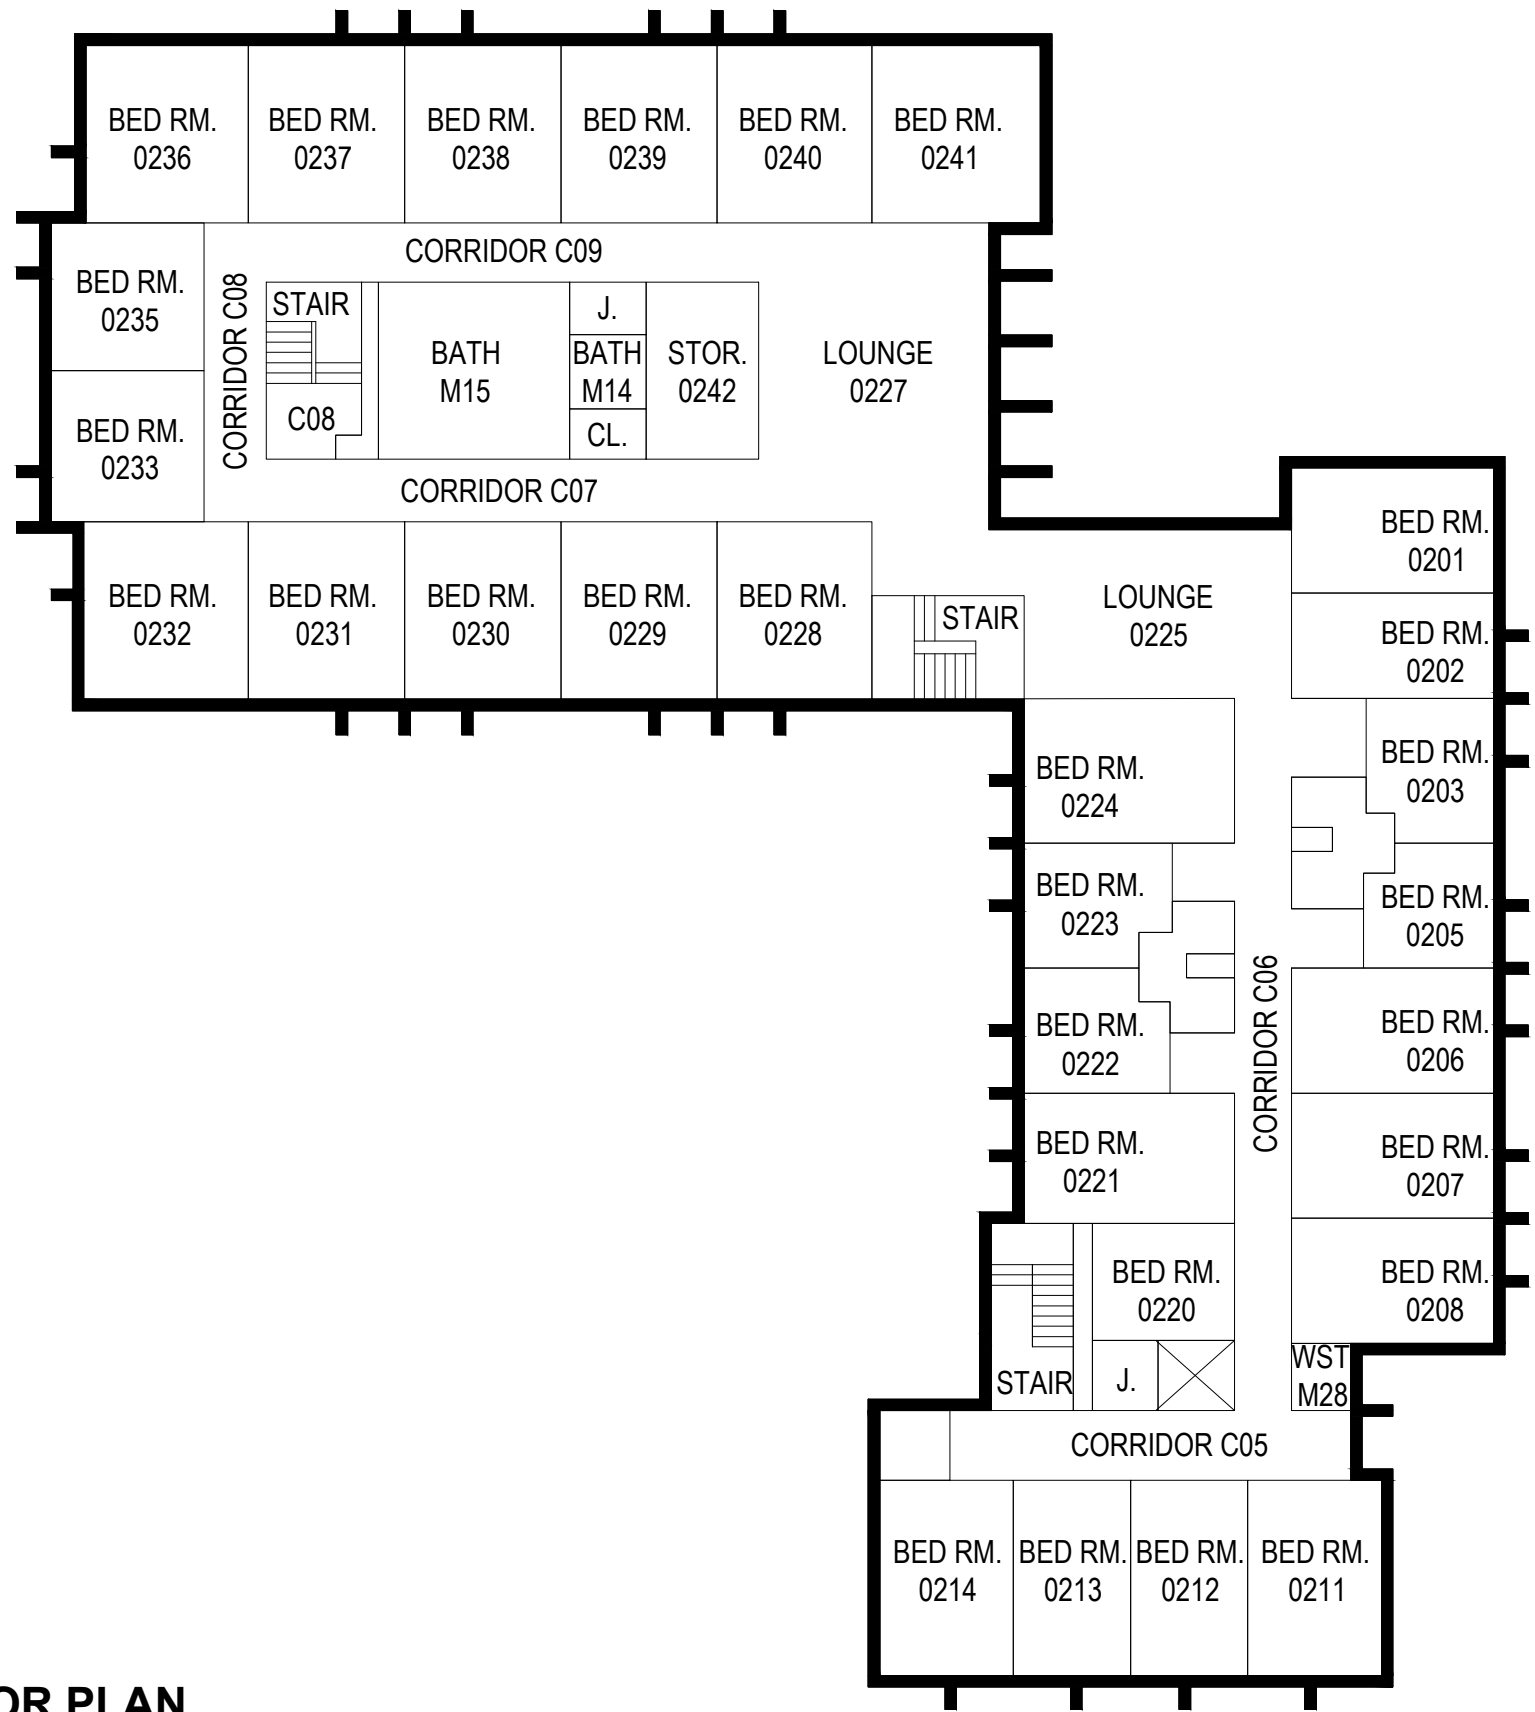

SECOND FLOOR PLAN



CLIENT

Farmingdale State College


SCALE:

1/16"=1'

DATE:


JUNE-2015

Dewey Hall- 091

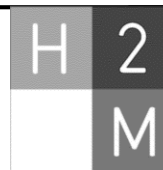

architects + engineers

Melville, NY Albany, NY
New City, NY Parsippany, NJ

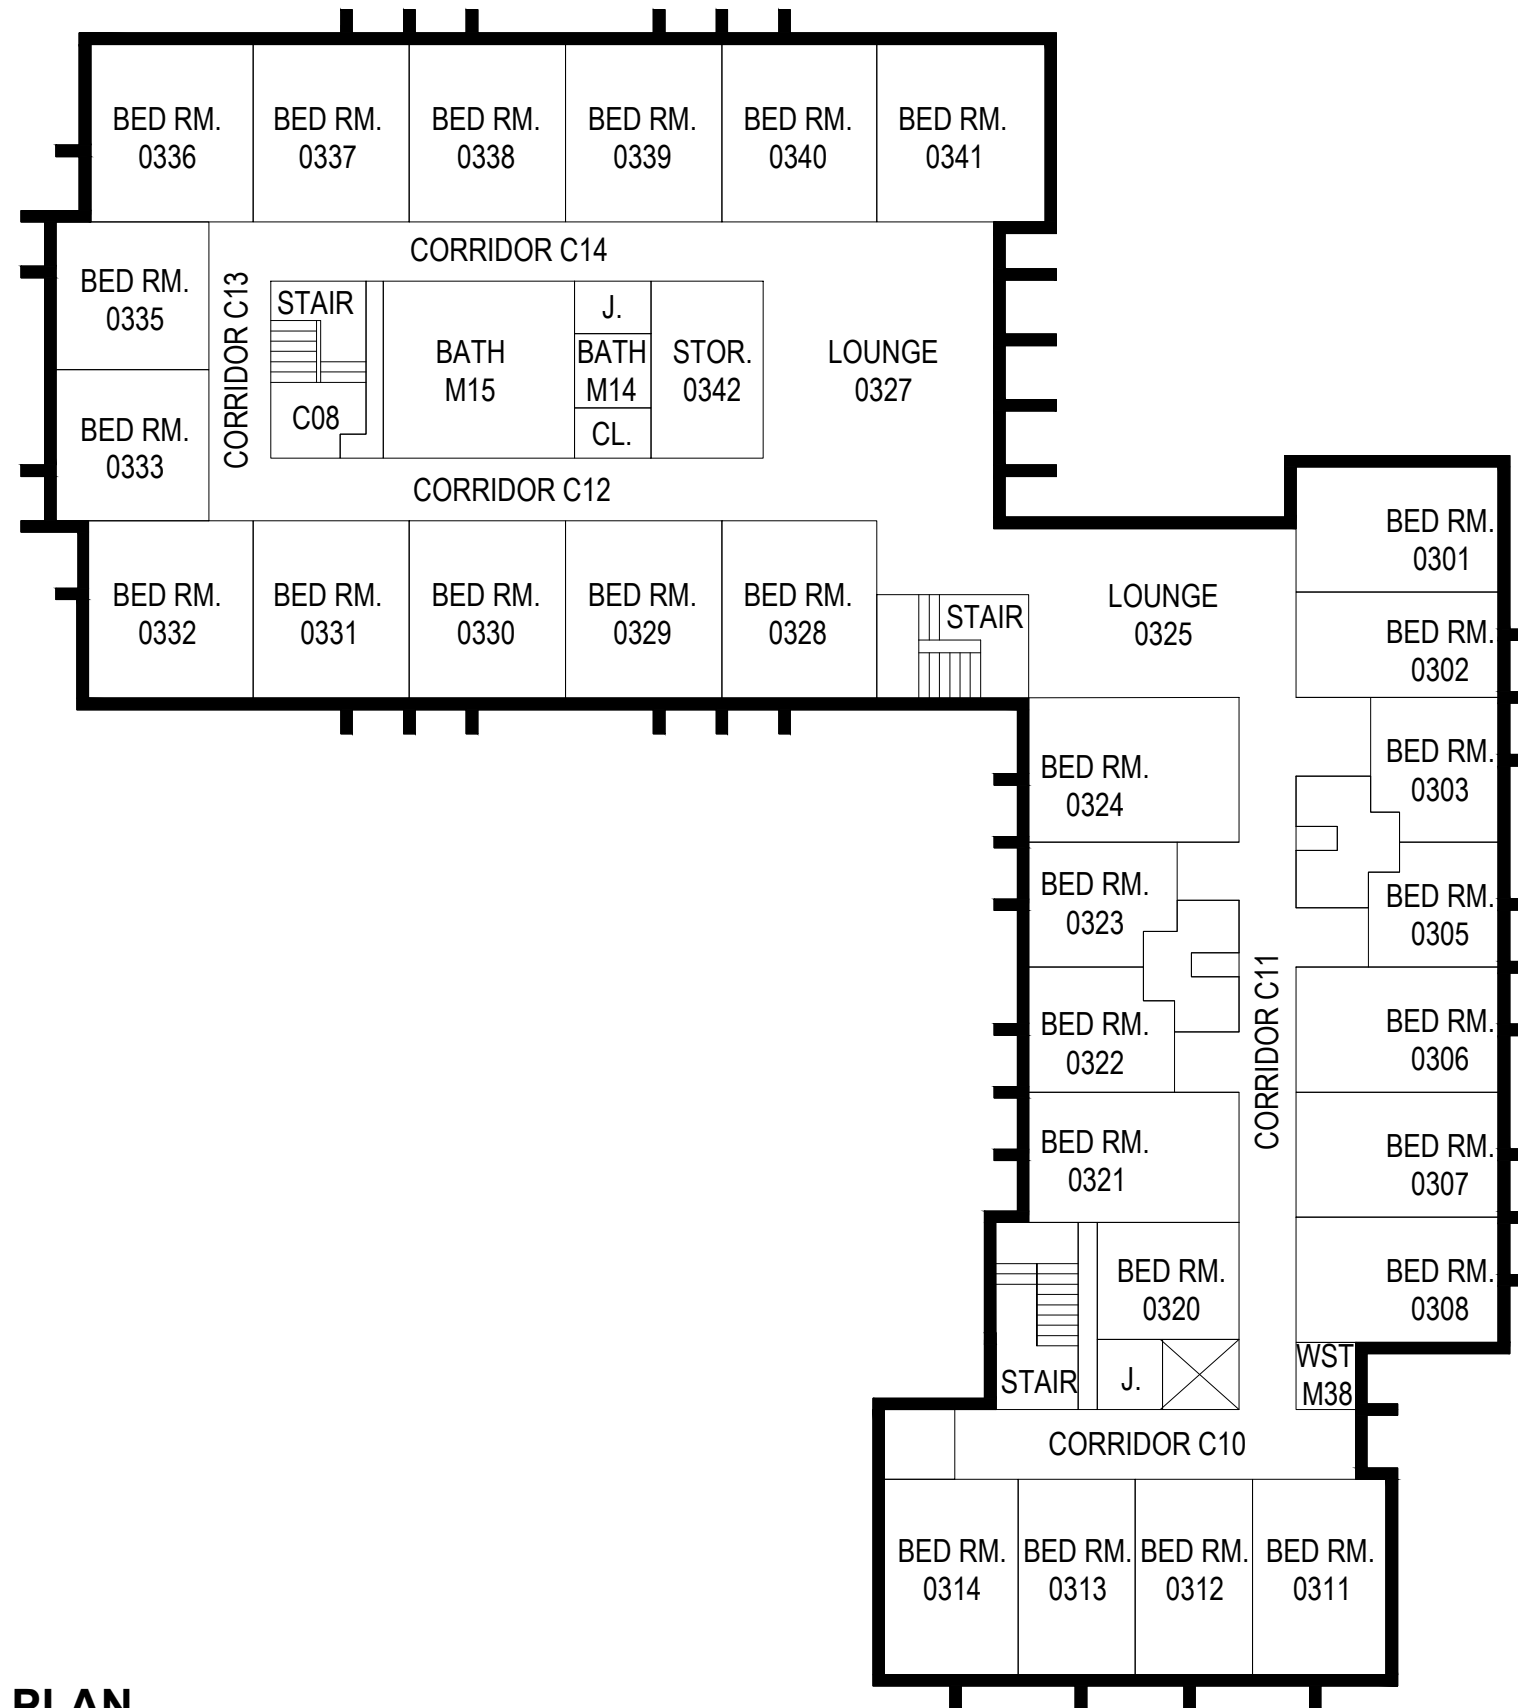

THIRD FLOOR PLAN



CLIENT

Farmingdale State College

SCALE:

1/16"=1'

DATE:


JUNE-2015

Dewey Hall- 091



architects + engineers

Melville, NY Albany, NY
New City, NY Parsippany, NJ

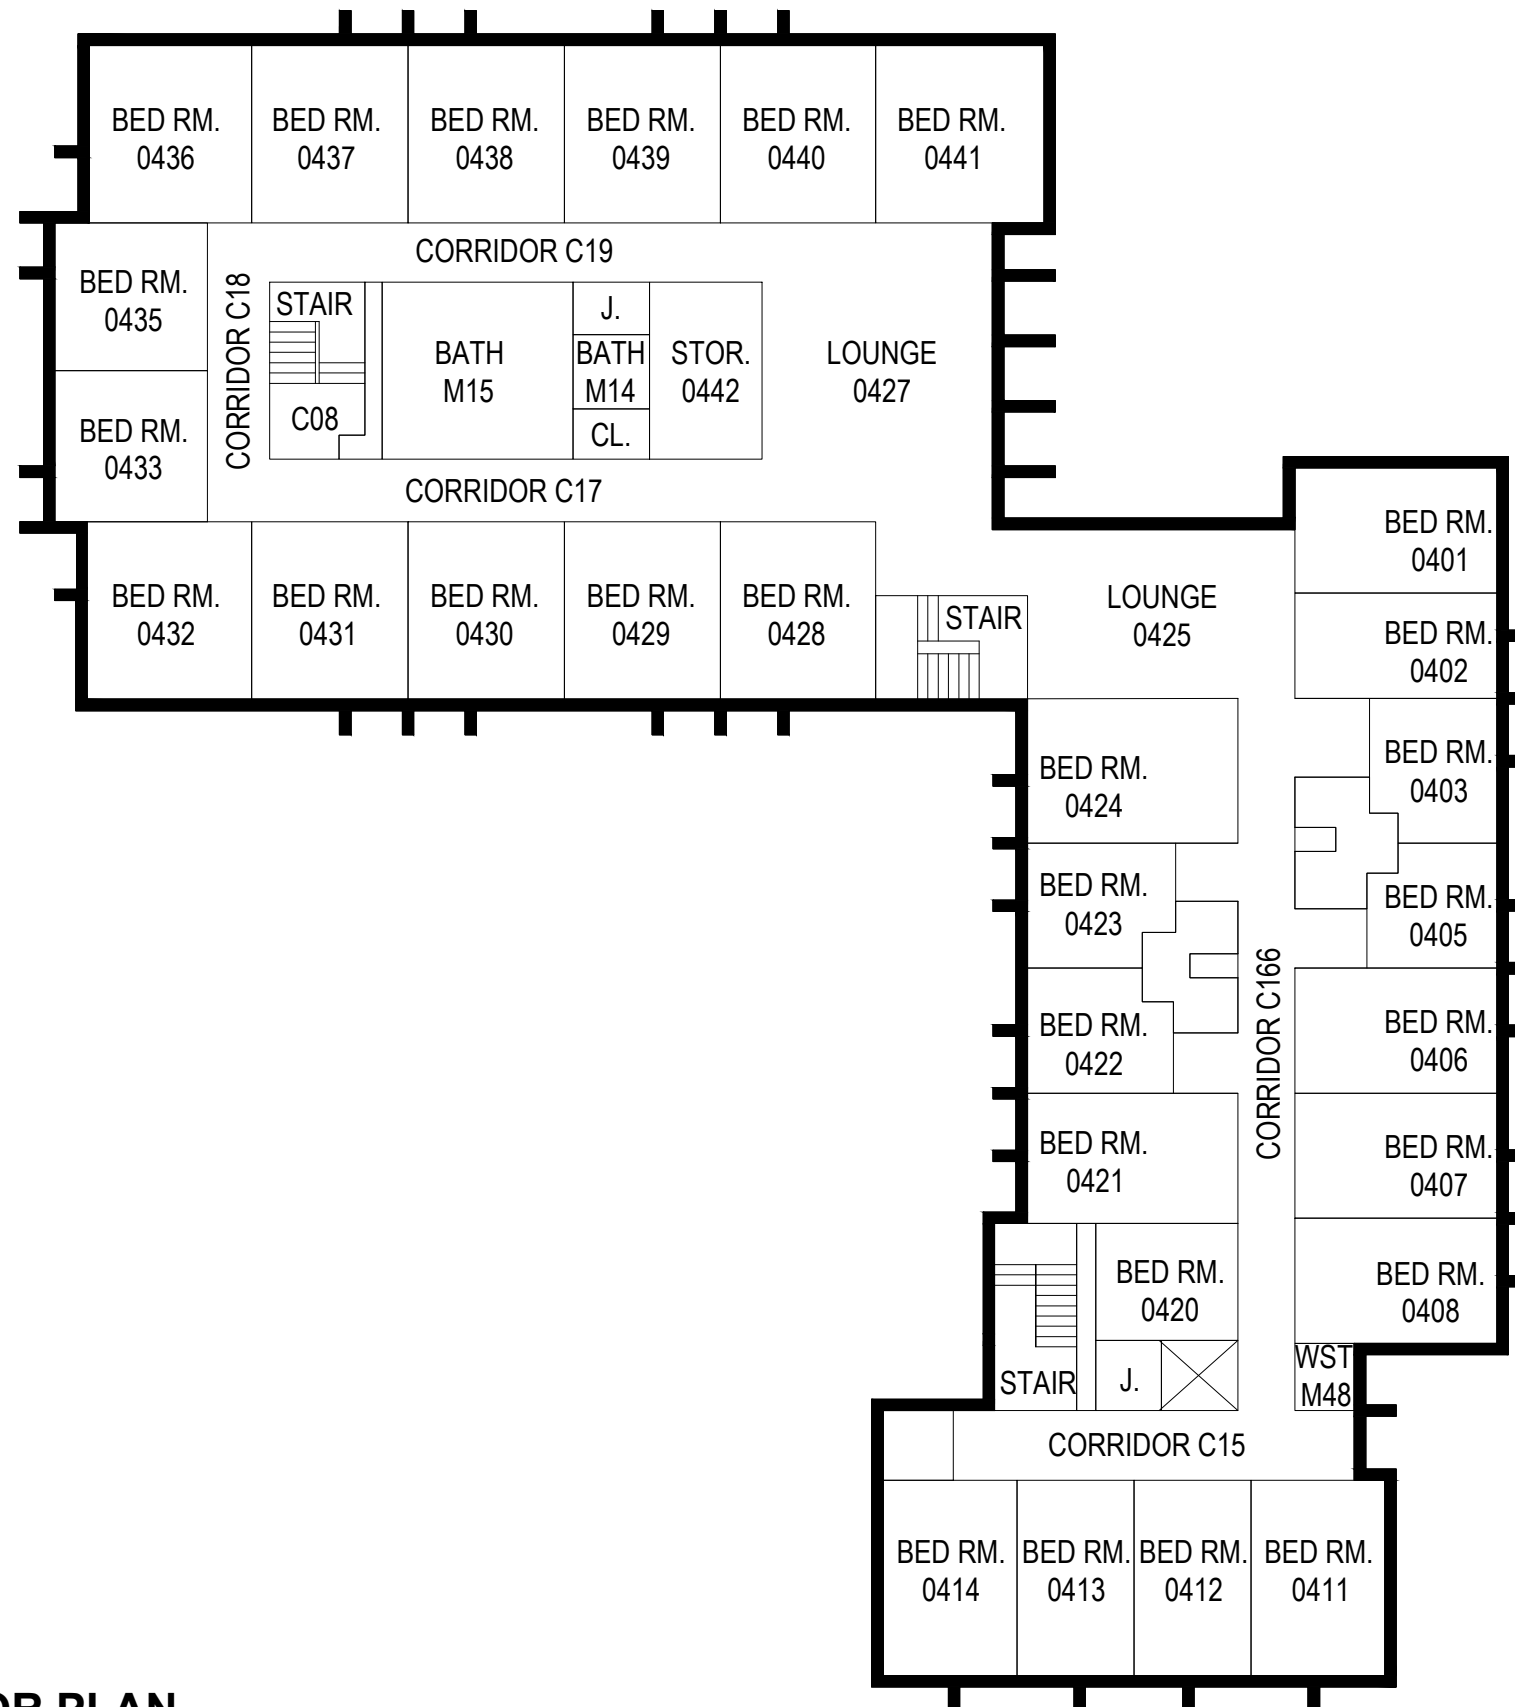

FOURTH FLOOR PLAN



CLIENT

Farmingdale State College

SCALE:


1/16"=1'

DATE:

JUNE-2015

Dewey Hall- 091

H	2	architects + engineers Melville, NY Albany, NY New City, NY Parsippany, NJ
M	M	

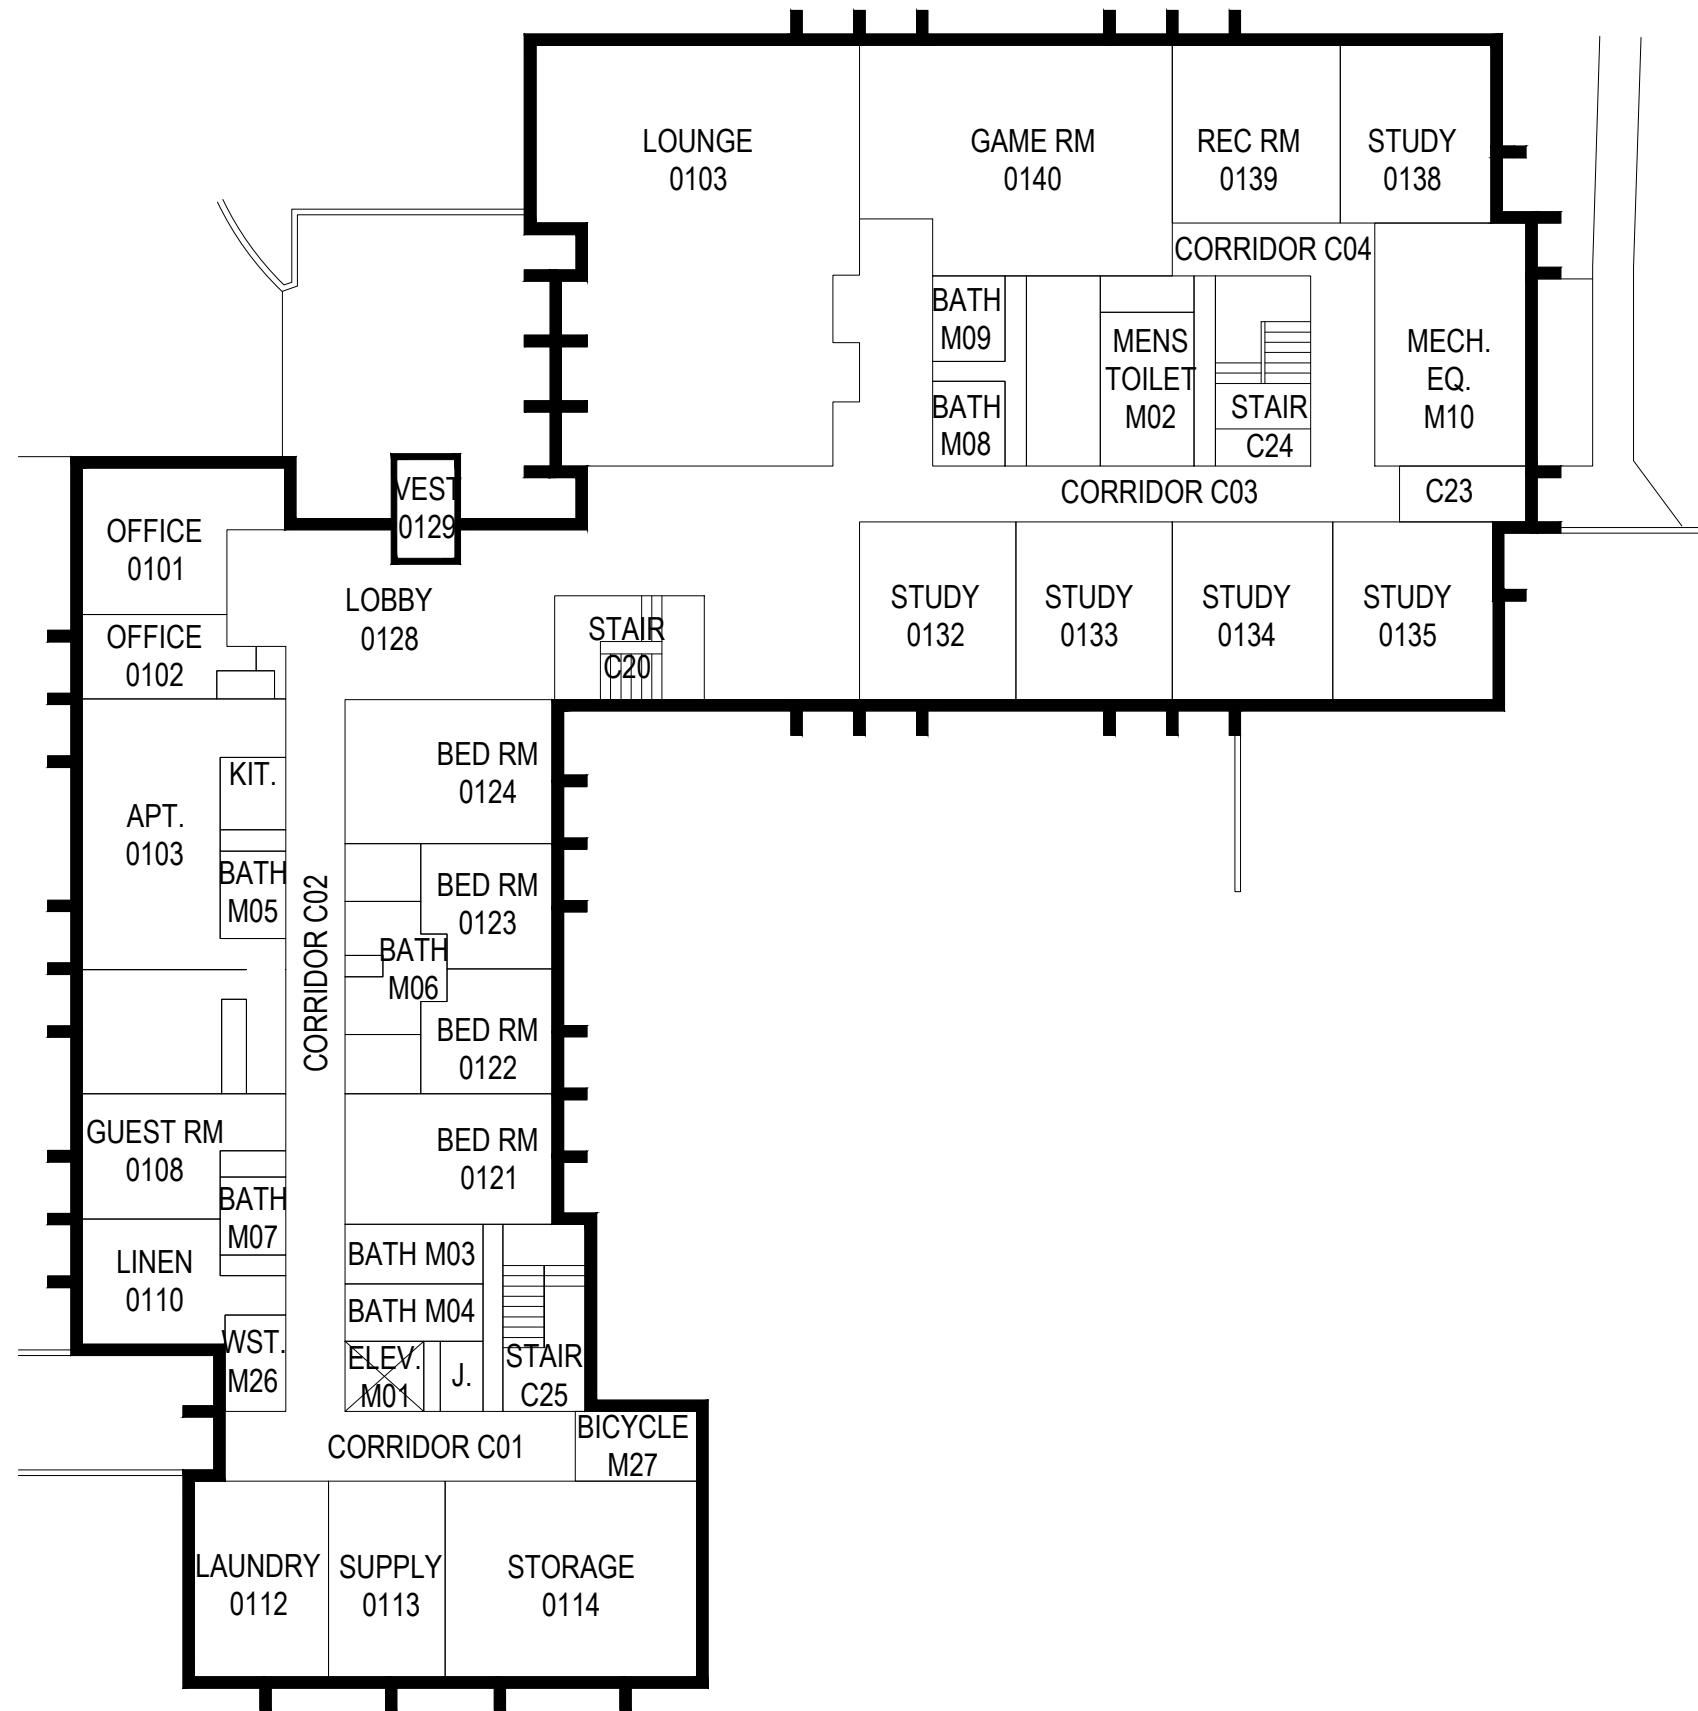

FIRST FLOOR PLAN



CLIENT

Farmingdale State College


SCALE:

1/16"=1'-0"

DATE:


JUNE-2015

Lehman Hall - 092

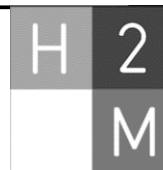

architects + engineers

Melville, NY Albany, NY
New City, NY Parsippany, NJ

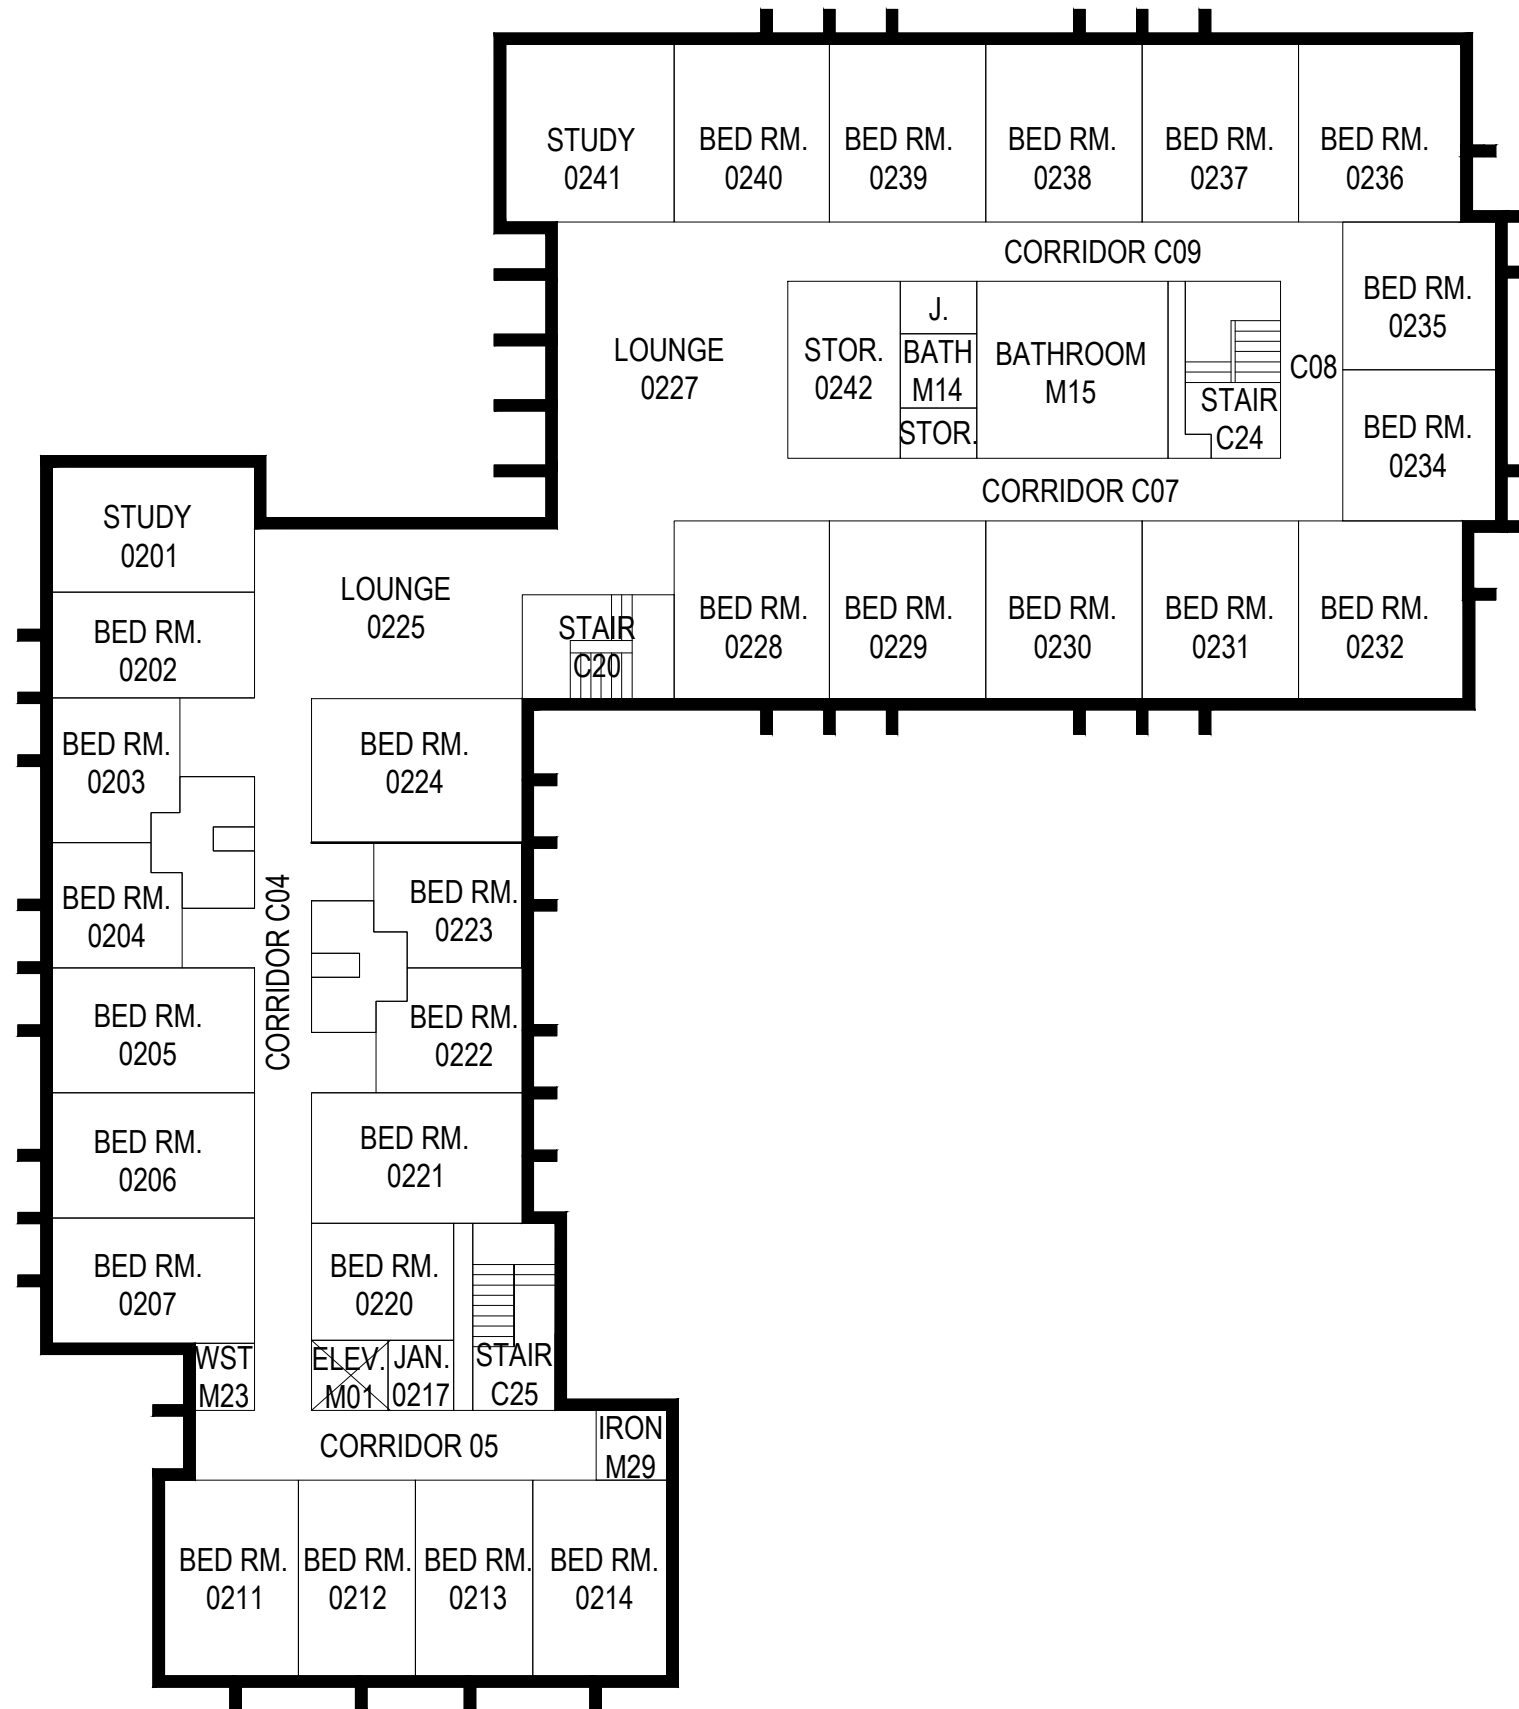

SECOND FLOOR PLAN



CLIENT

Farmingdale State College

SCALE:


1"=20'

DATE:

JUNE-2015

Lehman Hall - 092

H	2	architects + engineers
M	M	
Melville, NY New City, NY		Albany, NY Parsippany, NJ

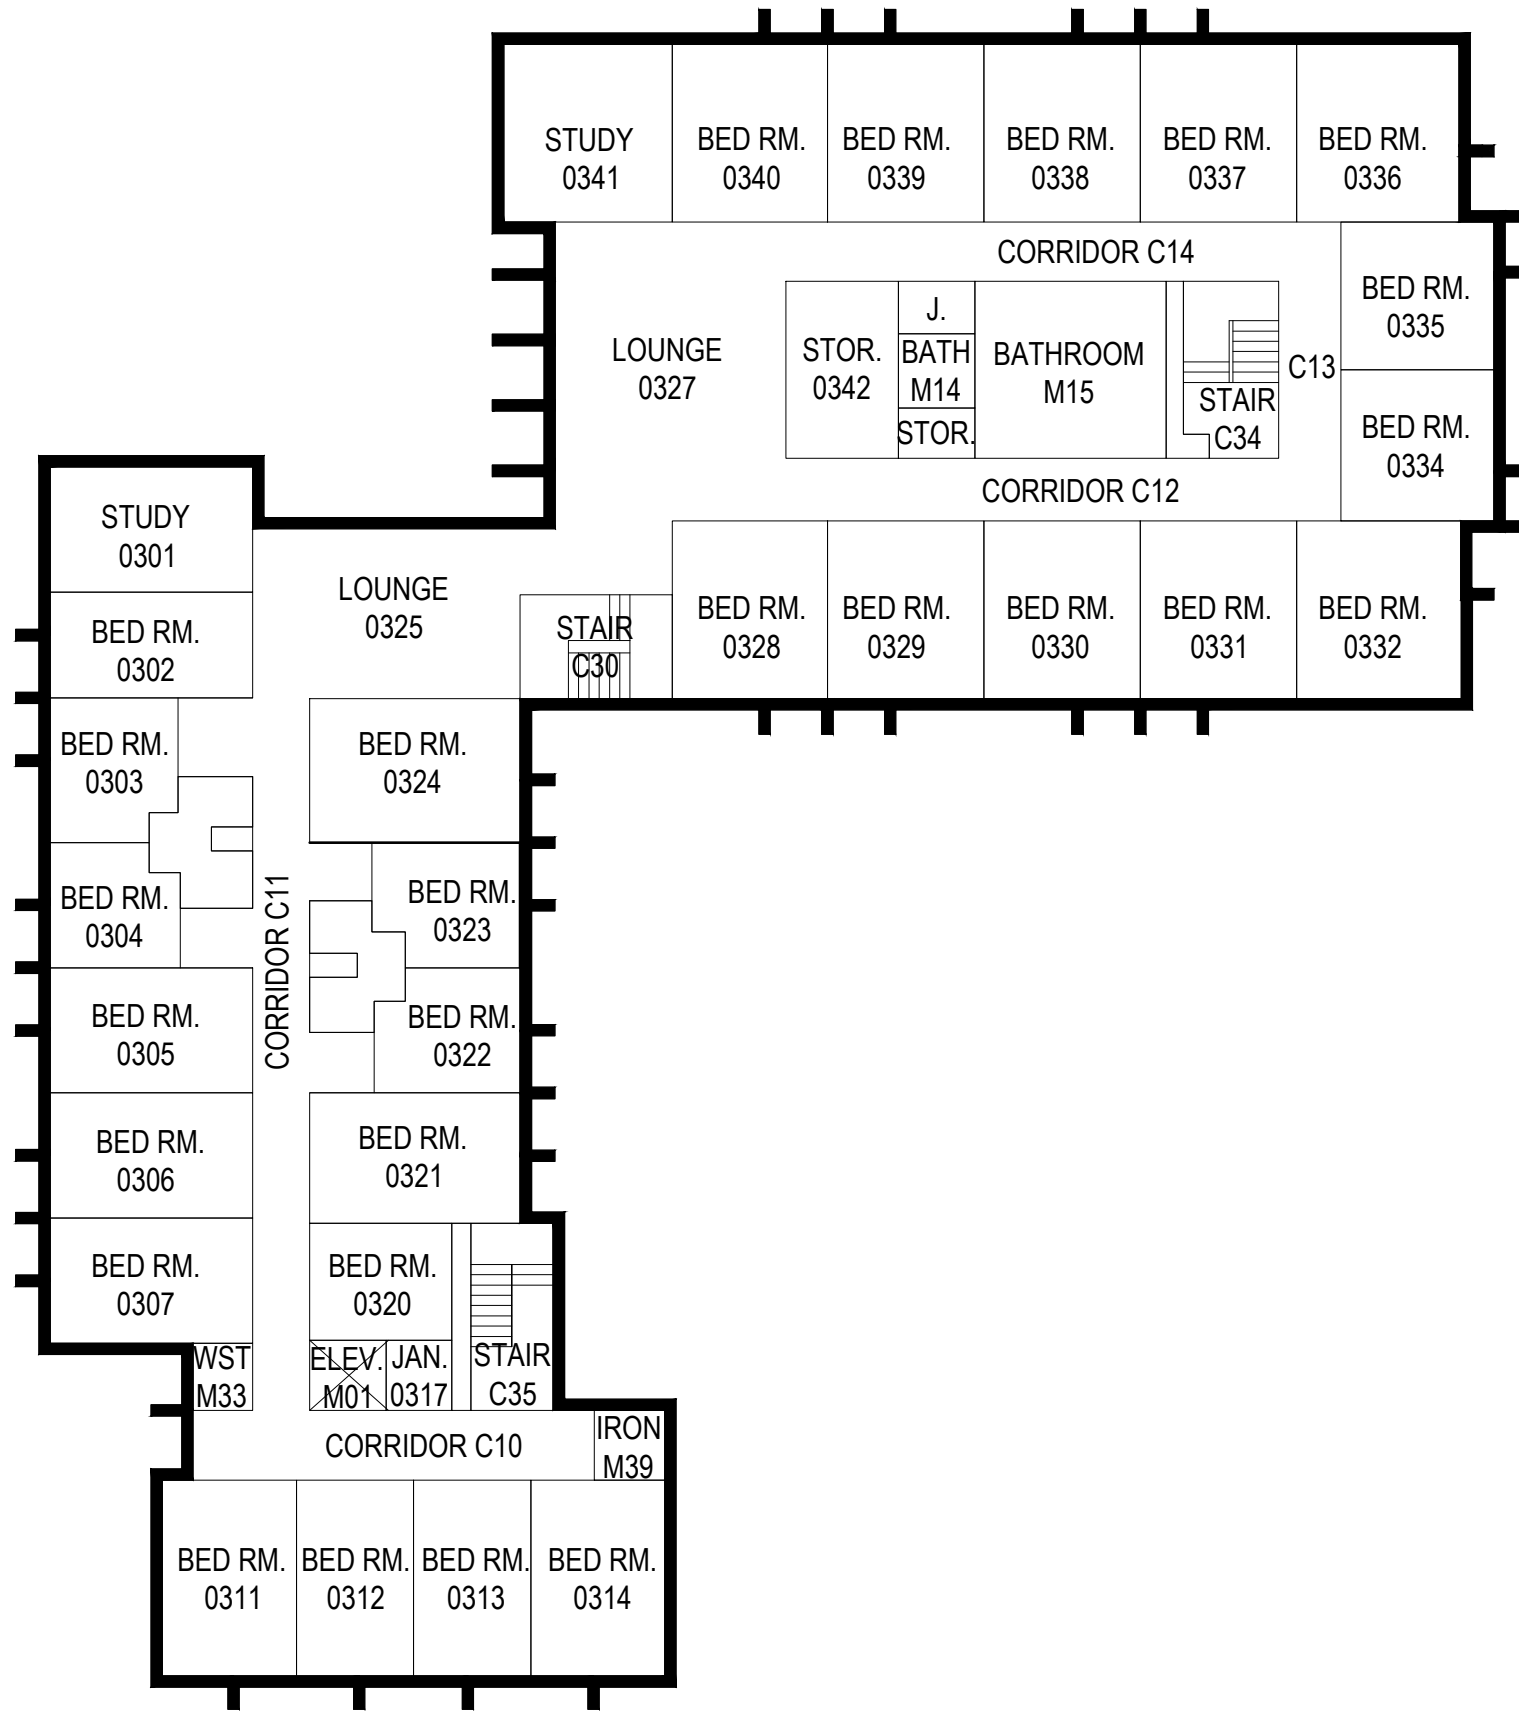

THIRD FLOOR PLAN



CLIENT

Farmingdale State College


SCALE:

1"=20'

DATE:


JUNE-2015

Lehman Hall - 092

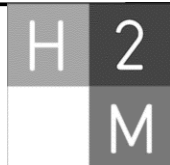

architects + engineers

Melville, NY Albany, NY
New City, NY Parsippany, NJ

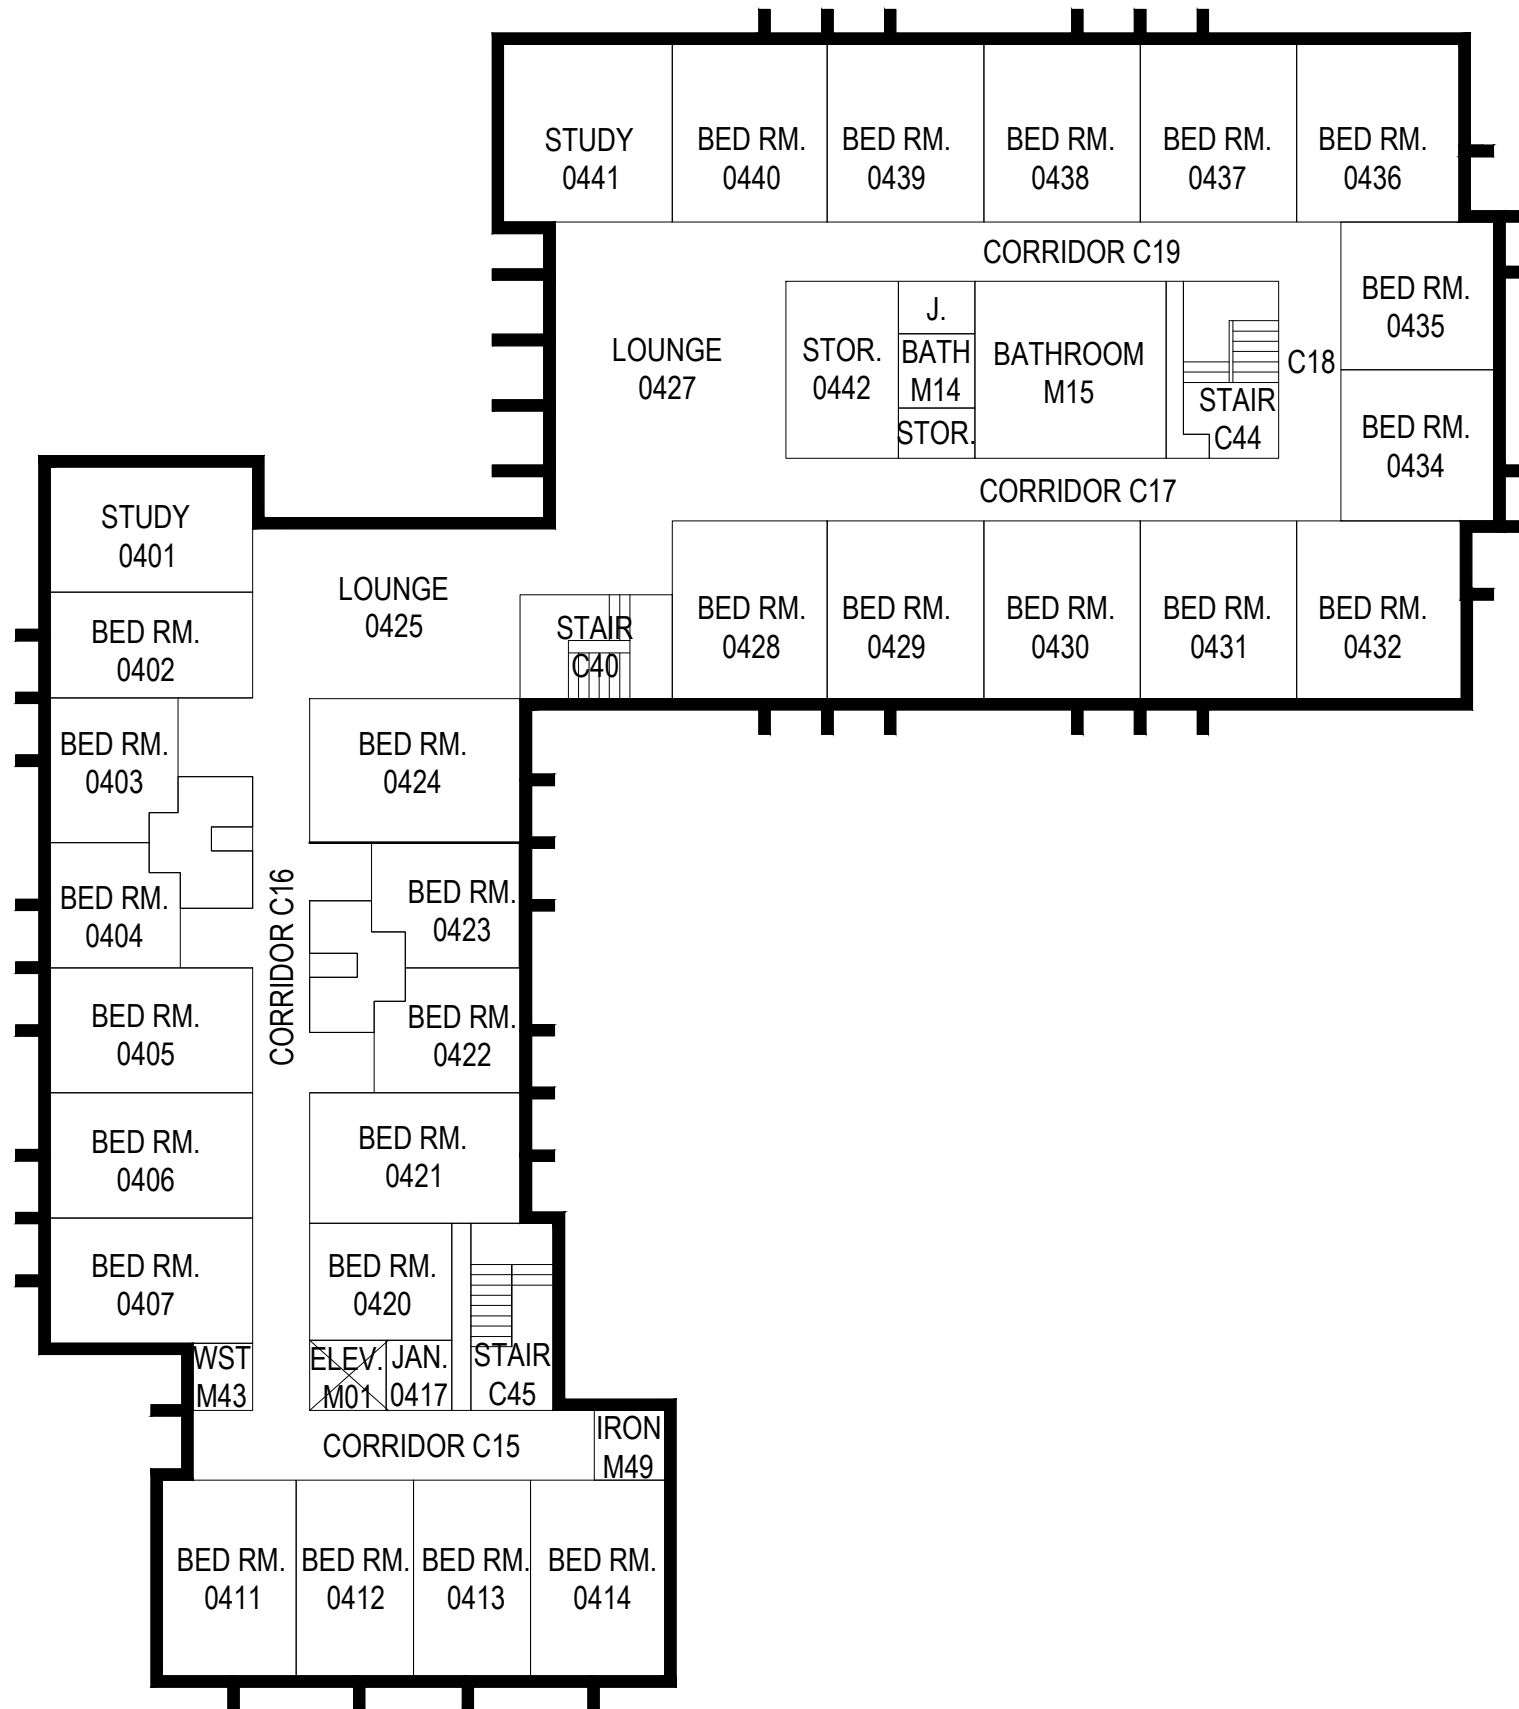

FOURTH FLOOR PLAN



CLIENT

Farmingdale State College

SCALE:

1"=20'

DATE:


JUNE-2015

Lehman Hall - 092



architects + engineers

Melville, NY Albany, NY
New City, NY Parsippany, NJ

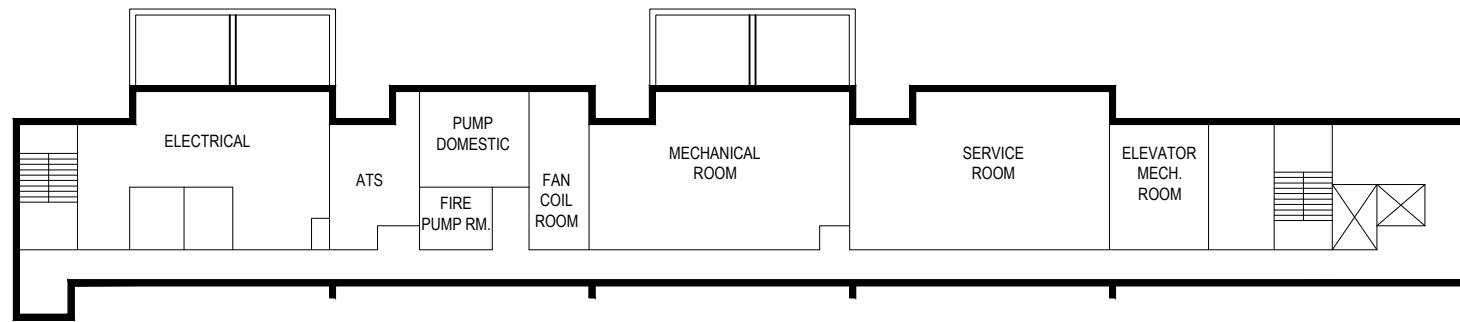

BASEMENT FLOOR PLAN



CLIENT

Farmingdale State College

SCALE:

1"=30'

DATE:

JUNE-2015


Orchard Hall - 115



architects + engineers

Melville, NY Albany, NY
New City, NY Parsippany, NJ

93

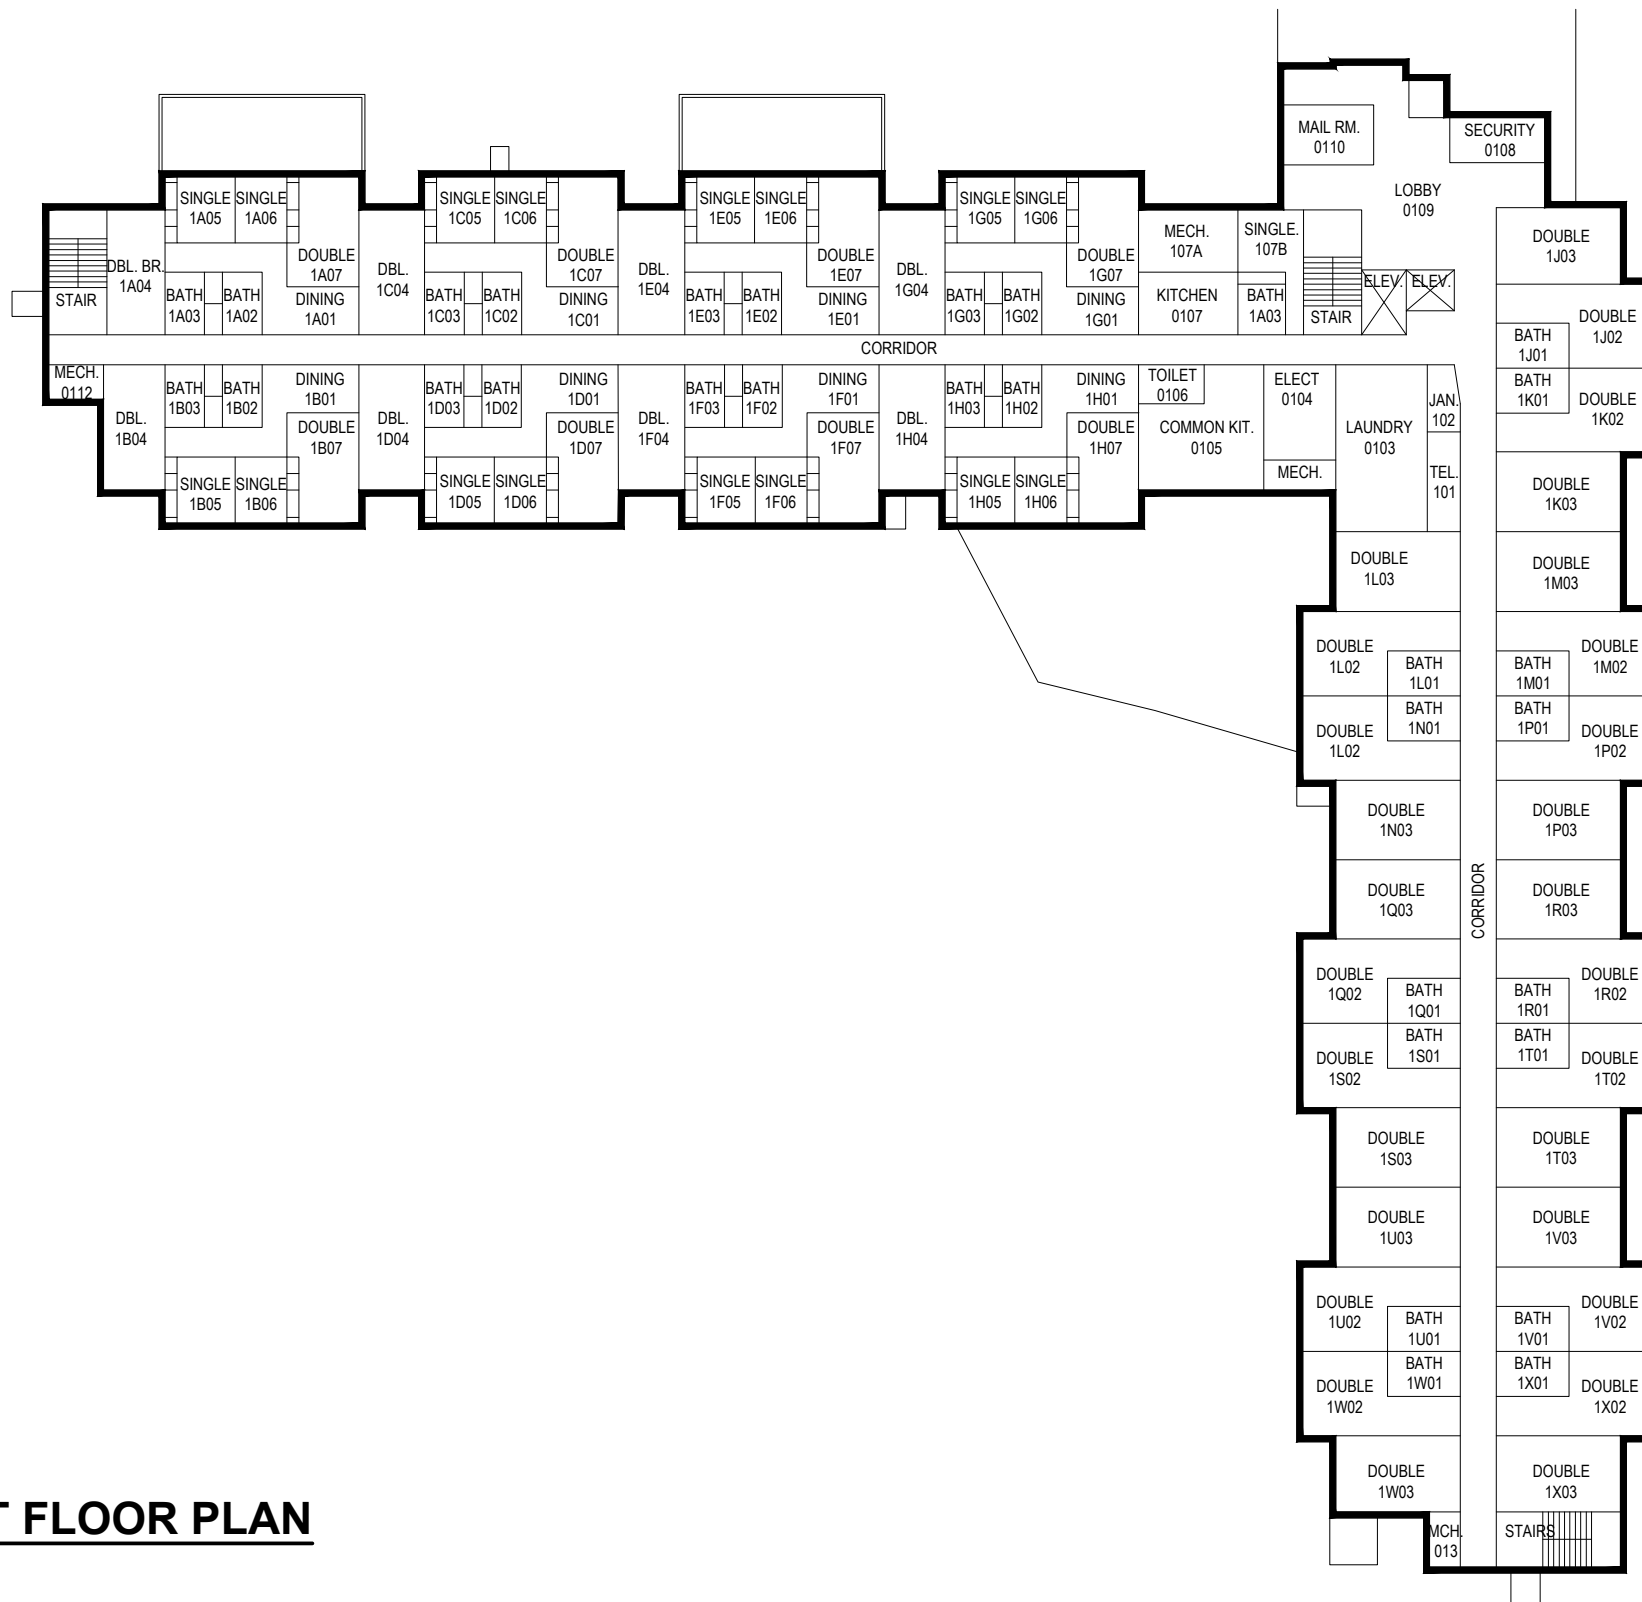

FIRST FLOOR PLAN

CLIENT

Farmingdale State College

SCALE:


1"=30'

DATE:

JUNE-2015

Orchard Hall - 115

H	2	architects + engineers
M	M	
Melville, NY Albany, NY New City, NY Parsippany, NJ		

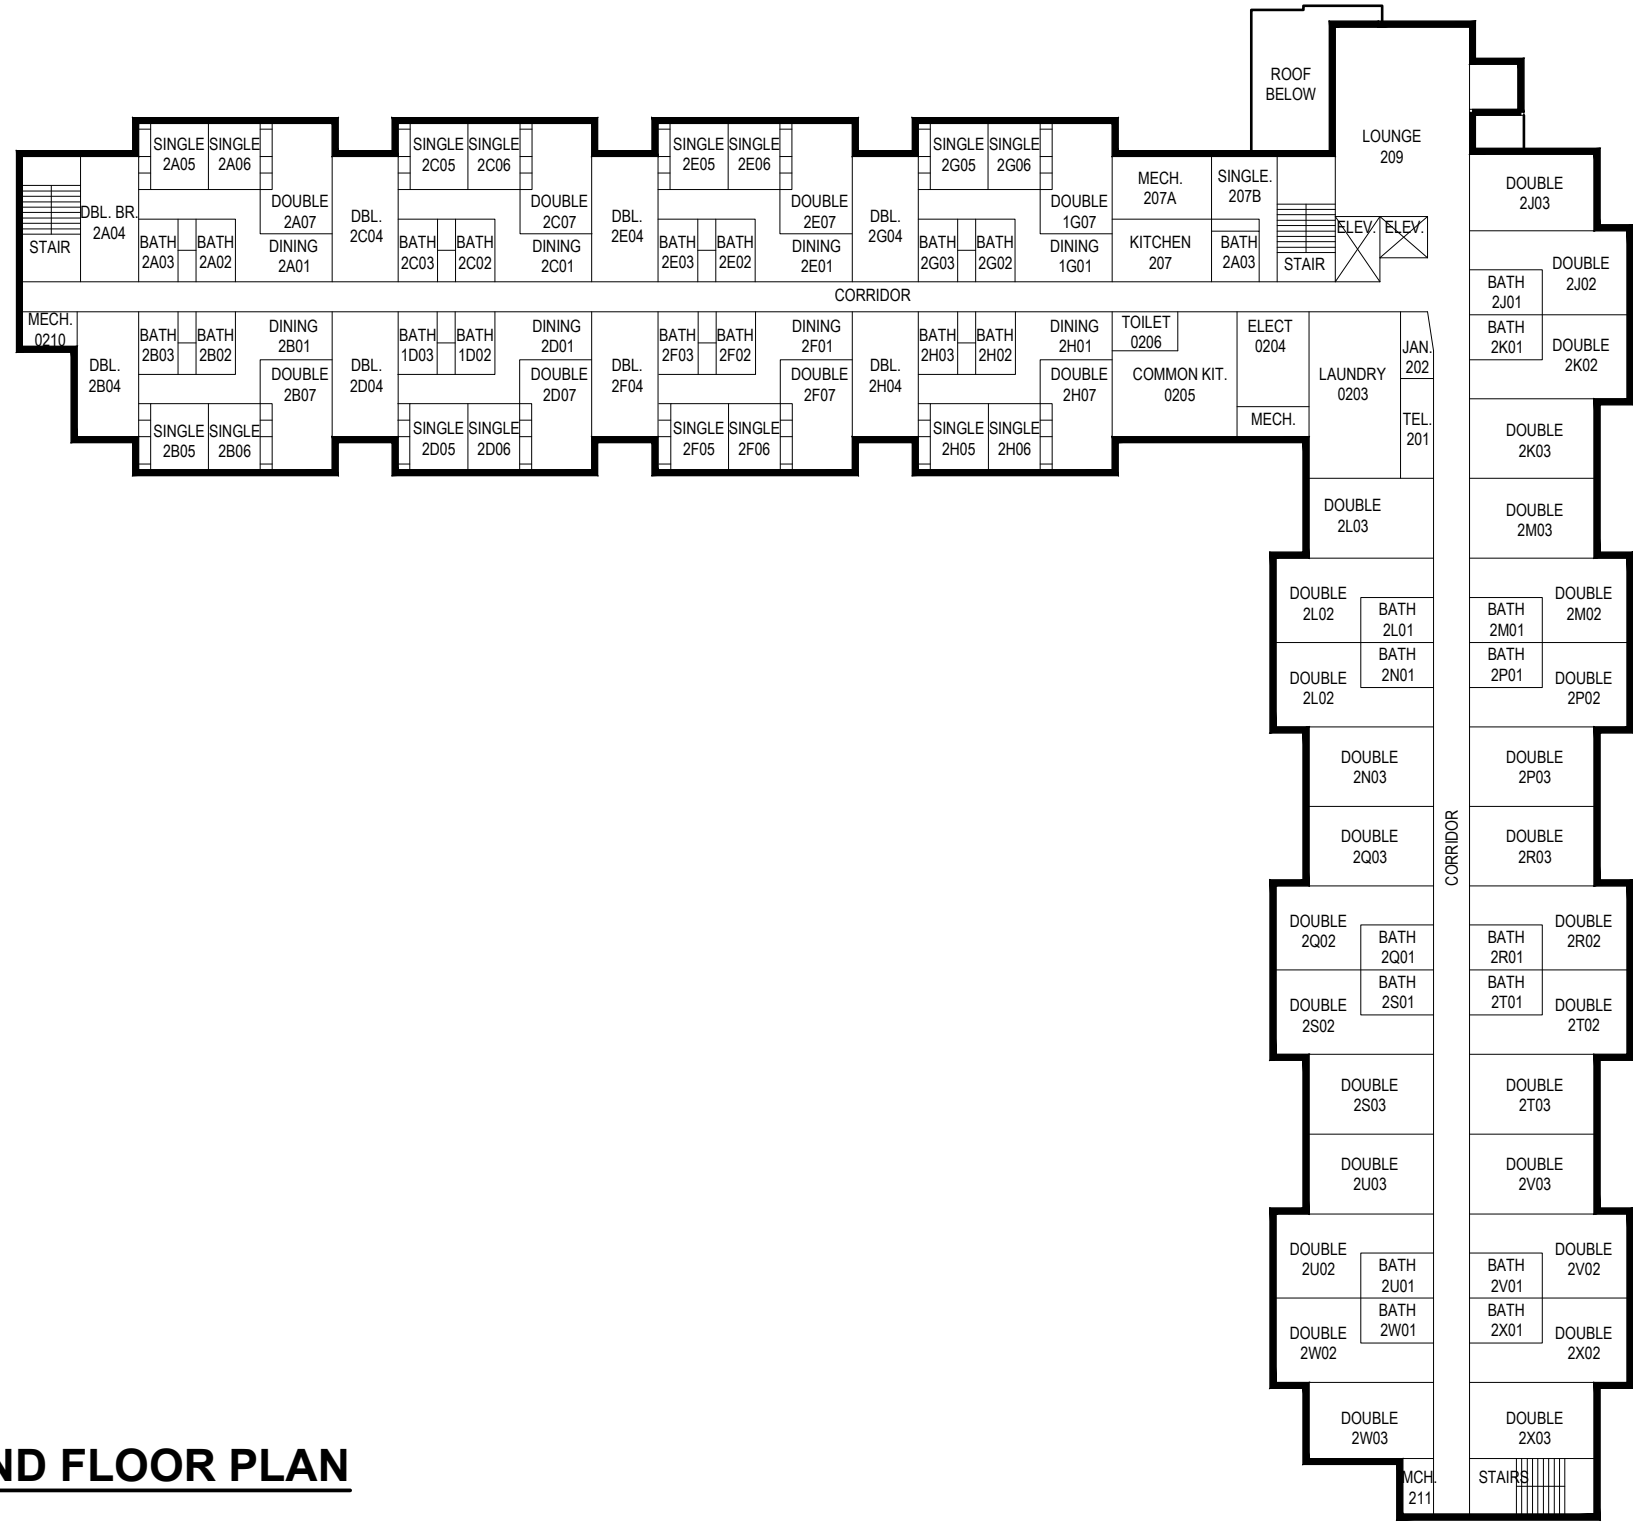

SECOND FLOOR PLAN




CLIENT
Farmingdale State College

SCALE:
1"=30'
 DATE:
JUNE-2015

Orchard Hall - 115

H 2 M
 architects + engineers
 Melville, NY Albany, NY
 New City, NY Parsippany, NJ

95

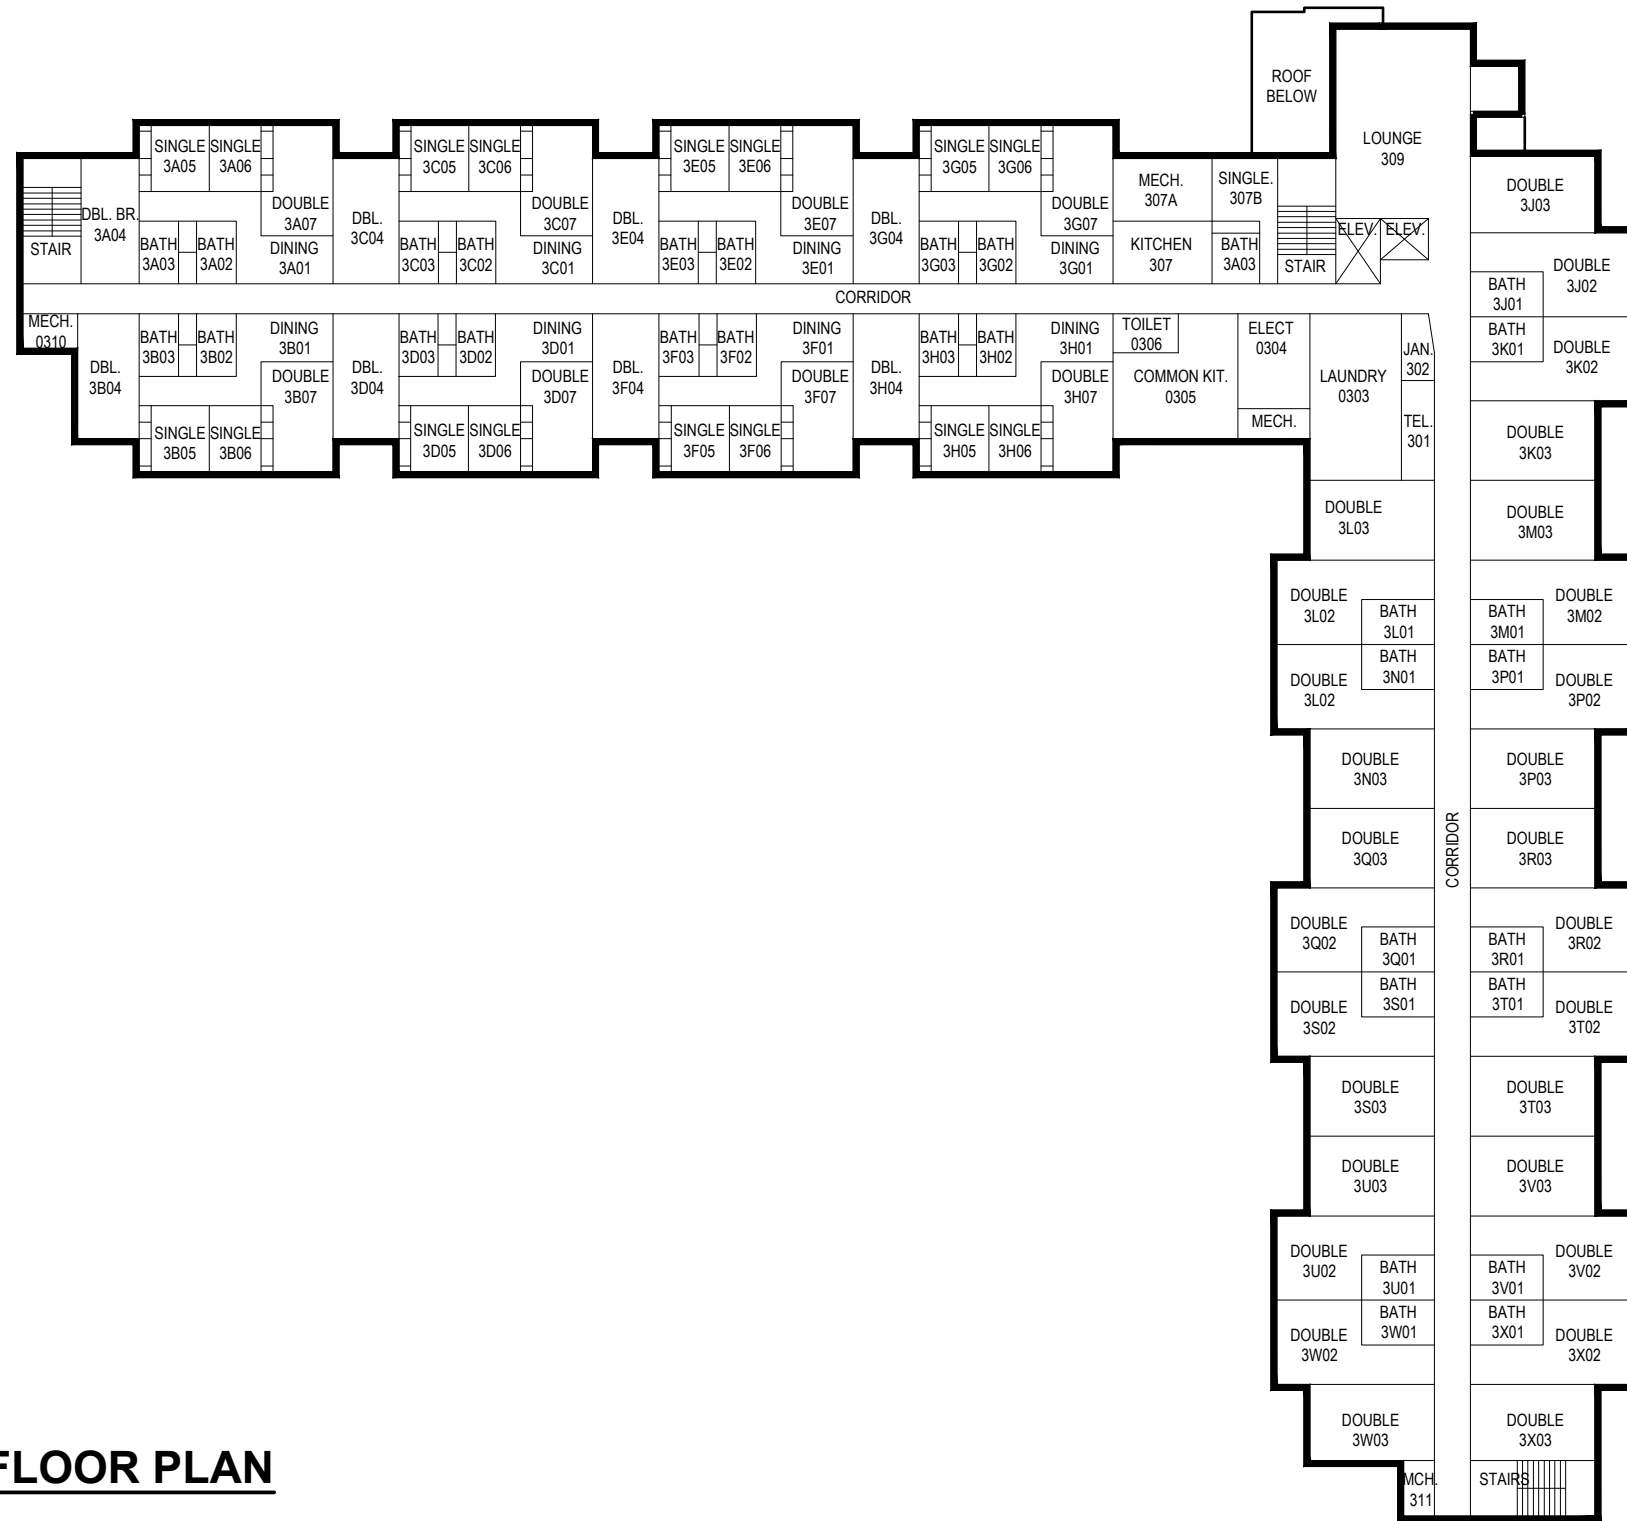

THIRD FLOOR PLAN



CLIENT

Farmingdale State College

SCALE:

1"=30'

DATE:


JUNE-2015

Orchard Hall - 115



architects + engineers

Melville, NY Albany, NY
New City, NY Parsippany, NJ

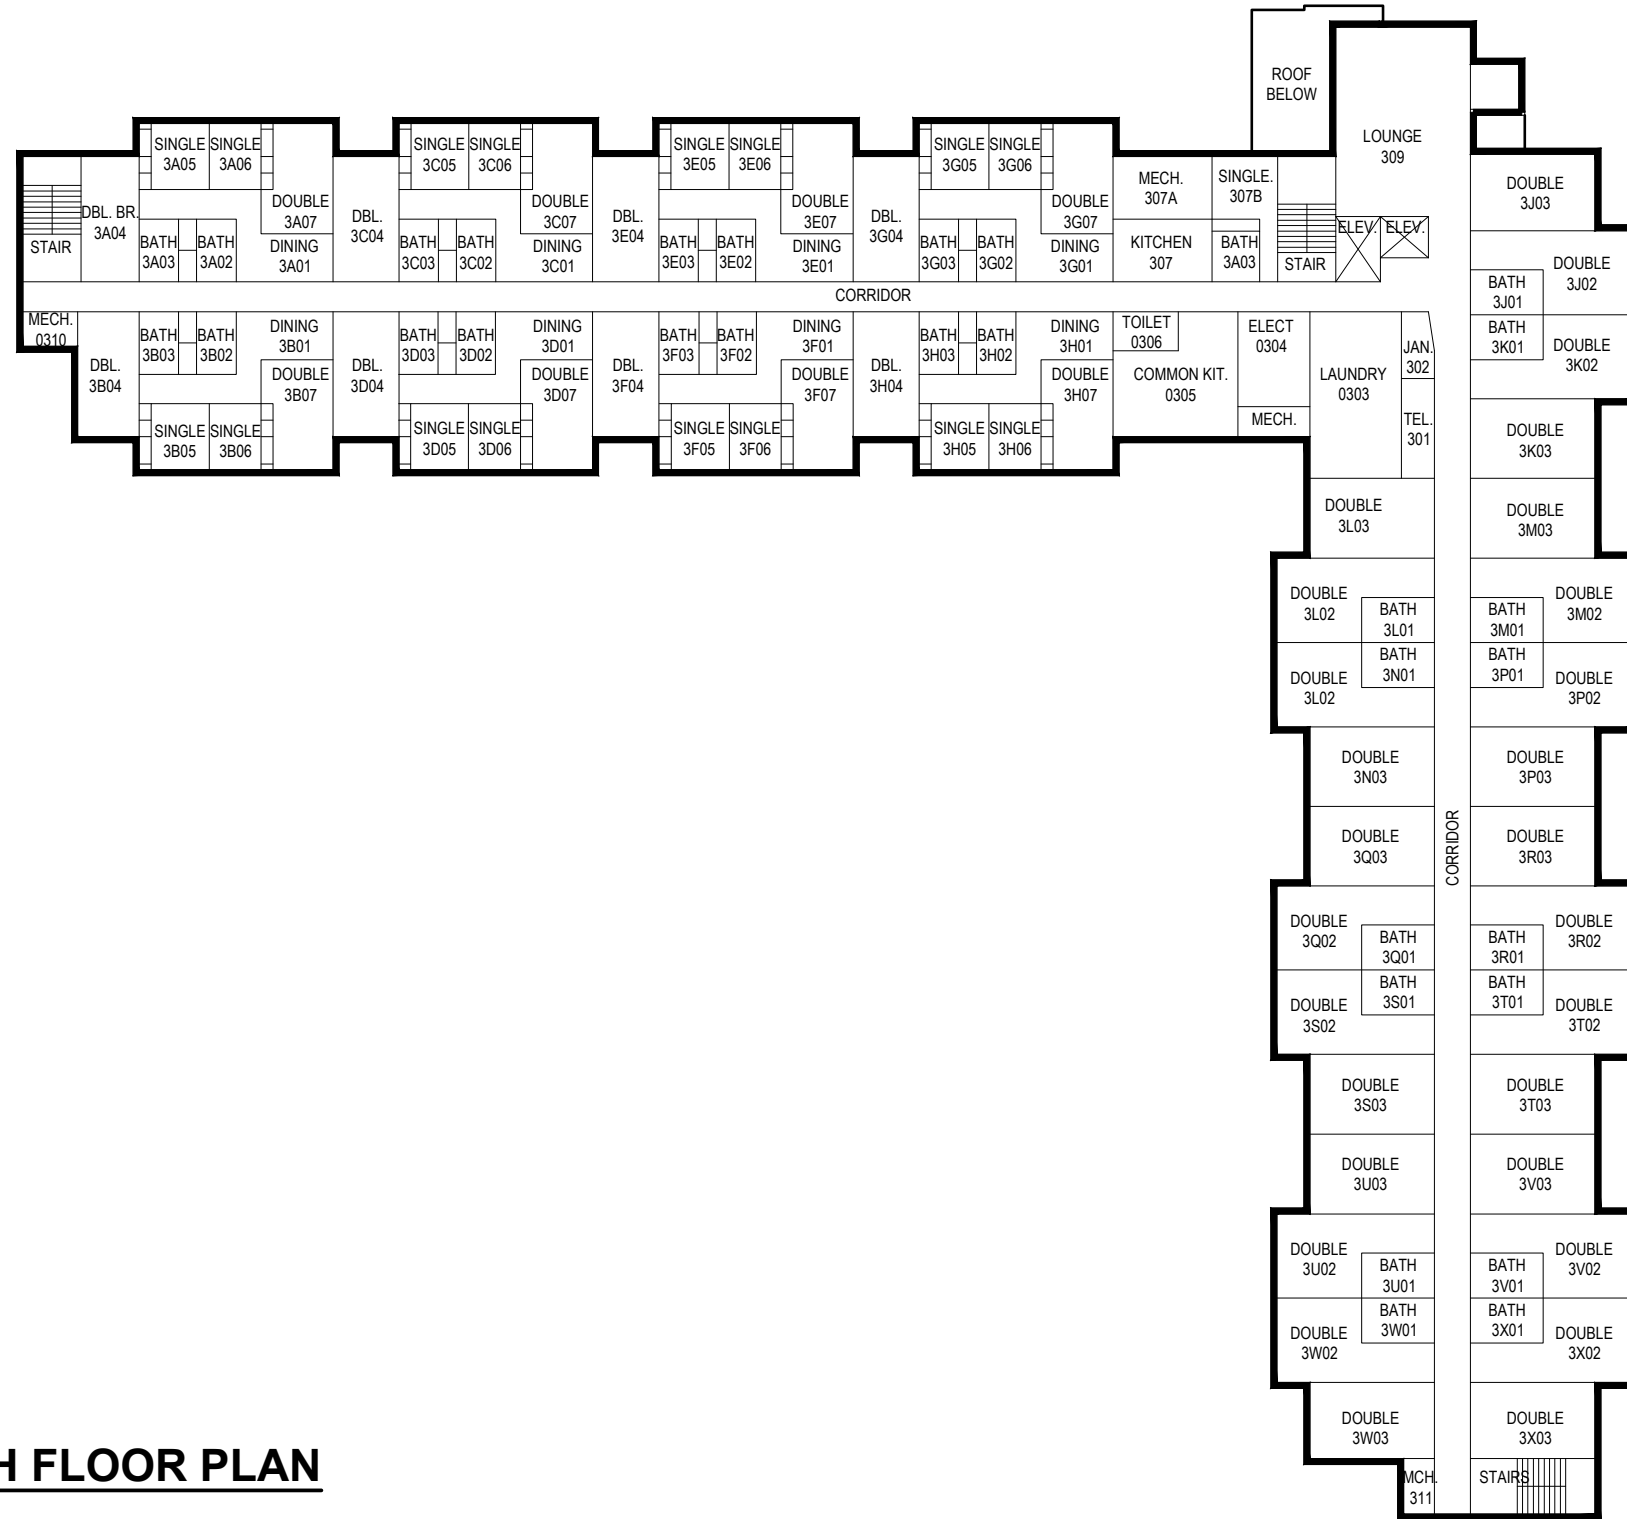

FOURTH FLOOR PLAN



CLIENT

Farmingdale State College

SCALE:

1"=30'

DATE:

JUNE-2015

Orchard Hall - 115



architects + engineers

Melville, NY Albany, NY
New City, NY Parsippany, NJ

